


THE STATE OF DELAWARE
DEPARTMENT OF TRANSPORTATION



CONSTRUCTION PLANS FOR:
**CM/GC,
NORTH MILLSBORO BYPASS,
US 113 TO SR 24**

CONTRACT NUMBER: T202112701
FEDERAL AID PROJECT NUMBER: ESTP-S113(26)

COUNTY: SUSSEX M.R. #: S24/S248/S255/S305

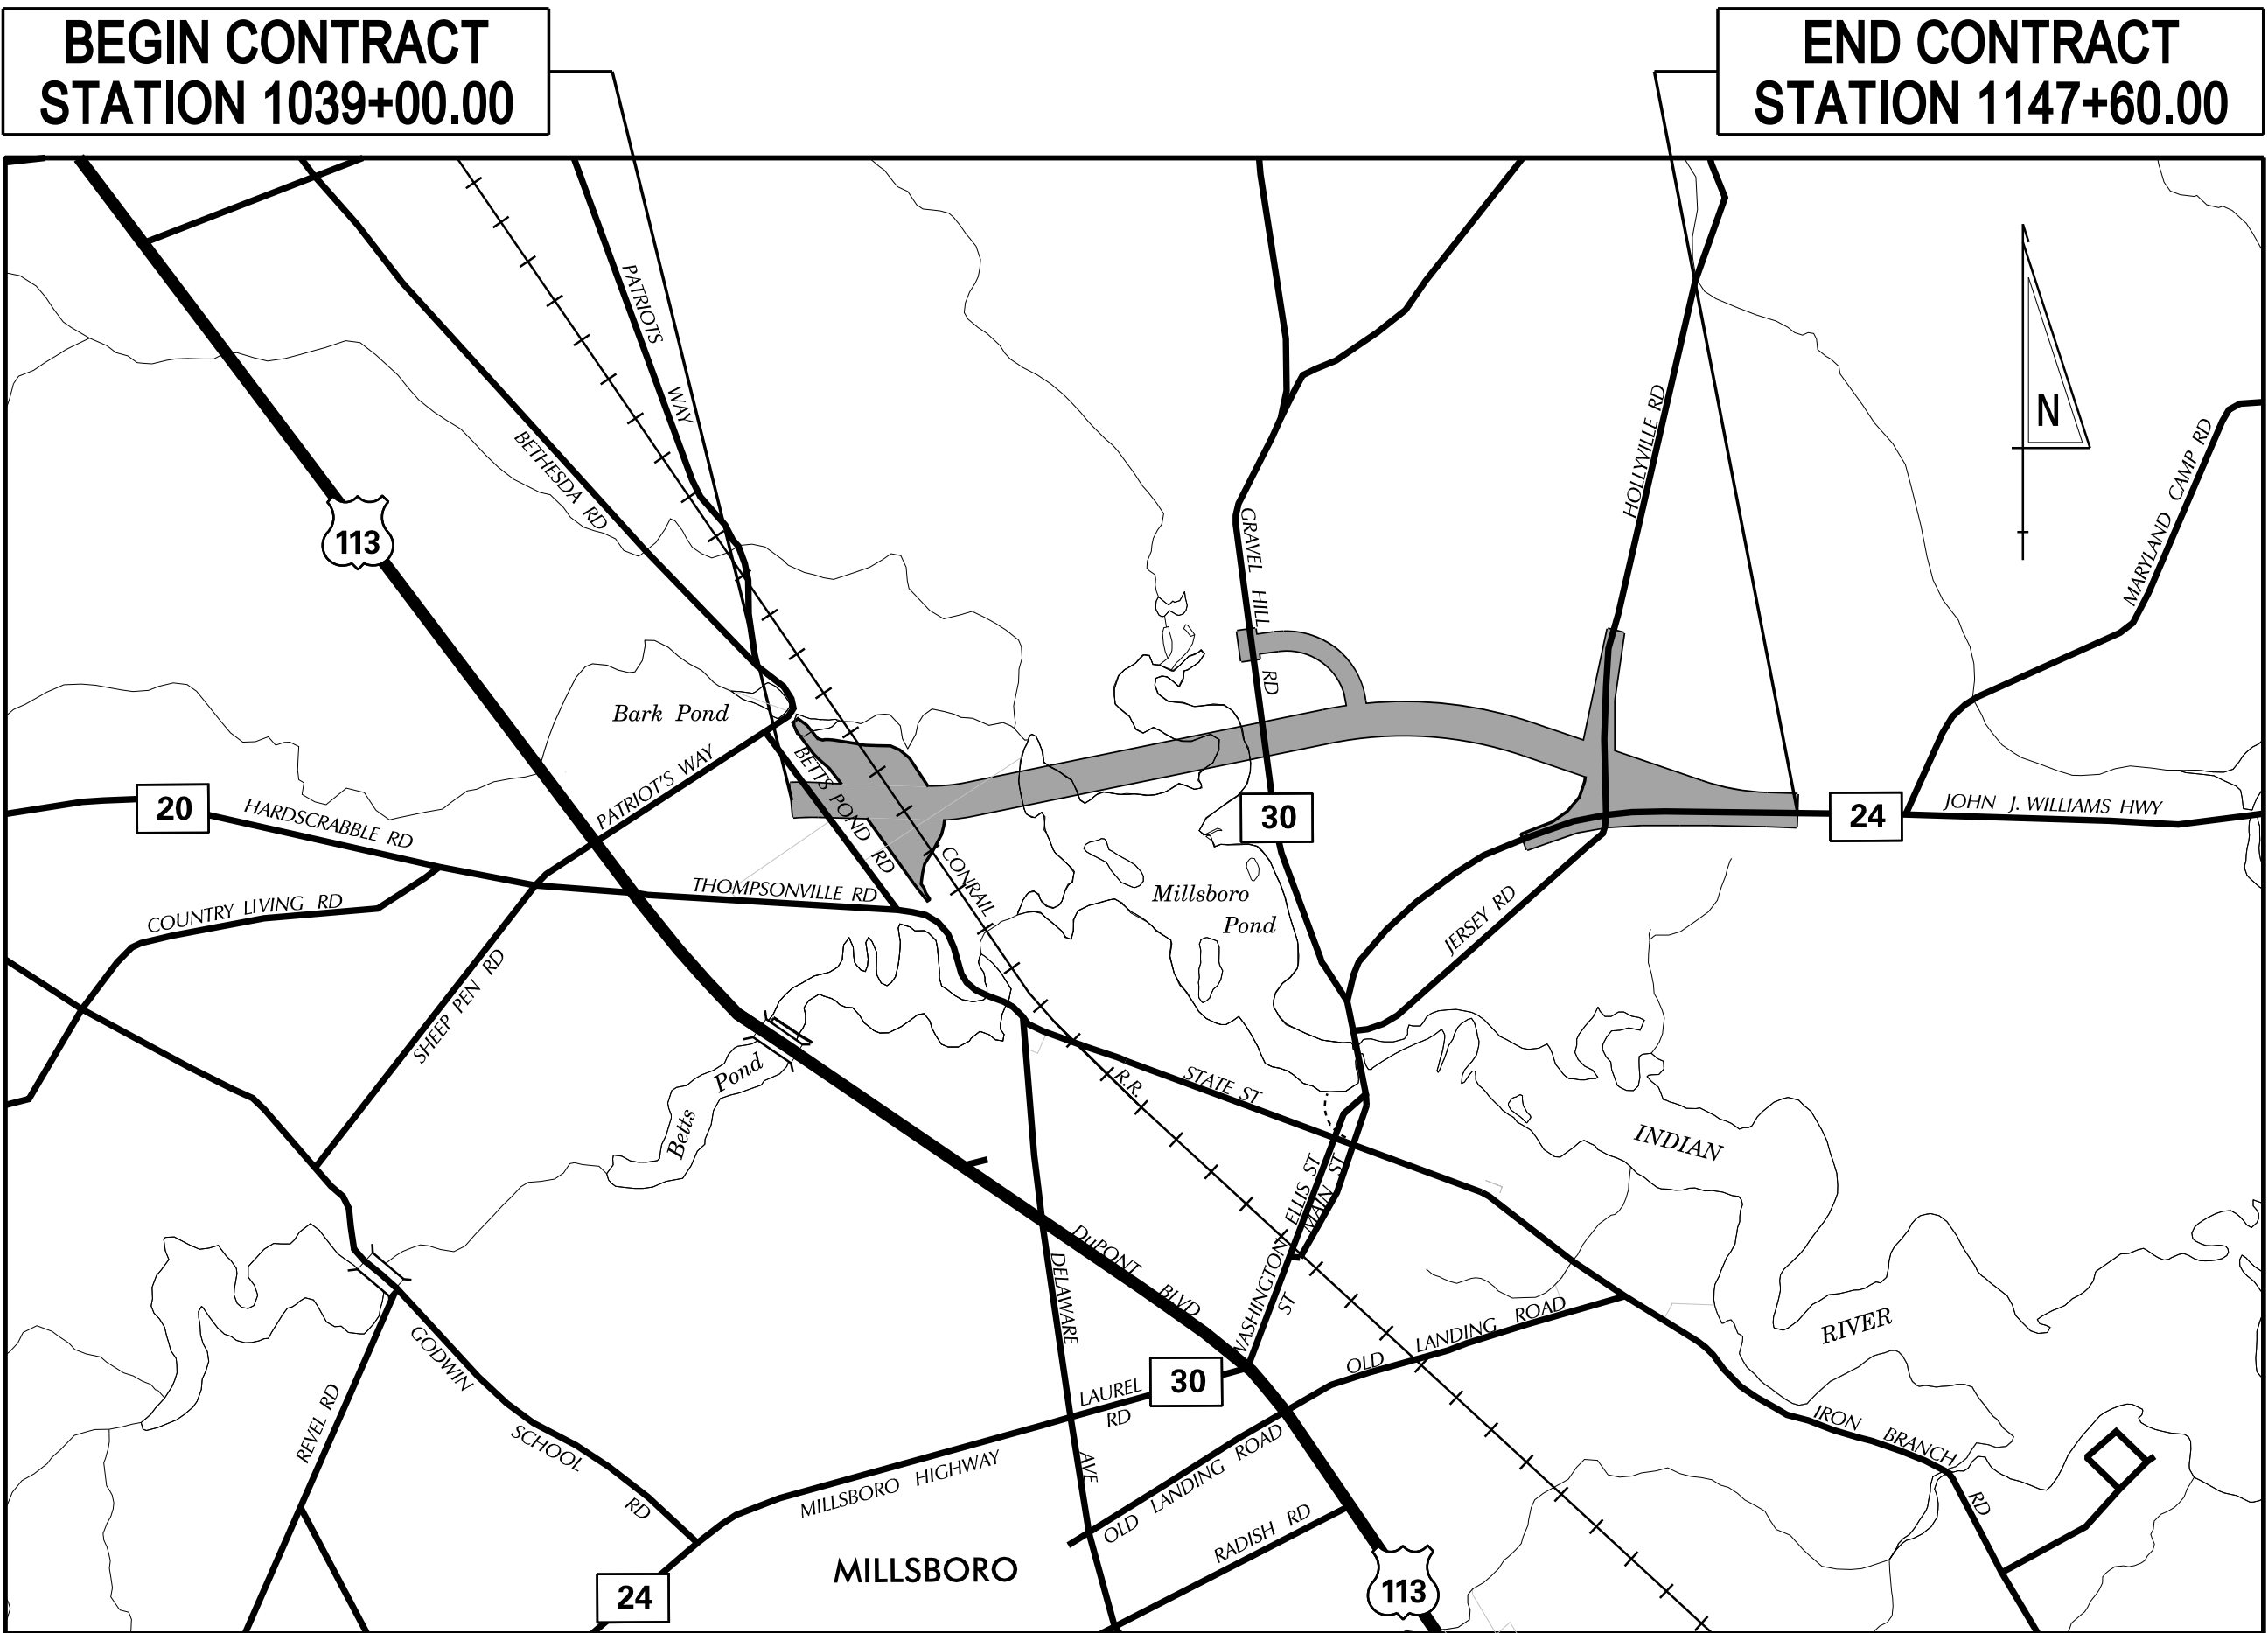

LOCATION MAP
NOT TO SCALE

U.S. CUSTOMARY
UNITS

SEMI-FINAL PLANS

DESIGN DESIGNATION

MRD #: TBD		ROAD NAME: NORTH MILLSBORO BYPASS	
FUNCTIONAL CLASS: MAJOR COLLECTOR		D.H.V. PROJECTED: 1,350	YEAR: 2050
TYPE OF CONSTRUCTION: NEW		DESIGN SPEED: 50 M.P.H.	
A.A.D.T. CURRENT: N/A	YEAR: N/A	TRUCKS: 9.3%	
A.A.D.T. PROJECTED: 11,200	YEAR: 2050	DIRECTION OF DISTRIBUTION: 58.4%	

DESIGN DESIGNATION

MRD #: S24		ROAD NAME:SR 24 (JOHN J. WILLIAMS HWY)	
FUNCTIONAL CLASS: MAJOR COLLECTOR		D.H.V. PROJECTED: 3,000	YEAR: 2050
TYPE OF CONSTRUCTION: RECONSTRUCTION		DESIGN SPEED: 50 M.P.H.	
A.A.D.T. CURRENT: 18,000	YEAR: 2015	TRUCKS: 6.4%	
A.A.D.T. PROJECTED: 24,700	YEAR: 2050	DIRECTION OF DISTRIBUTION: 58.4%	

DESIGN DESIGNATION

MRD #: S248		ROAD NAME: GRAVEL HILL ROAD	
FUNCTIONAL CLASS: MAJOR COLLECTOR		D.H.V. PROJECTED: 720	YEAR: 2050
TYPE OF CONSTRUCTION: RECONSTRUCTION		DESIGN SPEED: 50 M.P.H.	
A.A.D.T. CURRENT: 5,000	YEAR: 2015	TRUCKS: 10.3 %	
A.A.D.T. PROJECTED: 5,750	YEAR: 2050	DIRECTION OF DISTRIBUTION: 58.8 %	

DESIGN DESIGNATION

MRD #: S255		ROAD NAME: FOX RUN ROAD	
FUNCTIONAL CLASS: LOCAL		D.H.V. PROJECTED: 180	YEAR: 2050
TYPE OF CONSTRUCTION: RECONSTRUCTION		DESIGN SPEED: 30 M.P.H.	
A.A.D.T. CURRENT: 1,184	YEAR: 2015	TRUCKS: 2.0 %	
A.A.D.T. PROJECTED: 1,676	YEAR: 2050	DIRECTION OF DISTRIBUTION: 58 %	

DESIGN DESIGNATION

MRD #: S305		ROAD NAME: HOLLYVILLE ROAD	
FUNCTIONAL CLASS: LOCAL		D.H.V. PROJECTED: 560	YEAR: 2050
TYPE OF CONSTRUCTION: RECONSTRUCTION		DESIGN SPEED: 40 M.P.H.	
A.A.D.T. CURRENT: 3,300	YEAR: 2015	TRUCKS: 6.0 %	
A.A.D.T. PROJECTED: 4,500	YEAR: 2050	DIRECTION OF DISTRIBUTION: 58.8 %	


APPROVED DESIGN EXCEPTIONS

DESIGN PARAMETER	REQUIRED	PROVIDED	DATE


ASSOCIATED CONTRACTS

CONTRACT NO.	CONTRACT NAME
CS3	SR 24 JOHN J. WILLIAMS HIGHWAY, MILLSBORO TO WARWICK
CS3A	MAIN STREET MILLSBORO
145	US 113 WIDENING, SELBYVILLE TO GEORGETOWN
158	SR 30 GRAVEL HILL ROAD, ZOAR TO MILLSBORO
174	SR 20 HARDCRABBLE ROAD, MILLSBORO TO BRYANS STORE
RM187	HOLLYVILLE ROAD
483	SR 24, MILLSBORO TO HARMON SCHOOL
845	US 113, DAGSBORO ROAD (SR 20) TO GEORGETOWN
1442	SUSSEX ROADS, S 334, S 326, S 082, S 328, S 318 & S 317
1490	SR 24 & SR 30, MILLSBORO TO SHAFT OX CORNER
1859	BRIDGE 514 ON SR 24 OVER MILLSBORO POND
1881	BETHESDA ROAD PAVEMENT REHAB
6401043	SR 20, MILLSBORO TO BRYANS STORE (S 074)
6403007	SHEEP PEN ROAD PAVEMENT REHAB
6405005	US 113, DAGSBORO TO ROAD 432 PHASE II
6503004	US 113, DAGSBORO TO SUSSEX 432
6710020	BRIDGE 514 APPROACH ON SR 24 OVER INDIAN RIVER AT MILLSBORO POND
9710903	US 113, NORTH OF DAGSBORO TO NORTH OF MILLSBORO
9710904	US 113, NORTH OF MILLSBORO TO S321
9907301	BRIDGE 526 & BRIDGE 527 ON S326 AT BETTS POND MILLSBORO
T202112702	US 113 AR SR 20 GRADE SEPARATED INTERSECTION

SECTION	SHEET DESCRIPTION	SHEET NO(S)
WRA	TITLE	1
WRA	INDEX OF SHEETS	2-3
WRA	ADDENDA AND REVISIONS	4
WRA	LEGEND	5
WRA	NOTES	6-7
WRA	TYPICAL SECTIONS	8-12
WRA	HORIZONTAL AND VERTICAL CONTROL	13-16
WRA	CONSTRUCTION PLANS (CP)	17-37
WRA	PROFILES	38-58
WRA	GRADES AND GEOMETRICS (GG)	59-79
WRA	BRIDGE PLANS	80-87
WRA	STORMWATER MANAGEMENT PLANS	88-94
WRA	ENVIRONMENTAL COMPLIANCE PLANS	95-97
WRA	CONSTRUCTION PHASING, M.O.T. AND EROSION CONTROL PLANS	98-137
WRA	DETOUR PLANS	138-141
WRA	LIGHTING PLANS	142-148
WRA	UTILITY RELOCATION PLANS	149-169
WRA	SIGNING, STRIPING AND CONDUIT PLANS (SS)	170-193
WRA	SIGNALIZATION PLANS	194

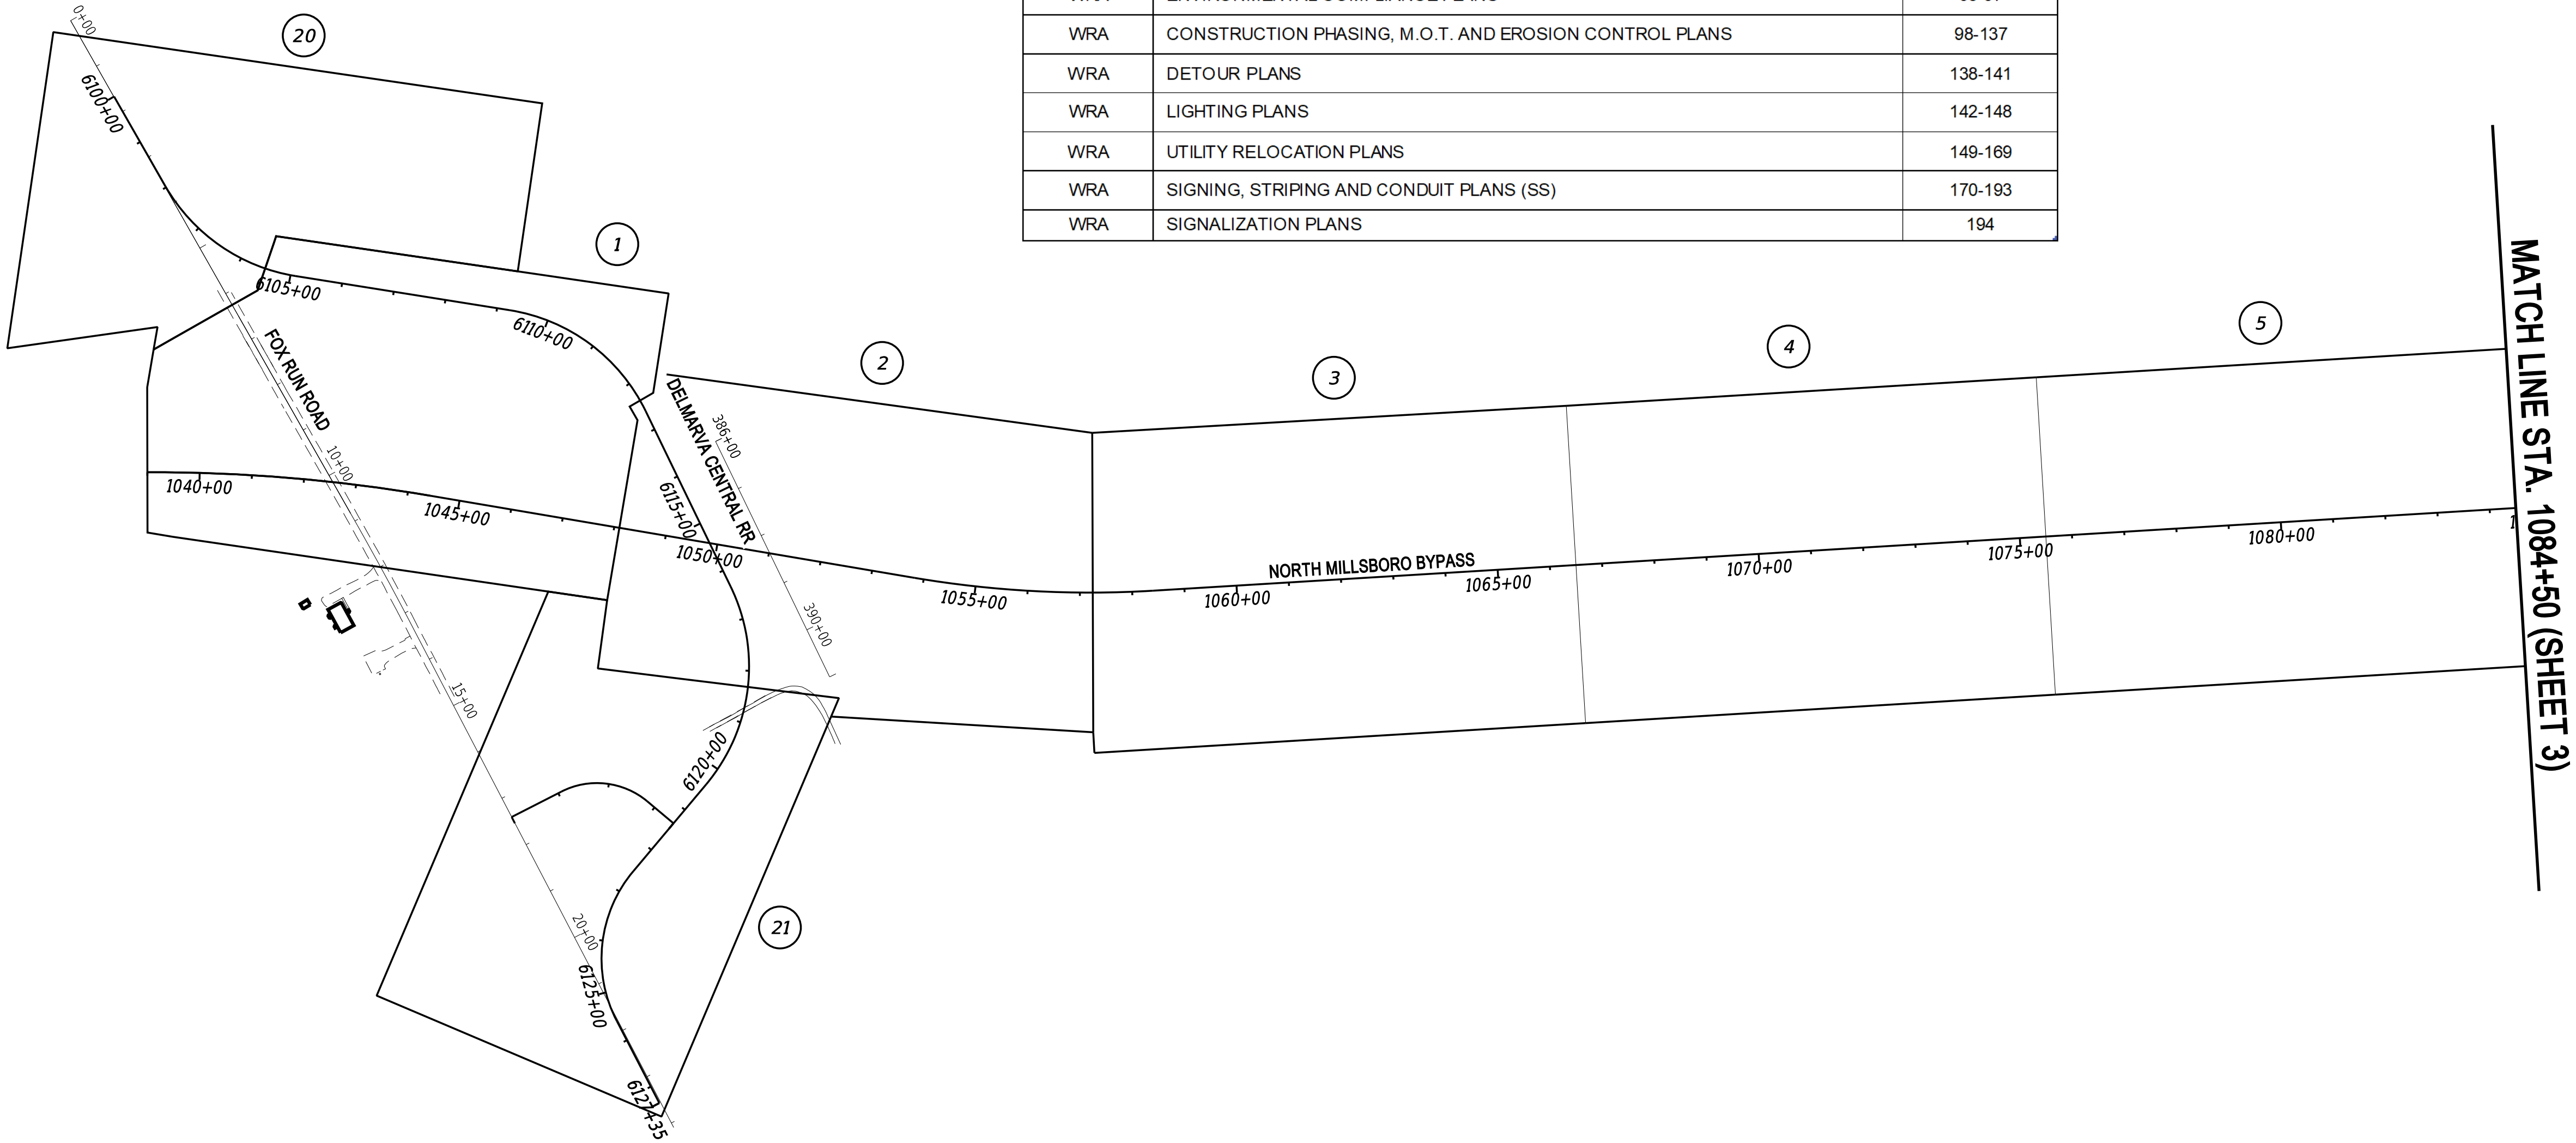

ADDENDA / REVISIONS	

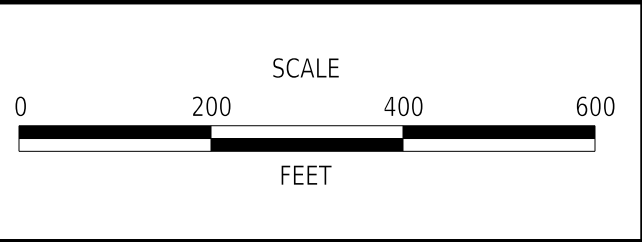


CM/GC,
NORTH MILLSBORO BYPASS,
US 113 TO SR 24


CONTRACT	BRIDGE NO.	N/A
T202112701	DESIGNED BY: S. BEALL	
COUNTY	CHECKED BY: T. OLIVER	
SUSSEX		

INDEX OF SHEETS	
SECTION	WRA
SHEET NO.	2

3/4/2022
6:13:05 PM
N:\132149-002\CADD\US 113 NM Bypass\US02_NMBP.dgn

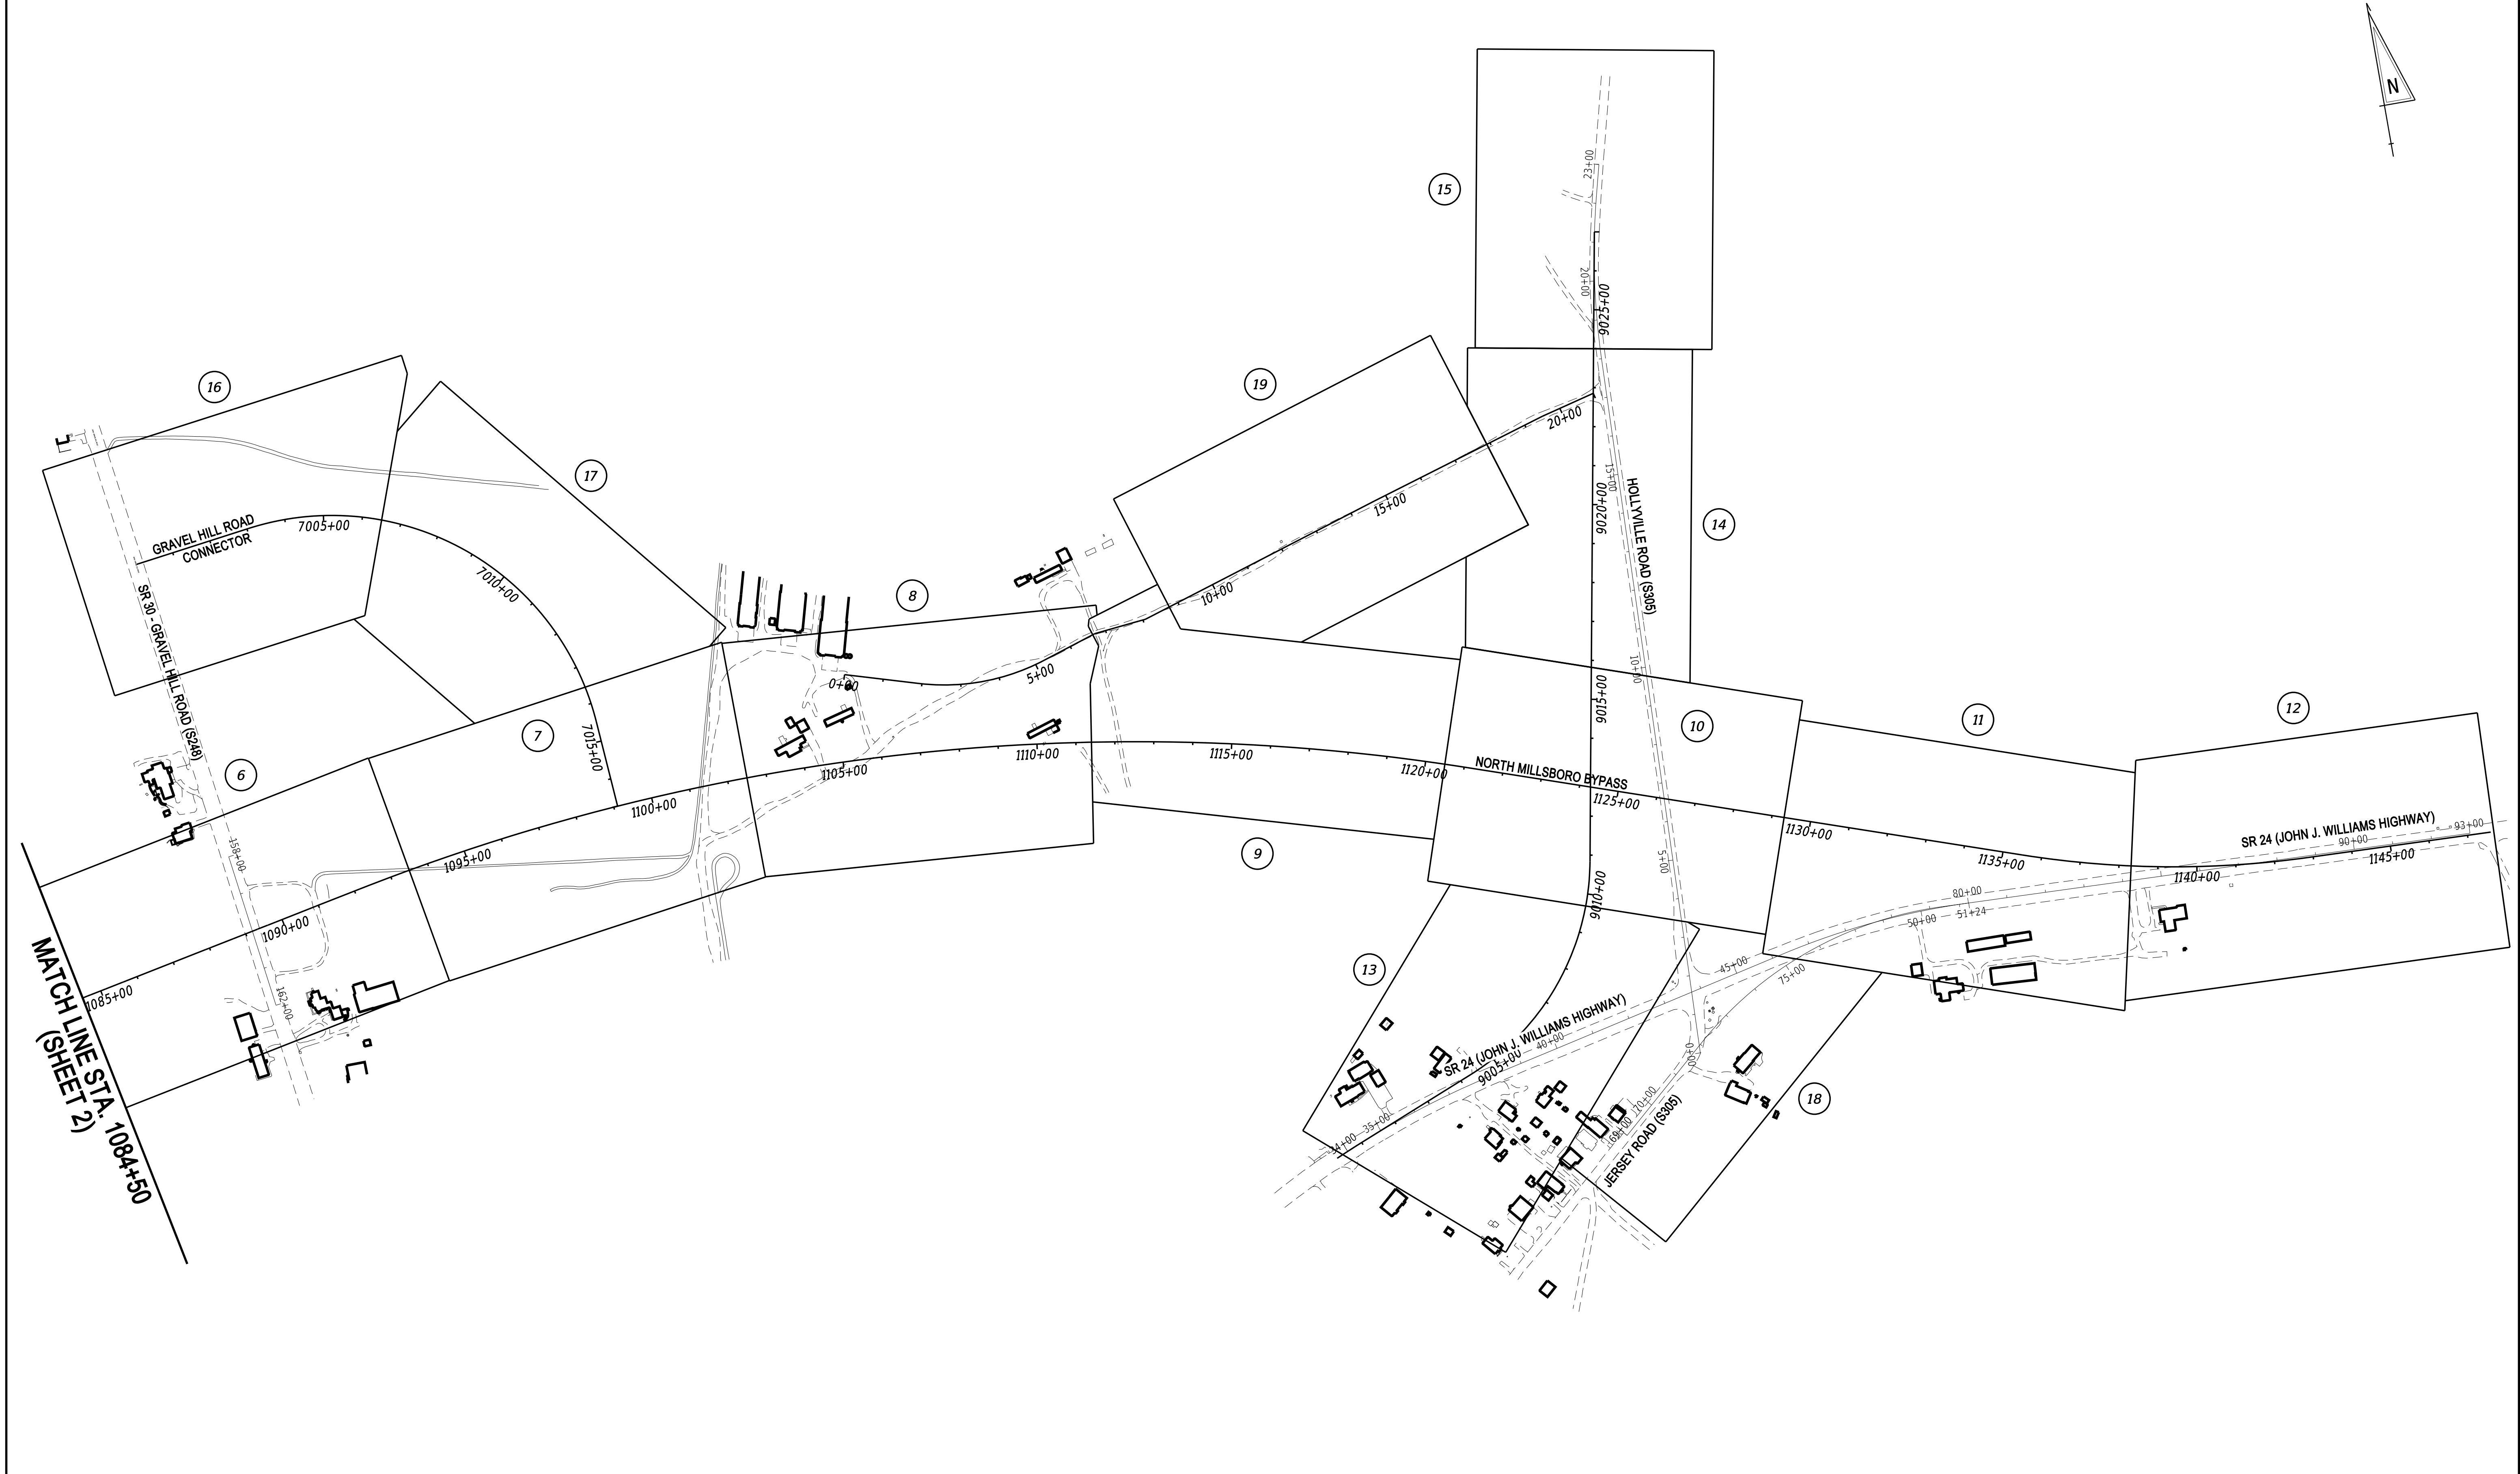

ADDENDA / REVISIONS	

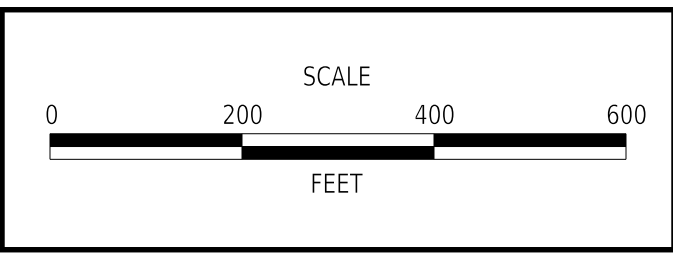

CM/GC,
NORTH MILLSBORO BYPASS,
US 113 TO SR 24

CONTRACT	BRIDGE NO.	N/A
T202112701	DESIGNED BY: S. BEALL	
COUNTY	CHECKED BY: T. OLIVER	
SUSSEX		

INDEX OF SHEETS	
SECTION	WRA
SHEET NO.	3

ADDENDUM PREPARED BY		
 Whitman, Requardt and Associates, LLP Engineers • Architects • Environmental Planners Est. 1915		









THIS SEAL APPLIES TO ALL SHEETS BEARING THE "WRA" SECTION DESIGNATION.		DATE
		SEAL





REVISION PREPARED BY		
 Whitman, Requardt and Associates, LLP Engineers • Architects • Environmental Planners Est. 1915		



THIS SEAL APPLIES TO ALL SHEETS BEARING THE "WRA" SECTION DESIGNATION.		DATE
		SEAL




ADDENDA / REVISIONS		NOT TO SCALE	CM/GC, NORTH MILLSBORO BYPASS, US 113 TO SR 24	CONTRACT	BRIDGE NO.	N/A	ADDENDA AND REVISIONS	SECTION	
				T202112701				WRA	
				COUNTY	DESIGNED BY: S. BEALL			SHEET NO.	
				SUSSEX	CHECKED BY: T. OLIVER			4	

        3/4/2022
6:13:07 PM
N:\132149-002\CADD\US 113 NM Bypass\CG01_NMBP.dgn

MANMADE ROADSIDE FEATURES			
FEATURE DESCRIPTION	EXISTING	PROPOSED	ID
BOLLARD - STEEL POLE			
BOLLARD - WOOD POST			
CURB, TYPE 1 AND TYPE 3	CURB, TYPE "X"		
CURB, TYPE 2			
CURB & GUTTER, TYPE 1			
CURB & GUTTER, TYPE 2	C&G, TYPE "X"		
CURB & GUTTER, TYPE 3			
CURB OPENING - SUMP / ON GRADE			
CURB OPENING WITH SIDEWALK			
FENCE - CHAINLINK OR STRANDED			
FENCE - STOCKADE OR SPLIT RAIL			
FLAG POLE	F.P. 		
GUARDRAIL - STEEL BEAM, TYPE 1			
GUARDRAIL - STEEL BEAM, TYPE 2			
GUARDRAIL - STEEL BEAM, TYPE 3			
GUARDRAIL - WIRE ROPE			
GUARDRAIL - END ANCHORAGE			
GUARDRAIL - END TREATMENT, TYPE 1			
GUARDRAIL - END TREATMENT, TYPE 2			
GUARDRAIL - END TREATMENT, TYPE 3			
GUARDRAIL - IMPACT ATTENUATOR			
LAMP AND POST - RESIDENTIAL	LAMP 		
MAILBOX	MB 		
PARKING METER AND POST	P.M. 		
PAVEMENT - FLEXIBLE			
PAVEMENT - RIGID			
PILE - BRIDGE			
PILLAR OR MISCELLANEOUS POST			
TRAFFIC SIGN AND POST			
WALL - BRICK OR BLOCK			
WALL - STONE			

  
 
 
DRAINAGE FEATURES			
FEATURE DESCRIPTION	EXISTING	PROPOSED	ID
BIOFILTRATION SWALE			
DITCH OR STREAM CENTERLINE			
DIRECTIONAL STREAM FLOW ARROW			
DRAINAGE INLET	C.B.  / D.I. 		
DRAINAGE JUNCTION BOX	J.B. 		
DRAINAGE MANHOLE			
DRAINAGE PIPE AND FLOW ARROW	SIZE/TYPE LABEL 		
DRAINAGE PIPE HEADWALL			
FLARED END SECTION			
RIPRAP - AREA FEATURE			
RIPRAP - LINEAR FEATURE			
SAFETY END SECTION			
UNDERDRAIN			
UNDERDRAIN OUTLET			

  UTILITY FEATURES		
FEATURE DESCRIPTION	EXISTING	PROPOSED
CABLE TV DISTRIBUTION BOX		
ELECTRIC - DELMARVA POWER	DP-E (A)	DP-E
ELECTRIC MANHOLE		
ELECTRIC METER		
ELECTRIC TRANSFORMER		
GAS - CHESAPEAKE UTILITY	CU-G (A)	
GAS - EASTERN SHORE	ESNG-G (A)	
GAS MANHOLE		
GAS METER	G.M. 	
GAS VALVE	G.V. 	
GAS PUMP - SERVICE STATION	G.P. 	
IRRIGATION - UNDERGROUND	IR(A)	IR
ITMS - UNDERGROUND	ITMS(A)	ITMS
LIGHTING - UNDERGROUND	LI(A)	LI
LUMINAIRE - POLE MOUNTED		
MANHOLE - UNDETERMINED OWNER		
RAILROAD TRACKS		
SANITARY - SUSSEX COUNTY	SC-S (A)	SC-S
SANITARY SEWER MANHOLE		
SANITARY SEWER VALVE	S.V. 	
SANITARY SEWER CLEANOUT OR VENT	S.C.O. 	
SEPTIC DRAIN FIELD	S.D.F. 	
SIGNALIZATION - UNDERGROUND	SIG(A)	SIG
SIGNALIZATION - UNDERGROUND - DELDOT	EX-CON (A)	
SOIL BORING LOCATION		
TELEPHONE BOOTH		
TELEPHONE MANHOLE		
TELEPHONE - VERIZON	VER-C (A)	VER-C
TELEPHONE - VERIZON - FIBER OPTIC	VER-FO (A)	
TELEPHONE TEST POINT		
TRAFFIC - CONDUIT JUNCTION WELL	J.W. 	
TRAFFIC - LIGHT POLE AND BASE		
TRAFFIC - PEDESTRIAN POLE & BASE		
TRAFFIC - SIGNAL CABINET & BASE		
TRAFFIC - SIGNAL POLE AND BASE		
UTILITY BOX		
UTILITY POLE GUY WIRE ANCHOR		
UTILITY POLE		
UTILITY TEST HOLE LOCATION		
WATER - TOWN OF GEORGETOWN	SC-W (A)	SC-W
WATER - TOWN OF MILLSBORO	TMB-W (A)	
WATER - FIRE HYDRANT	F.H. 	F.H. 
WATER METER	W.M. 	
WATER VALVE	W.V. 	W.V. 
WELL HEAD	WELL 	

   NATURAL ROADSIDE FEATURES		
FEATURE DESCRIPTION	EXISTING	PROPOSED
HEDGEROW OR THICKET		
MARSH BOUNDARY LINE		
TREE - CONIFEROUS		
TREE - DECIDUOUS		
TREE STUMP		
SHRUBBERY		
WETLAND BOUNDARY - DELINEATED	WL 	
WOODS LINE BOUNDARY		

RIGHT-OF-WAY FEATURES		
FEATURE DESCRIPTION	EXISTING	PROPOSED
DENIAL OF ACCESS	DA	DA
EASEMENT - OTHERS	EASEMENT TYPE	
PERMANENT EASEMENT	PE	PE
PROPERTY LINE		
PROPERTY MARKER - CONCRETE	C.M. 	
PROPERTY MARKER - IRON PIPE	I.P. 	
RIGHT-OF-WAY BASELINE	100+00	100+00
RIGHT-OF-WAY LINE		R/W
RIGHT-OF-WAY & DENIAL OF ACCESS	R/W-DA	R/W-DA
RIGHT-TO-ENTER		RTE
TEMPORARY CONSTRUCTION EASEMENT		TCE

SURVEY CONTROL & MONUMENTATION	
FEATURE DESCRIPTION	EXISTING
POINT OF CURVATURE OR TANGENCY	
POINT OF INTERSECTING TANGENTS	
SURVEY BENCHMARK LOCATION	B.M. 
SURVEY NGS POINT LOCATION	
SURVEY TIE POINT LOCATION	T.P. 
SURVEY TRAVERSE POINT	

   MISCELLANEOUS FEATURES	
FEATURE DESCRIPTION	PROPOSED
BARRIER, DOUBLE-FACED, PERMANENT	
BARRIER, SINGLE-FACED, PERMANENT, TEST LEVEL 4 / TEST LEVEL 5	
BRICK PATTERNED SURFACE	
BUTT JOINT	
CLEAR ZONE	CZ
CONSTRUCTION BASELINE	100+00
LATERAL OFFSET	LO
LIMIT OF CONSTRUCTION	LOC
PAVEMENT PATCH	
PAVEMENT REMOVAL - TOPSOIL, SEED AND MULCH	
P.C.C. SIDEWALK - 4"	
P.C.C. SIDEWALK - 6" (USE 8" DEPTH FOR CHANNELIZATION ISLANDS.)	
TURF REINFORCEMENT MAT, TYPE 1	
INFILTRATION TRENCH	

IDENTIFIERS	
FEATURE DESCRIPTION	ID
ABANDON BY CONTRACTOR	
ABANDON BY OTHERS	
ADJUST BY CONTRACTOR	
ADJUST BY OTHERS	
BEST MANAGEMENT PRACTICE	
BUS STOP PAD / TYPE	
BUS STOP WITH SHELTER PAD / TYPE	
CONCRETE SAFETY BARRIER	
CONVERT TO JUNCTION BOX	
CONVERT TO DRAINAGE MANHOLE	
DO NOT DISTURB	
ENERGY DISSIPATOR	
FILL WITH FLOWABLE FILL	
LANDSCAPE PLANTINGS	
PEDESTRIAN CONNECTION / TYPE	
PEDESTRIAN CONNECTION / TYPE WITHOUT DETECTABLE WARNING SYSTEM	
RELOCATE BY CONTRACTOR	
RELOCATE BY OTHERS	
RELOCATE BY PROPERTY OWNER	
REMOVE BY CONTRACTOR	
REMOVE BY OTHERS	
REMOVE BY TRAFFIC CONTRACTOR	
RIGHT-OF-WAY MONUMENT	

PAVEMENT SECTION(S)	
OVERLAY PAVEMENT - SEE TYPICAL SECTIONS FOR MATERIALS AND DEPTHS	
RECONSTRUCTED PAVEMENT - SEE TYPICAL SECTIONS FOR MATERIALS AND DEPTHS	
DRIVEWAY AND ENTRANCE PAVEMENT - SEE NOTES FOR MATERIALS AND DEPTHS	

ADDENDA / REVISIONS	

NOT TO SCALE	CM/GC, NORTH MILLSBORO BYPASS, US 113 TO SR 24	CONTRACT	BRIDGE NO.	N/A	LEGEND	SECTION
		T202112701	DESIGNED BY: S. BEALL			WRA
		COUNTY				SHEET NO.
		SUSSEX	CHECKED BY: T. OLIVER	5		

GENERAL NOTES

1. THIS PROJECT IS TO BE CONSTRUCTED IN ACCORDANCE WITH THE DELAWARE DEPARTMENT OF TRANSPORTATION "STANDARD SPECIFICATIONS", DATED AUGUST 2016 AND THE DELAWARE DEPARTMENT OF TRANSPORTATION "STANDARD CONSTRUCTION DETAILS", DATED 2018, INCLUDING ALL REVISIONS UP TO THE DATE OF ADVERTISEMENT.

2. ELECTRONIC DESIGN DATA FILES THAT WILL BE MADE AVAILABLE TO THE AWARDED CONTRACTOR, INCLUDE:

()	NONE
(X)	ASCII DATA FILES WITH COORDINATES AND ELEVATIONS FOR PROPOSED POINTS AS SELECTED BY THE ENGINEER.
(X)	EXISTING DIGITAL TERRAIN MODEL, IN .DTM FILE FORMAT, COMPATIBLE WITH SOFTWARE CURRENTLY USED BY DELDOT.
(X)	PROPOSED DIGITAL TERRAIN MODEL, IN .DTM FILE FORMAT, COMPATIBLE WITH SOFTWARE CURRENTLY USED BY DELDOT.
(X)	DESIGN FILE, IN .DGN FILE FORMAT, THAT CONTAINS 3D FEATURE LINES FOR THE PROPOSED DESIGN. 3D FEATURE LINES ARE FOR THE PROPOSED TOP SURFACE ELEVATION ONLY.

NOTE: THE DOCUMENT ENTITLED "RELEASE FOR DELIVERY" OF DOCUMENTS IN ELECTRONIC FORM TO A CONTRACTOR" MUST BE SIGNED BY ALL PARTIES PRIOR TO THE DELIVERY OF ANY ELECTRONIC PROJECT FILES.

NOTE: THERE MAY BE SOME AREAS OF THE PROJECT NOT INCLUDED IN THE ELECTRONIC DESIGN DATA FILE(S). IT IS THE CONTRACTOR'S RESPONSIBILITY TO REVIEW THE DESIGN DATA FILE AND DETERMINE THE LIMITS OF THE PROJECT INCLUDED.

3. PROJECT FILES THAT WILL BE MADE AVAILABLE TO THE CONTRACTOR, INCLUDE:

(X)	CROSS SECTIONS
(X)	RIGHT-OF-WAY PLANS (WILL BE MADE AVAILABLE TO THE AWARDED CONTRACTOR)

PROJECT NOTES

SECTION 100

1. ANY DAMAGE TO ITEMS NOTED TO BE RELOCATED OR RESET BY THE CONTRACTOR, AT THE DISCRETION OF THE ENGINEER, SHALL BE REPAIRED AND/OR REPLACED IN KIND AT THE CONTRACTOR'S EXPENSE.
2. THE CONTRACTOR WILL CONTACT THE DELAWARE TMC AT 302-659-4600 PRIOR TO ANY UNMANNED AERIAL VEHICLE (UAV) FLIGHTS. THE CONTRACTOR WILL BE REQUIRED TO PROVIDE THE FOLLOWING INFORMATION: THE REGISTRATION NUMBER OF THE UAV, THE FLIGHT TIME, LOCATION OF THE FLIGHT, THE PILOT'S NAME AND THE PILOT'S CONTACT NUMBER DURING THE FLIGHT.

SECTION 200

3. THE CONTRACTOR SHALL REMOVE AND RESET ALL MAILBOXES TO MAINTAIN MAIL SERVICE AS DIRECTED BY THE ENGINEER. THE CONTRACTOR SHALL RELOCATE MAILBOXES AS REQUIRED BY THE PROPOSED GEOMETRICS AND AS DIRECTED BY THE ENGINEER. WHEN RELOCATING MAILBOXES IN CURBED SECTIONS, THE FACE OF THE MAILBOX SHALL BE FLUSH WITH THE BACK EDGE OF CURB. WHEN RELOCATING MAILBOXES IN OPEN SECTIONS, THE FACE OF THE MAILBOX SHALL SET BACK 8 INCHES FROM THE EDGE OF THE PAVED SHOULDER. THE BOTTOM OF THE MAILBOX SHALL BE POSITIONED IN ACCORDANCE WITH THE LATEST VERSION OF THE UNITED STATES POSTAL SERVICE GUIDELINES. MAILBOXES LOCATED AT DRIVEWAY ENTRANCES SHALL BE PLACED ON THE FAR SIDE OF THE DRIVEWAY IN THE DIRECTION OF TRAVEL. POSTS BEING RESET IN CONCRETE SIDEWALK SHALL BE PLACED IN AN APPROPRIATE SIZE PVC SLEEVE. ACCEPTABLE POST SHALL BE 4 INCH X 4 INCH WOOD POST OR 4 INCH DIAMETER WOOD POST. FOR RELOCATING MULTIPLE MAILBOXES TOGETHER ALL POST SHALL BE SEPARATED BY A DISTANCE OF NO LESS THAN 3/4 OF THEIR FULL HEIGHT ABOVE THE GROUND. MULTIPLE MAILBOXES ATTACHED TO A SINGLE HORIZONTAL BOARD SHALL NOT BE LOCATED INSIDE THE CLEARZONE. EACH MAIL BOX SHALL BE PLACED ON AN INDIVIDUAL POST MEETING THE CRITERIA ABOVE. ALL MAILBOXES SHALL BE SET NOT TO IMPEDE THE MINIMUM PAR (PEDESTRIAN ACCESS ROUTE) WIDTH AS DETERMINED BY THE CURRENT EDITION OF THE PEDESTRIAN ACCESSIBILITY STANDARDS FOR FACILITIES IN THE PUBLIC RIGHT OF WAY. IF MAILBOXES ARE NOT SET IN ACCORDANCE WITH THE ABOVE DIRECTIONS, RESETTNG OF THE MAILBOXES WILL BE AT THE COST OF THE CONTRACTOR. COST FOR ALL WORK AND MATERIALS SHALL BE PAID UNDER ITEM 201000 - CLEARING AND GRUBBING.
4. ITEMS TO BE REMOVED UNDER ITEM 211000 - REMOVAL OF STRUCTURES AND OBSTRUCTIONS SHALL INCLUDE, BUT NOT BE LIMITED TO THE FOLLOWING:
- a. CONCRETE SUPPORT FOUNDATIONS FOR MISCELLANEOUS SMALL STRUCTURES NOT COVERED UNDER OTHER PAY ITEMS
 - b. FENCES
 - c. POLE BASES
 - d. DRAINAGE STRUCTURES AND PIPES BEYOND THE LIMITS OF ROADWAY EXCAVATION
5. UNLESS OTHERWISE NOTED AS DO NOT DISTURB OR ADJUST BY CONTRACTOR/OTHERS, ALL EXISTING FEATURES, INCLUDING TREES, WITHIN THE PROPOSED LOC SHALL BE REMOVED BY THE CONTRACTOR AND PAID FOR UNDER THE RESPECTIVE BID ITEM. REMOVAL OF EXISTING STORM DRAIN PIPE SHALL BE PAID UNDER ITEM 202000 UNLESS NOTED WITH A FLOWABLE FILL IDENTIFIER, REMOVAL OF TREES AND SHRUBS SHALL BE PAID FOR UNDER 201000, AND REMOVAL OF ADDITIONAL EXISTING FEATURES SHALL BE PAID FOR UNDER ITEM 210000 AS NOTED IN SECTION 200 OF THE PROJECT NOTES.

SECTION 400

6. THE PAVEMENT SECTION FOR FLEXIBLE PAVEMENT RESIDENTIAL DRIVEWAYS SHALL BE 2" BITUMINOUS CONCRETE, TYPE 'C' OVER 8" GRADED AGGREGATE BASE COURSE, TYPE 'B', UNLESS OTHERWISE NOTED ON THE PLANS

SECTION 600

7. DRAINAGE INLET GRATES ADJACENT TO THE CURB OR EDGE PAVING, WITHIN THE PROJECT LIMITS, WHICH ARE NOT TYPE 1 OR TYPE 4, SHALL BE REPLACED WITH TYPE 1. INLET GRATES WITHIN THE PAVING, NOT ADJACENT TO THE CURB OR EDGE OF PAVING SHALL BE REPLACED WITH TYPE 3. THE ACTUAL LOCATIONS, THE NEED FOR ANY GRATE MODIFICATIONS OR FOR NEW FRAMES SHALL BE DETERMINED BY THE ENGINEER. ALL REPLACED GRATES/FRAMES SHALL BE DELIVERED TO THE NEAREST DISTRICT MAINTENANCE YARD WITH THE COST OF DELIVERY INCIDENTAL TO ITEM 602100 - REPLACING DRAINAGE INLET GRATE(S) & ITEM 602101 - REPLACING DRAINAGE INLET FRAME(S). FINAL PAYMENT FOR REPLACED GRATES/FRAMES SHALL NOT BE MADE UNTIL RECEIPT OF DELIVERED MATERIALS IS PRODUCED, SIGNED BY A DELDOT MAINTENANCE YARD SUPERVISOR.
8. STATION AND ELEVATION DATA GIVEN FOR DRAINAGE STRUCTURES ARE TO BE APPLIED TO THE CENTER OF THE GRATE FOR INLETS AND TO THE CENTER OF THE STRUCTURE FOR JUNCTION BOXES AND MANHOLES.

SECTION 700

9. IN AREAS WHERE PROPOSED CURB MEETS EXISTING CURB AND THE TWO CURB TYPES ARE NOT SIMILAR, THE PROPOSED CURB SHALL BE TRANSITIONED IN 10 LINEAR FEET, UNLESS OTHERWISE DIRECTED BY THE ENGINEER. THE TRANSITIONED CURB WORK SHALL BE MEASURED AND PAID FOR UNDER THE PROPOSED CURB ITEM. SAW CUTTING OF THE EXISTING CURB SHALL BE INCIDENTAL TO THE PROPOSED CURB ITEM.
10. WHERE PROPOSED CONCRETE SIDEWALK IS CONSTRUCTED TO MEET EXISTING SIDEWALK, THE EXISTING SIDEWALK SHALL BE SAWCUT AT THE TIE-IN POINT OR MEET THE NEAREST EXISTING SIDEWALK JOINT. ALL SAW CUTTING SHALL BE FULL DEPTH, UNLESS OTHERWISE NOTED ON THE PLANS OR DIRECTED BY THE ENGINEER AND SHALL BE PAID FOR UNDER ITEM 762001 - SAW CUTTING, CONCRETE, FULL DEPTH.
11. PORTLAND CEMENT CONCRETE CHANNELIZING ISLANDS THAT ARE LESS THAN 75 SQ FT MAY BE POURED MONOLITHICALLY, OR AS DIRECTED BY THE ENGINEER.
12. ALL PAVED AREAS TO BE RECONSTRUCTED OR WIDENED SHALL BE SAWCUT AT THE POINT WHERE THE NEW PAVEMENT IS TO TIE INTO THE EXISTING PAVEMENT.
13. ALL RUMBLE STRIPS SHALL BE INSTALLED AFTER THE FINAL SURFACE COURSE HAS BEEN LAID AND SHALL NOT BE INSTALLED UNTIL TRAFFIC HAS BEEN SHIFTED INTO THE ULTIMATE CONFIGURATION. ITEM 760003 - BIKE FRIENDLY RUMBLE STRIPS, CONCRETE SHALL BE INSTALLED AT THE FOLLOWING LOCATIONS:
- NORTH MILLSBORO BYPASS FROM STA. 1039+00 TO STA. 1046+75
NORTH MILLSBORO BYPASS FROM STA. 1054+00 TO STA. 1060+50
NORTH MILLSBORO BYPASS FROM STA. 1072+50 TO STA. 1078+75
NORTH MILLSBORO BYPASS FROM STA. 1092+25 TO STA. 1098+00
NORTH MILLSBORO BYPASS FROM STA. 1100+00 TO STA. 1119+00
NORTH MILLSBORO BYPASS FROM STA. 1130+00 TO STA. 1142+50
14. GUARDRAIL POST CAPS SHALL BE PLACED ON ALL GUARDRAIL POSTS INSTALLED ALONG THE PROPOSED SHARED USE PATH. THEY WILL BE PAID FOR IN ACCORDANCE WITH ITEM 721515 - GUARDRAIL POST CAP.

SECTION 900

15. THIS PROJECT IS COVERED UNDER AN NPDES GENERAL PERMIT FOR CONSTRUCTION. UNDER THE GENERAL PERMIT, COMPLIANCE WITH DELDOT'S APPROVED SEDIMENT AND STORMWATER MANAGEMENT PLANS WILL CONSTITUTE COMPLIANCE WITH THE NPDES INDUSTRIAL PERMITTING REQUIREMENTS FOR THIS CONSTRUCTION PROJECT. A COPY OF THE NPDES GENERAL PERMIT AND NOI IS KEPT ON FILE IN EACH OF THE CONSTRUCTION OFFICES AND THE DEPARTMENT'S STORMWATER SECTION. A COPY OF THE GENERAL PERMIT OR THE NOI CAN BE OBTAINED UPON REQUEST FROM EITHER THE DEPARTMENT'S STORMWATER ENGINEER OR THE APPROPRIATE CONSTRUCTION ENGINEER.
16. THE CONTRACTOR SHALL NOTIFY DART FIRST STATE AT DOT_DETOURS@DELAWARE.GOV AT LEAST 14 DAYS PRIOR TO THE START OF ANY DETOURS OR CONSTRUCTION, AND DOT_DTC_PROJECTDEVELOPMENT@DELAWARE.GOV AT SUCH TIME THE FACILITY IS COMPLETED AND OPERABLE FOR TRANSIT OPERATIONS. FOR EMERGENCY DETOUR INFORMATION ONLY, PLEASE CONTACT DTC'S CHIEF SCHEDULER AT 302-576-6019.
17. UNLESS OTHERWISE NOTED AS DO NOT DISTURB OR ADJUST BY CONTRACTOR/OTHERS, ALL EXISTING FEATURES, INCLUDING TREES, WITHIN THE PROPOSED LOC SHALL BE REMOVED BY THE CONTRACTOR AND PAID FOR UNDER THE RESPECTIVE BID ITEM. REMOVAL OF EXISTING STORM SEWER SHALL BE PAID FOR UNDER ITEM 202000, REMOVAL OF TREES AND SHRUBS SHALL BE PAID FOR UNDER 201000, REMOVAL OF ADDITIONAL EXISTING FEATURES SHALL BE PAID FOR UNDER ITEM 211000, AS NOTED IN SECTION 200 OF THE PROJECT NOTES.
18. ALL DART SIGNS HAVE BEEN UPDATED TO A NEW DESIGN. THE DELDOT SIGN SHOP DOES NOT FABRICATE THE UPDATED SIGN OR ANY SUPPLEMENTAL PLAQUES TO ALLOW FOR ADDITIONAL ROUTE NUMBERS. ALL REQUEST FOR FABRICATION OF THESE SIGNS MUST BE MADE THROUGH DART TRANSIT AT (302) 576-6132.
19. THE CONTRACTOR SHALL COORDINATE WITH THE CONTRACTOR FOR CONTRACT T202112702 - US 113 AT SR 20 GSI TO ESTABLISH STAGING AREAS, ACCESS, AND CONSTRUCTION PHASING TO ENSURE THAT BOTH PROJECTS CAN BE OPEN TO TRAFFIC BY MAY 2025.

MISCELLANEOUS

16. THE CONTRACTOR SHALL NOTIFY DART FIRST STATE AT DOT_DETOURS@DELAWARE.GOV AT LEAST 14 DAYS PRIOR TO THE START OF ANY DETOURS OR CONSTRUCTION, AND DOT_DTC_PROJECTDEVELOPMENT@DELAWARE.GOV AT SUCH TIME THE FACILITY IS COMPLETED AND OPERABLE FOR TRANSIT OPERATIONS. FOR EMERGENCY DETOUR INFORMATION ONLY, PLEASE CONTACT DTC'S CHIEF SCHEDULER AT 302-576-6019.
17. UNLESS OTHERWISE NOTED AS DO NOT DISTURB OR ADJUST BY CONTRACTOR/OTHERS, ALL EXISTING FEATURES, INCLUDING TREES, WITHIN THE PROPOSED LOC SHALL BE REMOVED BY THE CONTRACTOR AND PAID FOR UNDER THE RESPECTIVE BID ITEM. REMOVAL OF EXISTING STORM SEWER SHALL BE PAID FOR UNDER ITEM 202000, REMOVAL OF TREES AND SHRUBS SHALL BE PAID FOR UNDER 201000, REMOVAL OF ADDITIONAL EXISTING FEATURES SHALL BE PAID FOR UNDER ITEM 211000, AS NOTED IN SECTION 200 OF THE PROJECT NOTES.
18. ALL DART SIGNS HAVE BEEN UPDATED TO A NEW DESIGN. THE DELDOT SIGN SHOP DOES NOT FABRICATE THE UPDATED SIGN OR ANY SUPPLEMENTAL PLAQUES TO ALLOW FOR ADDITIONAL ROUTE NUMBERS. ALL REQUEST FOR FABRICATION OF THESE SIGNS MUST BE MADE THROUGH DART TRANSIT AT (302) 576-6132.
19. THE CONTRACTOR SHALL COORDINATE WITH THE CONTRACTOR FOR CONTRACT T202112702 - US 113 AT SR 20 GSI TO ESTABLISH STAGING AREAS, ACCESS, AND CONSTRUCTION PHASING TO ENSURE THAT BOTH PROJECTS CAN BE OPEN TO TRAFFIC BY MAY 2025.

ADDENDA / REVISIONS		NOT TO SCALE	CM/GC, NORTH MILLSBORO BYPASS, US 113 TO SR 24	CONTRACT	BRIDGE NO.	N/A	NOTES	SECTION
				T202112701				WRA
				COUNTY	DESIGNED BY: S. BEALL			SHEET NO.
				SUSSEX	CHECKED BY: T. OLIVER			6


FOR INFORMATION ONLY
EARTHWORK SUMMARY

	SHT:1	SHT:2	SHT:3	SHT:4	SHT:5	SHT:6	SHT: 7	SHT: 8	
	NMBP 1039+00	Bridge 3-595	Bridge 3-596	Bridge 3-597	Gravel Hill	SR24	Hollyville Rd	Fox Run Rd	PROJECT
	TO	TO	TO	TO	Road				TOTALS
	Bridge 3-595	Bridge 3-596	Bridge 3-597	End	Connector				
EXCAVATION - ITEM 202000 (CY) [NEED = '-' / EXCESS = '+']									
EX01 : FROM CROSS SECTIONS / MODELS (+)	1,729	272	925	21,724	4,515	4,427	17,071	17,997	68,660
EX02 : BITUMINOUS PAVEMENT REMOVED IN FILL SECTIONS (+)	106	0	0	94	0	25	2	7	234
EX03 : TOPSOIL REMOVED UNDER FILL SECTIONS (+)	2,824	0	0	16,719	4,234	351	715	223	25,066
EX04 : TOPSOIL PLACED IN CUT SECTIONS (+) (Template includes topsoil depth)	0	0	0	0	0	0	0	0	0
EX05 : ROOT MAT REMOVED IN CUT SECTIONS (-) (Excluded from Inroads Normal Cut Qty)	0	0	0	0	0	0	0	0	0
EX06 : CURB AND/OR CURB AND GUTTER EXCAVATION (-) (Excluded from Inroads Normal Cut Qty)	0	0	0	0	0	0	0	0	0
EX07 : UNDERDRAIN EXCAVATION (-)	0	0	0	0	0	0	0	0	0
EX08 : ROCK EXCAVATION (-)	0	0	0	0	0	0	0	0	0
EX09 : REMOVAL OF PCC PAVEMENT, CURBS, SIDEWALK, ETC. (-)	0	0	0	0	0	0	0	0	0
EXTOTAL : TOTAL EXCAVATION	4,659	272	925	38,537	8,749	4,803	17,788	18,227	93,960
STORMWATER MANAGEMENT POND EXCAVATION - ITEM 271000 (CY) [NEED = '-' / EXCESS = '+']									
SWEX01 : FROM CROSS SECTIONS / MODELS (+)	1,985	0	0	24,671	0	0	0	0	26,656
SWEX02 : TOPSOIL REMOVED UNDER FILL SECTIONS (+)	0	0	0	0	0	0	0	0	0
SWEX03 : TOPSOIL PLACED IN CUT SECTIONS (+)	0	0	0	0	0	0	0	0	0
SWEX04 : ROOT MAT REMOVED (-)	0	0	0	0	0	0	0	0	0
SWEX05 : ROCK EXCAVATION (-)	0	0	0	0	0	0	0	0	0
SWEXTOTAL : TOTAL STORMWATER MANAGEMENT POND EXCAVATION	1,985	0	0	24,671	0	0	0	0	26,656
EXCAVATION AVAILABLE FOR EMBANKMENT (CY) [NEED = '-' / EXCESS = '+']									
EXTOTAL : TOTAL EXCAVATION (+) [ITEM 202000]	4,659	272	925	38,537	8,749	4,803	17,788	18,227	93,960
SWEXTOTAL : TOTAL STORMWATER MANAGEMENT POND EXCAVATION (+) [ITEM 910008]	1,261	0	0	24,671	0	0	0	0	25,932
AVEX01 : EXCAVATION AND BACKFILLING FOR STRUCTURES (+) [ITEM 207000]	0	0	0	0	0	0	0	0	0
AVEX02 : EXCAVATION FOR PIPE TRENCHES (+) [Item 601XXX]	0	0	0	0	0	0	0	0	0
AVEX03 : CHANNEL EXCAVATION (+) [ITEM 203000]	0	0	0	0	0	0	0	0	0
AVEX04 : POLE BASES EXCAVATION (+) [ITEM 834XXX]	0	0	0	0	0	0	0	0	0
AVEX05 : EXCAVATION FROM CURBS AND/OR CURB AND GUTTER (+)	0	0	0	0	0	0	0	0	0
AVEX06 : EXCAVATION FROM UNDERDRAINS (+) [ITEM 70900X]	0	0	0	0	0	0	0	0	0
AVEX07 : MISCELLANEOUS EXCAVATIONS (+)	0	0	0	0	0	0	0	0	0
AVEX08 : TOPSOIL REMOVED IN CUT AND/OR FILL SECTIONS (-)	3,965	0	0	30,419	8,144	1,286	7,338	5,899	57,051
AVEX09 : TOPSOIL REMOVED IN CUT AND/OR FILL SECTIONS FOR STORMWATER MANAGEMENT PONDS (-)	0	0	0	0	0	0	0	0	0
AVEX10: UNSUITABLE MATERIALS (-) (BITUMINOUS PAVT REMOVED IN CUT AND FILL)	145	0	0	1,695	0	669	4,673	944	8,126
AVEXTOTAL : TOTAL EXCAVATION AVAILABLE FOR EMBANKMENT	1,810	272	925	31,094	605	2,848	5,777	11,384	54,715
EMBANKMENT AND BORROW, TYPE 'F' REQUIRED (CY) [NEED = '-' / EXCESS = '+']									
EMRF01 : FROM CROSS SECTIONS / MODEL (+) [EMBANKMENT REQUIRED BELOW SUBGRADE OR CAPPING]	43,736	54,515	3,849	72,540	1,767	393	47	364	177,211
EMRF02 : TOPSOIL REMOVED UNDER FILL (+)	2,824	0	0	16,719	4,234	351	715	223	25,066
EMRF03 : ROOT MAT REMOVED UNDER FILL (+)	378	4,324	3,856	0	0	0	0	1,379	9,937
EMRF04 : UNSUITABLE MATERIAL REMOVED UNDER FILL (+)	0	0	0	0	0	0	0	0	0
EMRF05 : PCC REMOVED UNDER FILL (+)	0	0	0	0	0	0	0	0	0
EMRF06 : BITUMINOUS PAVEMENT REMOVED UNDER FILL (+)	106	0	0	94	0	25	2	7	234
EMRF07 : TOPSOIL TO BE PLACED IN FILL (+) (Inclcd in template)	0	0	0	0	0	0	0	0	0
EMRF08 : SUBTOTAL OF EMBANKMENT AND BORROW, TYPE 'F' REQUIRED	47,044	58,839	7,705	89,353	6,001	769	764	1,973	212,448
EMRF09 : COMPACTION FACTOR APPLIED TO THE SUBTOTAL (%)	1.2	1.2	1.2	1.2	1.2	1.2	1.2	1.2	
EMRFTOTAL : TOTAL EMBANKMENT AND BORROW, TYPE 'F' REQUIRED	56,453	70,607	9,246	107,224	7,201	923	917	2,368	254,938
TOPSOIL SUMMARY (CY) [NEED = '-' / EXCESS = '+']									
TOP01 : TOPSOIL SALVAGED FROM CUT SECTIONS (+)	1,140	0	0	13,701	3,910	936	6,413	5,825	31,925
TOP02 : TOPSOIL SALVAGED FROM FILL SECTIONS (+)	2,824	0	0	16,719	4,234	351	715	223	25,066
TOP03 : TOPSOIL SALVAGED FROM STORMWATER MANAGEMENT PONDS (+)	1,261	0	0	7,775	0	0	0	0	9,036
TOP04 : TOPSOIL REQUIRED (-) (calculate from plan view area)	0	0	0	0	0	0	0	0	0
TOPTOTAL : TOTAL TOPSOIL	5,225	0	0	38,195	8,144	1,287	7,128	6,048	66,027
MATERIAL BALANCE (CY) [NEED = '-' / EXCESS = '+']									
BORROW, TYPE 'A' (built into template: 12' depth under roadway pavement)	-1,485	-1,482	-1,519	-9,711	-2,728	-1,883	-2,264	-3,389	-24,461
BORROW, TYPE 'B'	0	0	0	0	0	0	0	0	0
BORROW, TYPE 'C'	0	0	0	0	0	0	0	0	0
BORROW, TYPE 'F'	-54,643	-70,335	-8,321	-76,130	-6,596	1,925	4,860	9,016	-200,223
TOPSOIL	0	0	0	0	0	0	0	0	0
UNSUITABLE MATERIAL (AVEX10)	145	0	0	1,695	0	669	4,673	944	8,126
Notes:									
1. Topsoil under embankment height >5' is not stripped.									
2. Root Mat under embankment height >5' remains in place. Excavation and removal of root mat is paid under Clearing and Grubbing. Refill for removal in fill sections is included in EMRF03.									
3. Fox Run Driveway Excav = 9591 SF x 0.83' = 7961 CF = 295 CY, TS in Cut = 252 CY, HM in Cut = 103 CY (Added to Fox RunRd Column)									
4. Washington St Ext Excav = 2094' x 11' x 0.83' = 19,195 CF = 711 CY, TS in Cut = 186 CY (Added to Hollyville Column)									
5. Removal of existing Fox Run Rd outside of template = 8916 SF x 1' Depth = 330 CY, HM in Cut = 330 CY (Added to Fox RunRd Column)									
6. Removal of existing SR24 and Hollyville Road outside of template = 121,161 SF x 1' Depth = 4487 CY, HM in Cut = 4277 CY, TS in Cut = 210 CY (Added to Hollyville Column)									


ADDENDA / REVISIONS		NOT TO SCALE	CM/GC, NORTH MILLSBORO BYPASS, US 113 TO SR 24	CONTRACT	BRIDGE NO.	N/A	NOTES	SECTION
				T202112701				WRA
				COUNTY	DESIGNED BY: S. BEALL			SHEET NO.
				SUSSEX	CHECKED BY: T. OLIVER			7

3/4/2022
6:13:12 PM
N:\132149-002\CADD\US 113 NM Bypass\T501_NMBP.dgn


STATION 1047+73 TO STATION 1053+65
STATION 1061+43 TO STATION 1072+17
STATION 1079+66 TO STATION 1092+03

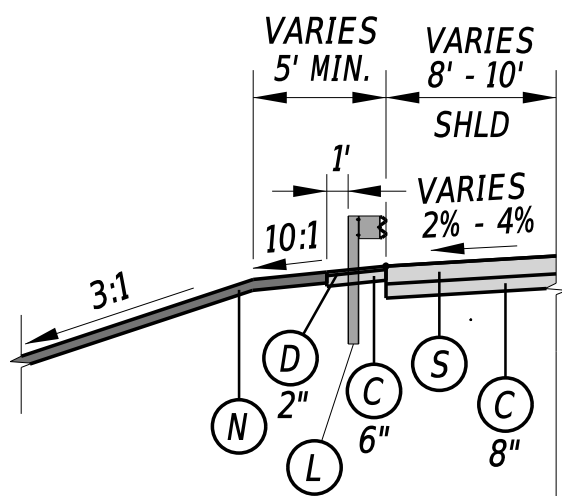

NORTH MILLSBORO BYPASS
CONSTRUCTION
AND R/W BASELINE

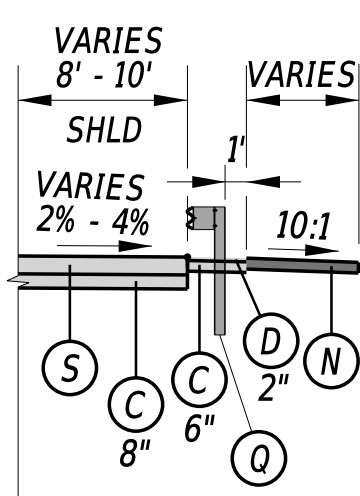

STATION 1047+10 TO STATION 1053+00
STATION 1060+62 TO STATION 1071+35
STATION 1078+85 TO STATION 1091+21

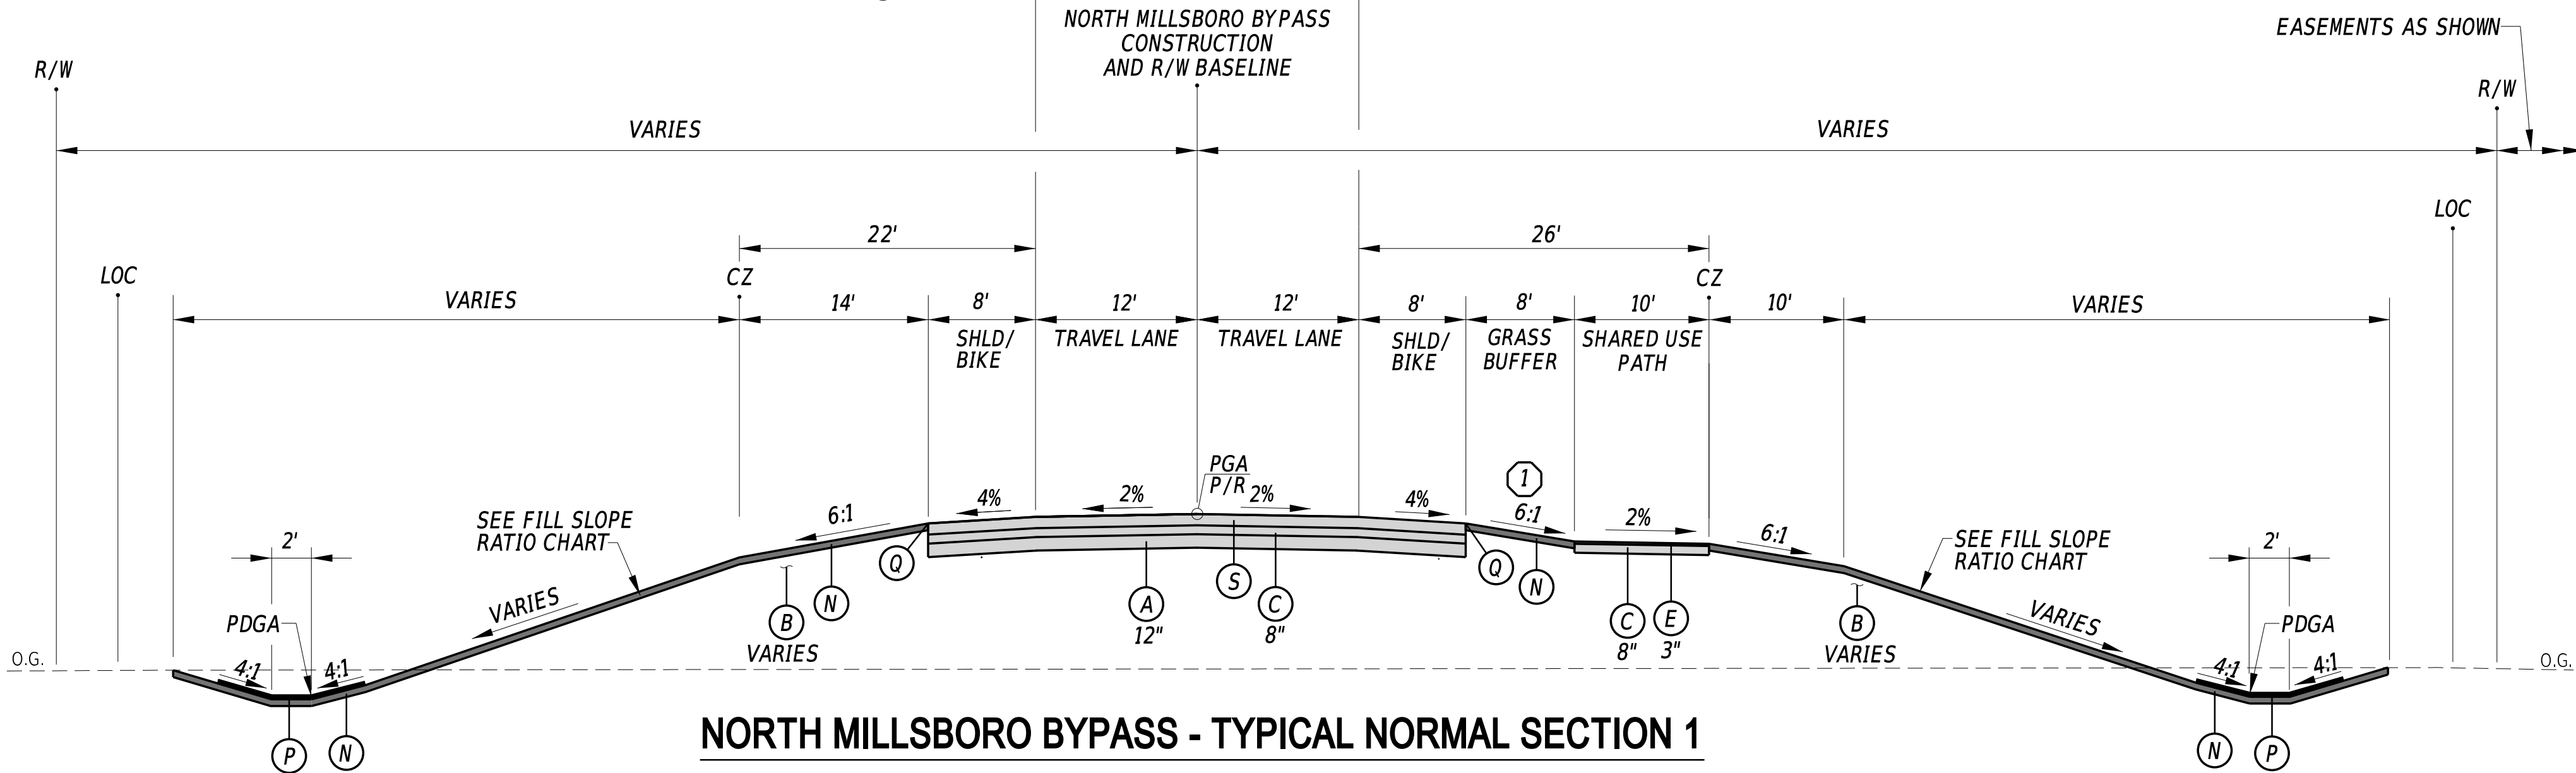

NORTH MILLSBORO BYPASS - TYPICAL NORMAL SECTION 1

STATION 1045+45 TO STATION 1052+61 (INCLUDES BR 3-595)
STATION 1059+61 TO STATION 1091+29 (INCLUDES BR 3-596 AND BR 3-597)

① GRASS BUFFER SLOPE IS 25:1 FROM:
STATION 1073+50 TO STATION 1077+50

LEGEND

- (A) ITEM 209001 - BORROW, TYPE A
- (B) ITEM 209006 - BORROW, TYPE F
- (C) ITEM 301001 - GABC
- (D) ITEM 401014 - SUPERPAVE TYPE B, PG 64-22
- (E) ITEM 401005 - SUPERPAVE TYPE C, PG 64-22 (CARBONATE STONE)
- (L) ITEM 720021 - GALVANIZED STEEL BEAM GUARDRAIL, TYPE 1-31
- (N) ITEM 908004 - TOPSOIL, 6" DEPTH OR ITEM 908010 - TOPSOILING, 6" DEPTH
ITEM 908014 - PERMANENT GRASS SEEDING, DRY GROUND
- (P) ITEM 908020 - EROSION CONTROL BLANKET MULCH (8' ROLL WIDTH, MIN.)
- (Q) SAFETY EDGE (INCIDENTAL TO RESPECTIVE SUPERPAVE ITEMS)
- (R) ITEM 501001 - PORTLAND CEMENT CONCRETE PAVEMENT, 8"
- (S) ITEM 501004 - PORTLAND CEMENT CONCRETE PAVEMENT, 10"


MATERIAL	LIFT THICKNESS	
	MINIMUM	MAXIMUM
GRADED AGGREGATE BASE COURSE	4"	8"

NOTES:

- PGA - POINT OF GRADE APPLICATION
PDGA - POINT OF DITCH GRADE APPLICATION
P/R - POINT OF ROTATION
- THE PGA IS APPLIED TO THE TOP OF THE FINAL PAVEMENT SURFACE. IN AREAS WHERE THE PGA IS LOCATED WITHIN THE RAISED MEDIAN, ITS VERTICAL LOCATION SHALL BE THE TOP OF ADJACENT PAVEMENT ELEVATION PROJECTED AT THE PROPOSED CROSS SLOPE TO THE CONSTRUCTION BASELINE.
- EROSION CONTROL BLANKET IS REQUIRED ON ALL EMBANKMENT SLOPES STEEPER THAN 3:1.
- MAXIMUM ALGEBRAIC DIFFERENCE OF CROSS SLOPES SHALL NOT EXCEED 8%.

FILL SLOPE RATIO CHART

HEIGHT OF EMBANKMENT	SLOPE RATIO
0' TO 5'	6:1
5' TO 10'	4:1
>10'	3:1

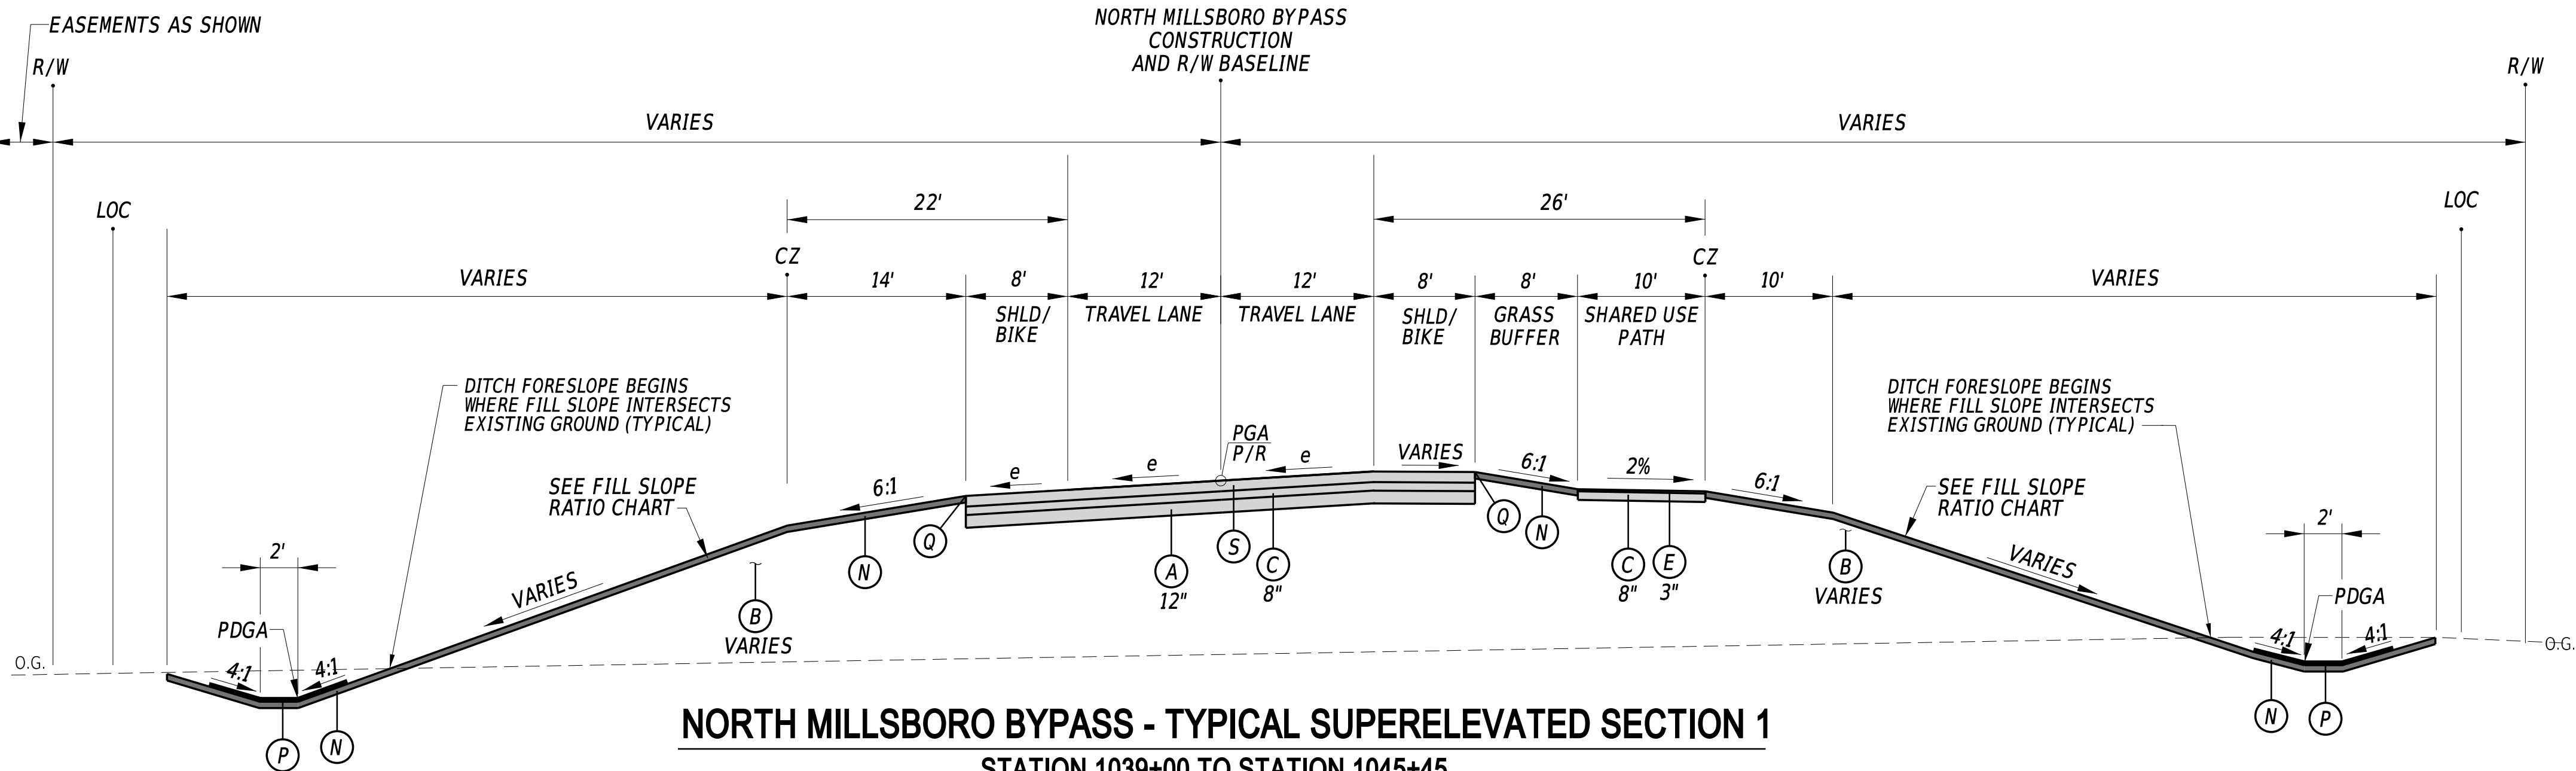

NORTH MILLSBORO BYPASS - TYPICAL SUPERELEVATED SECTION 1

STATION 1039+00 TO STATION 1045+45
STATION 1052+61 TO STATION 1059+61

ADDENDA / REVISIONS

NOT TO SCALE


CM/GC,
NORTH MILLSBORO BYPASS,
US 113 TO SR 24

CONTRACT	BRIDGE NO.	N/A
T202112701	DESIGNED BY:	S. BEALL
COUNTY	CHECKED BY:	T. OLIVER
SUSSEX		

TYPICAL SECTIONS

SECTION
WRA
SHEET NO.
8


3/4/2022
10:58:17 PM
N:\132149-002\CADD\113 NM Bypass\T502_NMBP.dgn

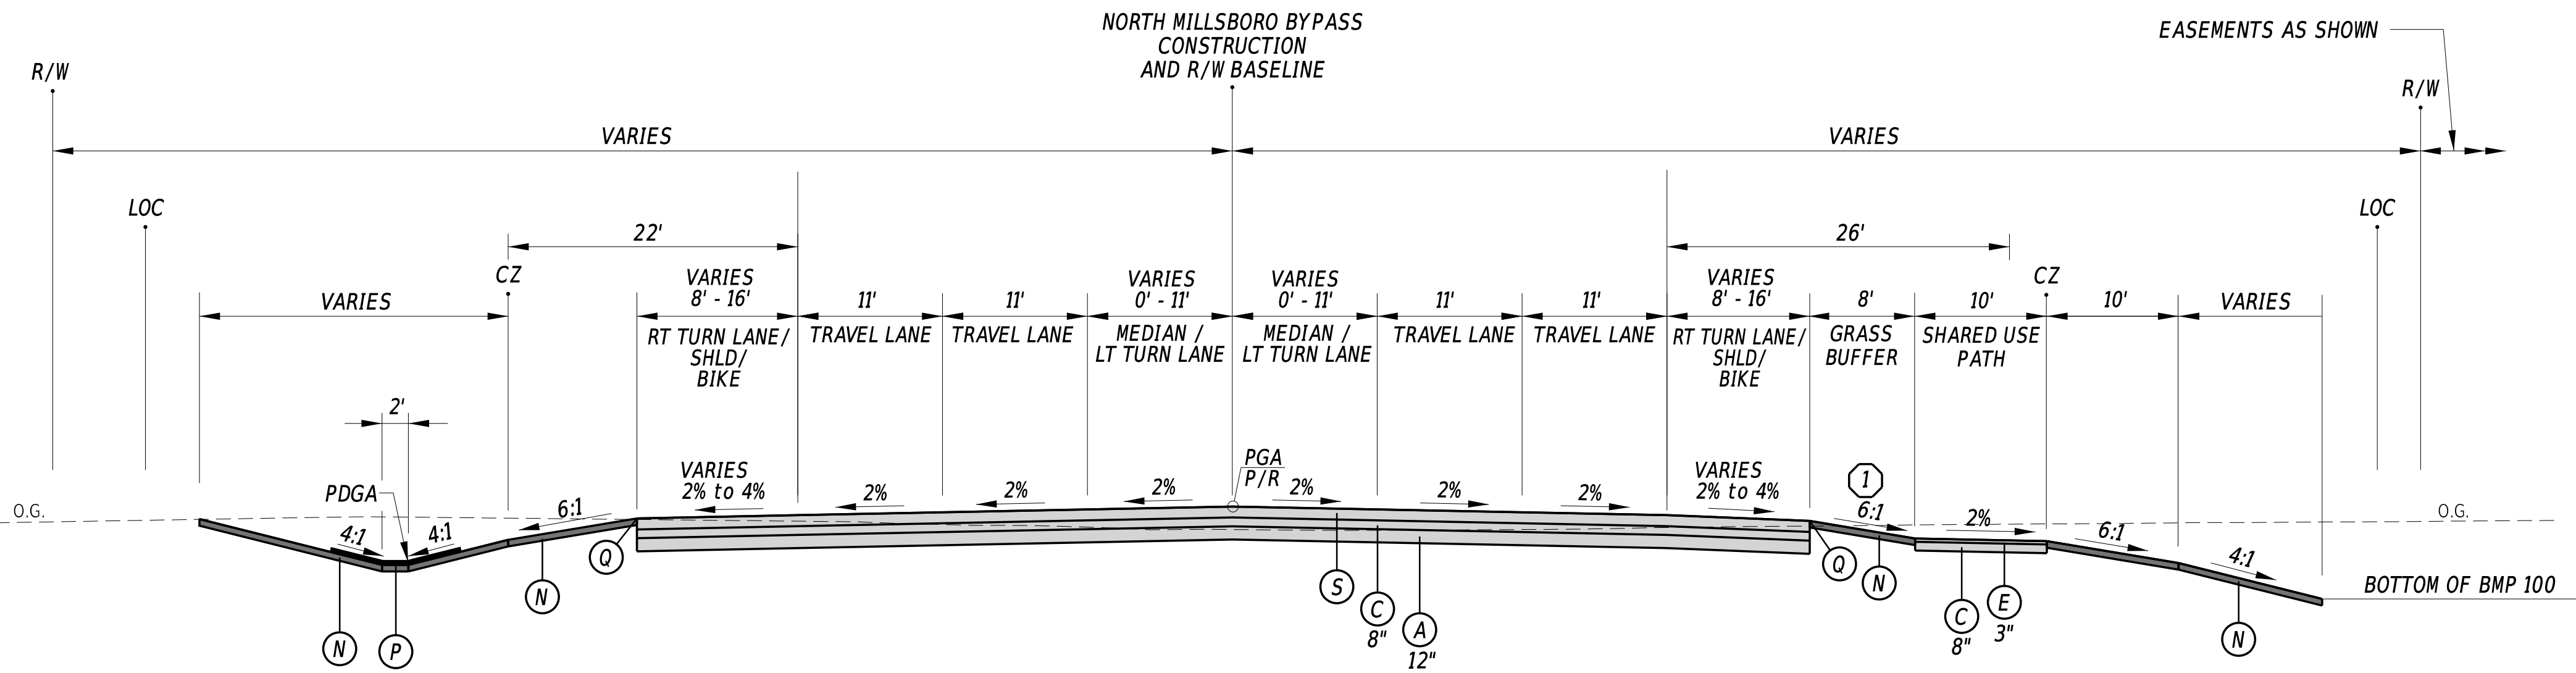

NORTH MILLSBORO BYPASS - TYPICAL NORMAL SECTION 2

STATION 1121+93 TO STATION 1134+38
STATION 1143+97 TO STATION 1147+60

① GRASS BUFFER SLOPE IS 25:1 FROM:
STATION 1123+50 TO STATION 1127+50
STATION 1143+97 TO STATION 1147+60

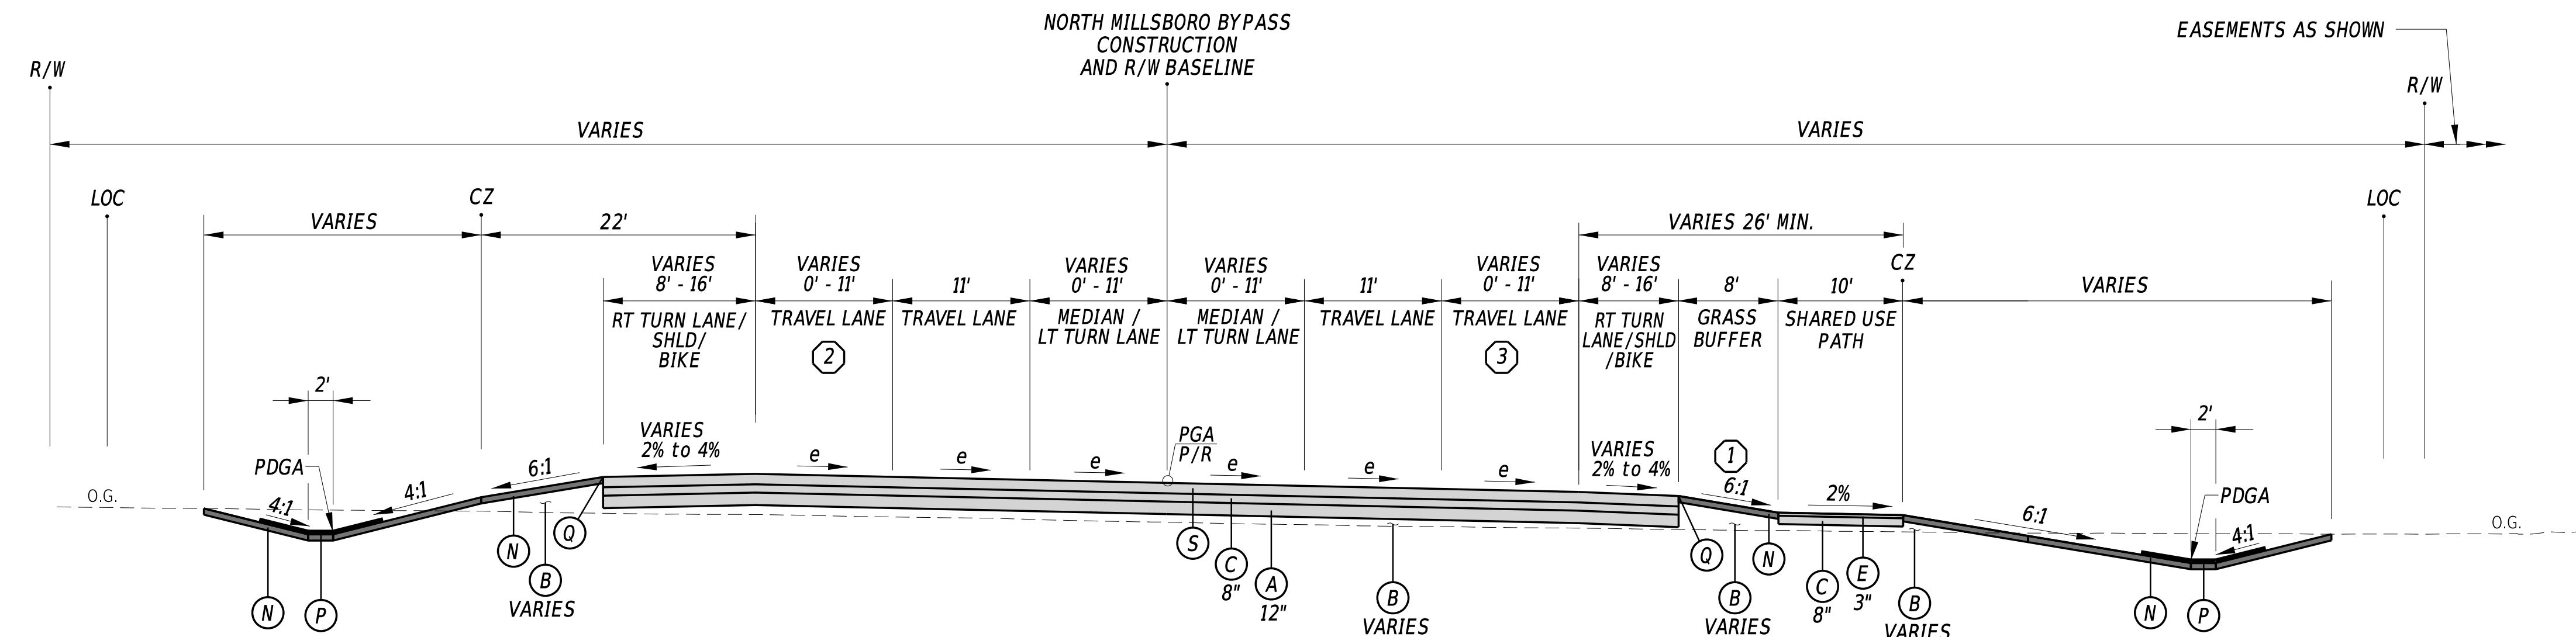

NORTH MILLSBORO BYPASS - TYPICAL SUPERELEVATED SECTION 2

STATION 1091+29 TO STATION 1121+93
STATION 1134+38 TO STATION 1143+97

① GRASS BUFFER SLOPE IS 25:1 FROM:
STATION 1143+00 TO STATION 1143+97
② SECOND WESTBOUND LANE FROM STATION 1108+00 TO STATION 1136+00
③ SECOND EASTBOUND LANE FROM STATION 1109+00 TO STATION 1121+93

LEGEND

- (A) ITEM 209001 - BORROW, TYPE A
- (B) ITEM 209006 - BORROW, TYPE F
- (C) ITEM 301001 - GABC
- (D) ITEM 401014 - SUPERPAVE TYPE B, PG 64-22
- (E) ITEM 401005 - SUPERPAVE TYPE C, PG 64-22 (CARBONATE STONE)
- (L) ITEM 720021 - GALVANIZED STEEL BEAM GUARDRAIL, TYPE 1-31
- (N) ITEM 908004 - TOPSOIL, 6" DEPTH OR ITEM 908010 - TOPSOILING, 6" DEPTH
ITEM 908014 - PERMANENT GRASS SEEDING, DRY GROUND
- (P) ITEM 908020 - EROSION CONTROL BLANKET MULCH (8' ROLL WIDTH, MIN.)
- (Q) SAFETY EDGE (INCIDENTAL TO RESPECTIVE SUPERPAVE ITEMS)
- (R) ITEM 501001 - PORTLAND CEMENT CONCRETE PAVEMENT, 8"
- (S) ITEM 501004 - PORTLAND CEMENT CONCRETE PAVEMENT, 10"

MATERIAL	LIFT THICKNESS	
	MINIMUM	MAXIMUM
GRADED AGGREGATE BASE COURSE	4"	8"

NOTES:

- PGA - POINT OF GRADE APPLICATION
PDGA - POINT OF DITCH GRADE APPLICATION
P/R - POINT OF ROTATION
- THE PGA IS APPLIED TO THE TOP OF THE FINAL PAVEMENT SURFACE. IN AREAS WHERE THE PGA IS LOCATED WITHIN THE RAISED MEDIAN, ITS VERTICAL LOCATION SHALL BE THE TOP OF ADJACENT PAVEMENT ELEVATION PROJECTED AT THE PROPOSED CROSS SLOPE TO THE CONSTRUCTION BASELINE.
- EROSION CONTROL BLANKET IS REQUIRED ON ALL EMBANKMENT SLOPES STEEPER THAN 3:1.
- MAXIMUM ALGEBRAIC DIFFERENCE OF CROSS SLOPES SHALL NOT EXCEED 8%.

FILL SLOPE RATIO CHART	
HEIGHT OF EMBANKMENT	SLOPE RATIO
0' TO 5'	6:1
5' TO 10'	4:1
>10'	3:1

ADDENDA / REVISIONS

NOT TO SCALE

CM/GC,
NORTH MILLSBORO BYPASS,
US 113 TO SR 24

CONTRACT

T202112701

COUNTY

SUSSEX

BRIDGE NO.

N/A

DESIGNED BY: S. BEALL

CHECKED BY: T. OLIVER


TYPICAL SECTIONS

SECTION

WRA

SHEET NO.

9

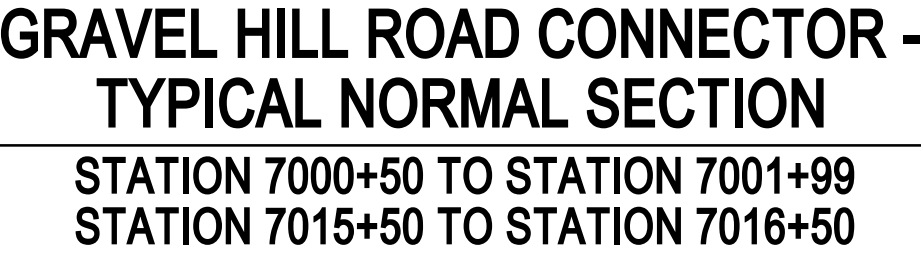


FILL SLOPE RATIO CHART	
HEIGHT OF EMBANKMENT	SLOPE RATIO
0' TO 5'	6:1
5' TO 10'	4:1
>10'	3:1

ADDENDA / REVISIONS		NOT TO SCALE	CM/GC, NORTH MILLSBORO BYPASS, US 113 TO SR 24	CONTRACT	BRIDGE NO.	N/A	TYPICAL SECTIONS	SECTION
				T202112701				WRA
				COUNTY	DESIGNED BY: S. BEALL			SHEET NO.
				SUSSEX	CHECKED BY: T. OLIVER			10

3/4/2022
6:13:15 PM
N:\32149-002\CADD\US 113 NM Bypass\TS03 NMBP.dgn

3/4/2022
10:19:12 PM
N:\132149-002\CADD\US 113 NM Bypass\T504_NMB.dgn

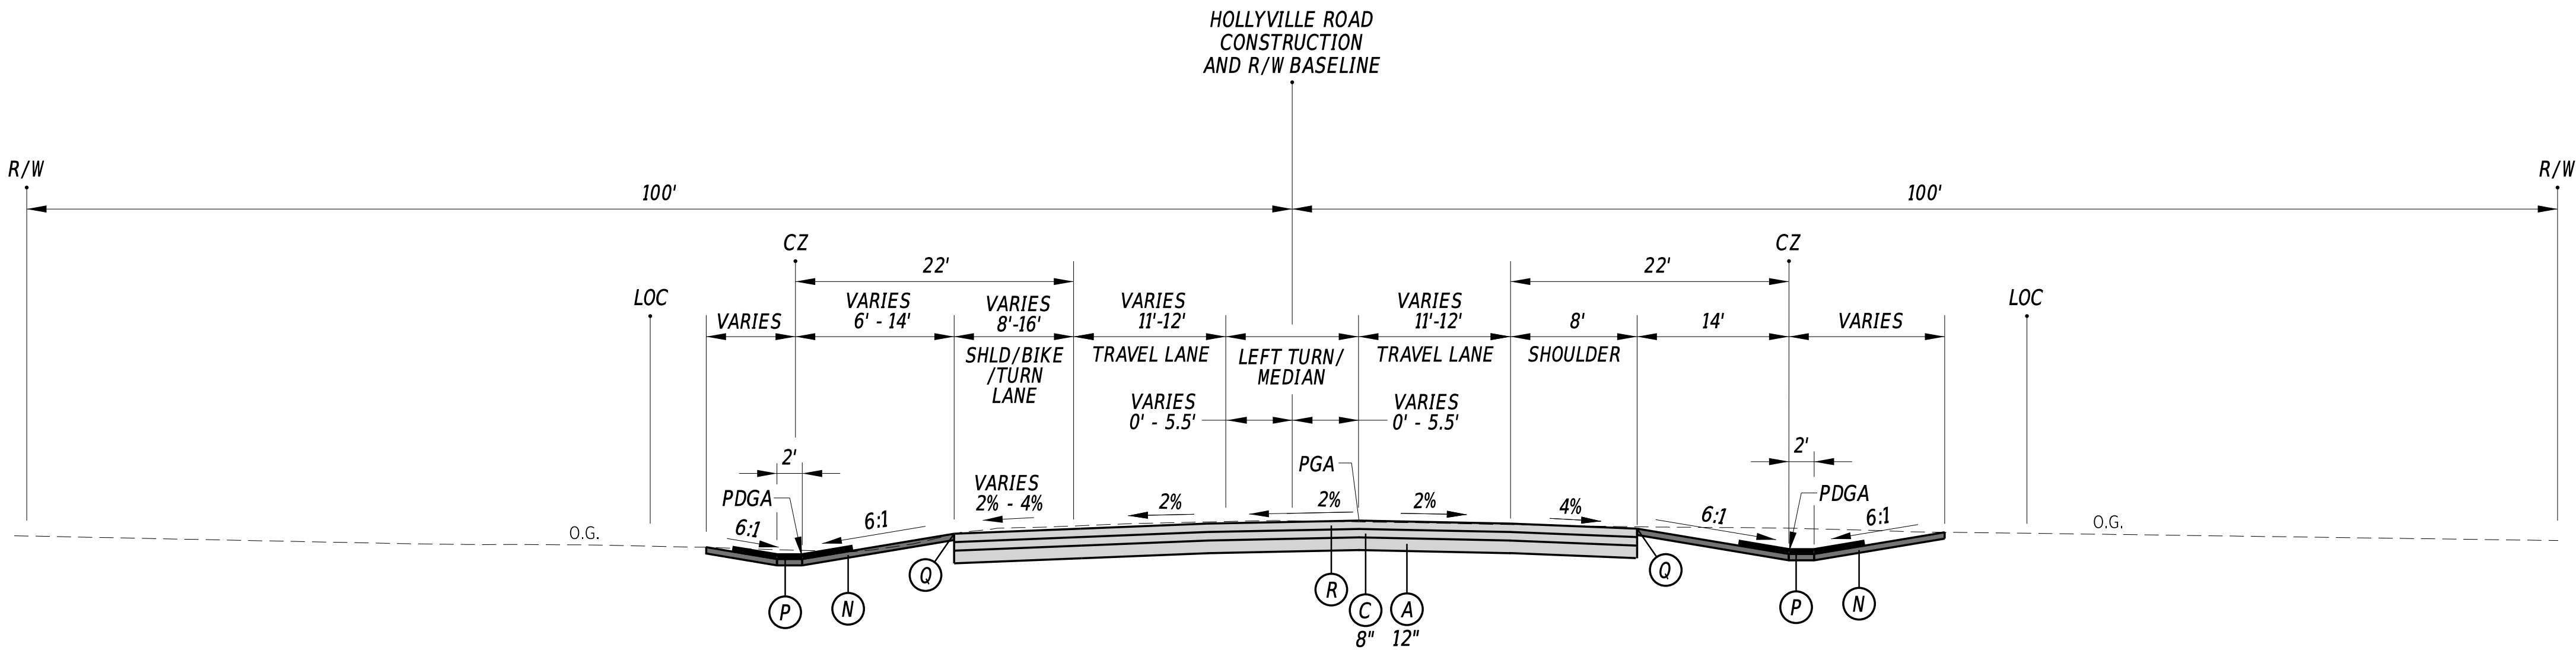

HOLLYVILLE ROAD TYPICAL SECTION
STATION 9013+05 TO STATION 9026+35


LEGEND

- (A) ITEM 209001 - BORROW, TYPE A
- (B) ITEM 209006 - BORROW, TYPE F
- (C) ITEM 301001 - GABC
- (D) ITEM 401014 - SUPERPAVE TYPE B, PG 64-22
- (E) ITEM 401005 - SUPERPAVE TYPE C, PG 64-22 (CARBONATE STONE)
- (L) ITEM 720021 - GALVANIZED STEEL BEAM GUARDRAIL, TYPE 1-31
- (N) ITEM 908004 - TOPSOIL, 6" DEPTH OR ITEM 908010 - TOPSOILING, 6" DEPTH
ITEM 908014 - PERMANENT GRASS SEEDING, DRY GROUND
- (P) ITEM 908020 - EROSION CONTROL BLANKET MULCH (8' ROLL WIDTH, MIN.)
- (Q) SAFETY EDGE (INCIDENTAL TO RESPECTIVE SUPERPAVE ITEMS)
- (R) ITEM 501001 - PORTLAND CEMENT CONCRETE PAVEMENT, 8"
- (S) ITEM 501004 - PORTLAND CEMENT CONCRETE PAVEMENT, 10"


MATERIAL	LIFT THICKNESS	
	MINIMUM	MAXIMUM
GRADED AGGREGATE BASE COURSE	4"	8"

- NOTES:**
- PGA - POINT OF GRADE APPLICATION
PDGA - POINT OF DITCH GRADE APPLICATION
P/R - POINT OF ROTATION
 - THE PGA IS APPLIED TO THE TOP OF THE FINAL PAVEMENT SURFACE. IN AREAS WHERE THE PGA IS LOCATED WITHIN THE RAISED MEDIAN, ITS VERTICAL LOCATION SHALL BE THE TOP OF ADJACENT PAVEMENT ELEVATION PROJECTED AT THE PROPOSED CROSS SLOPE TO THE CONSTRUCTION BASELINE.
 - EROSION CONTROL BLANKET IS REQUIRED ON ALL EMBANKMENT SLOPES STEEPER THAN 3:1.
 - MAXIMUM ALGEBRAIC DIFFERENCE OF CROSS SLOPES SHALL NOT EXCEED 8%.

FILL SLOPE RATIO CHART	
HEIGHT OF EMBANKMENT	SLOPE RATIO
0' TO 5'	6:1
5' TO 10'	4:1
>10'	3:1

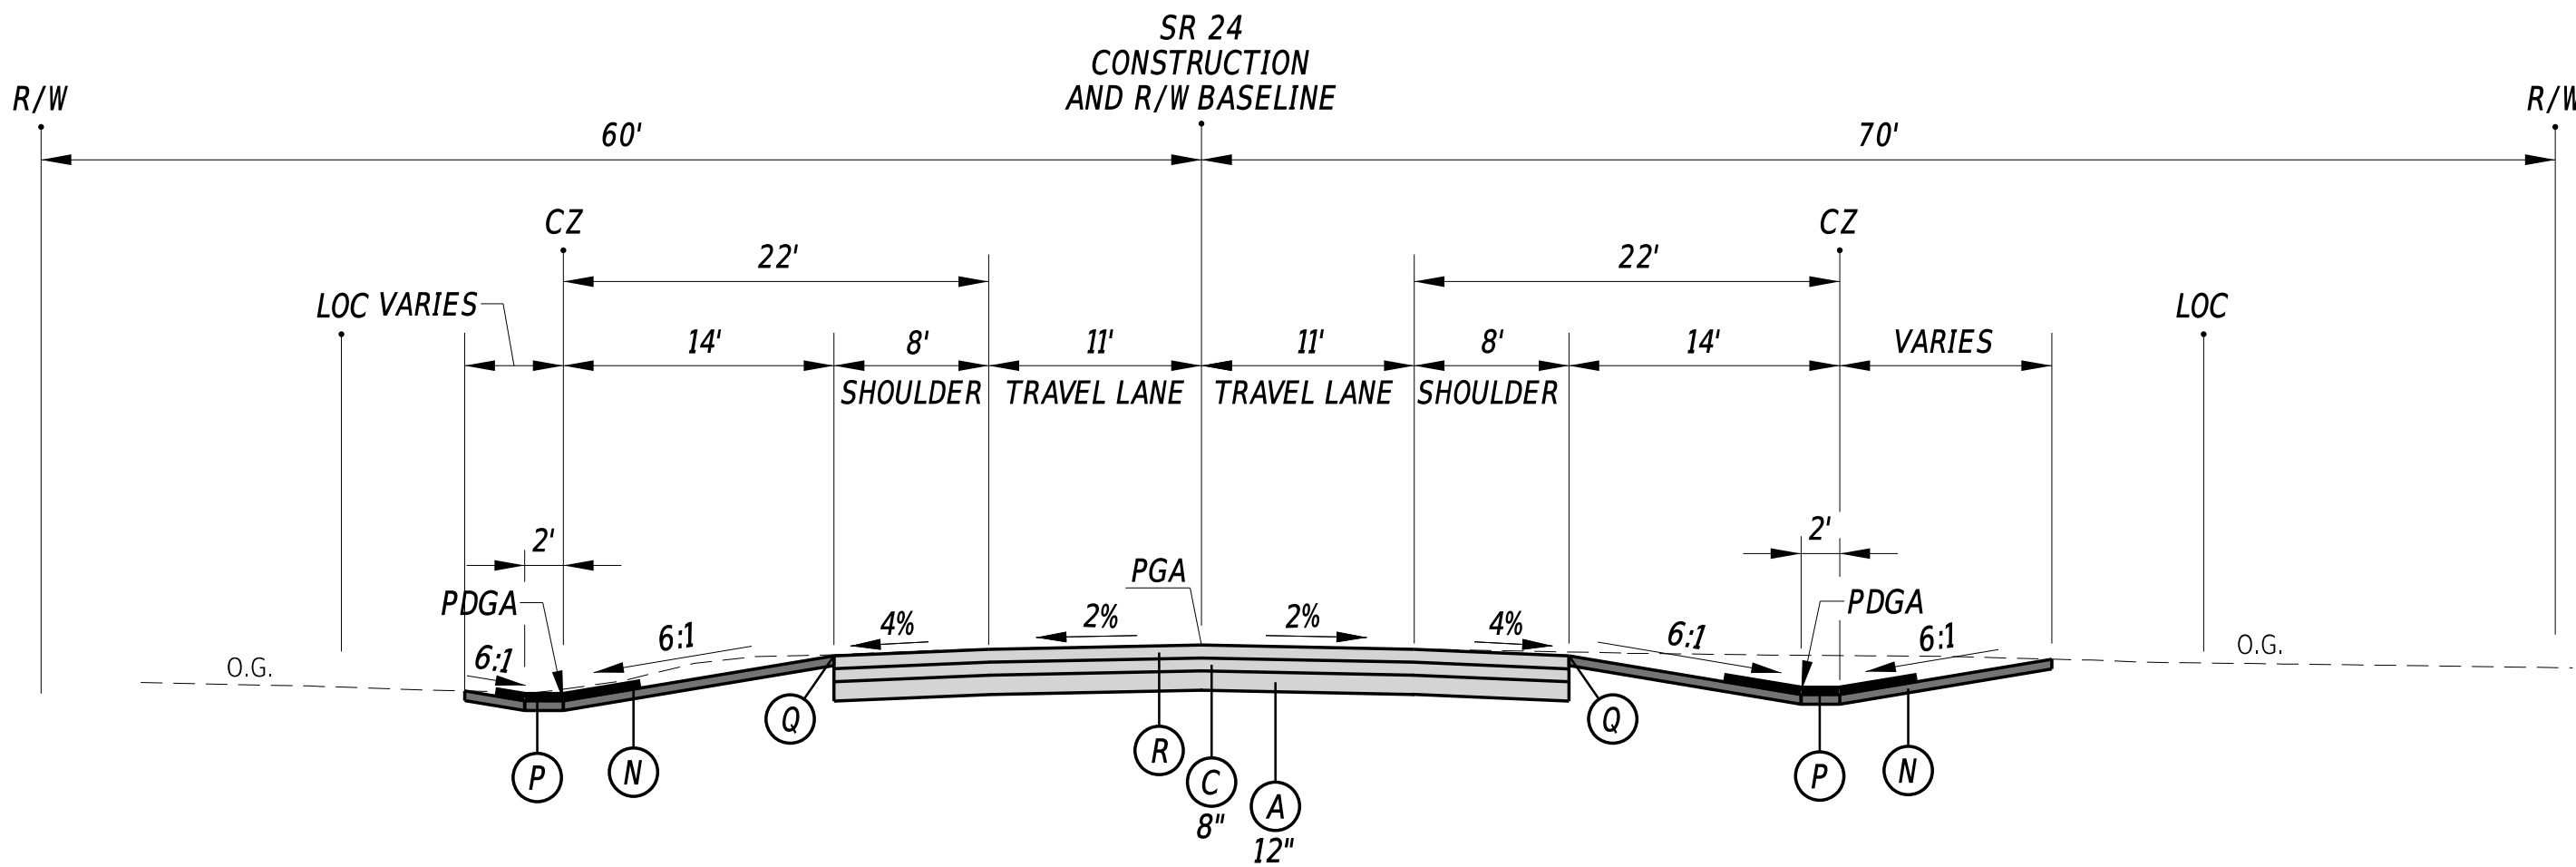

**SR 24 -
TYPICAL NORMAL SECTION**
STATION 9000+50 TO STATION 9002+75

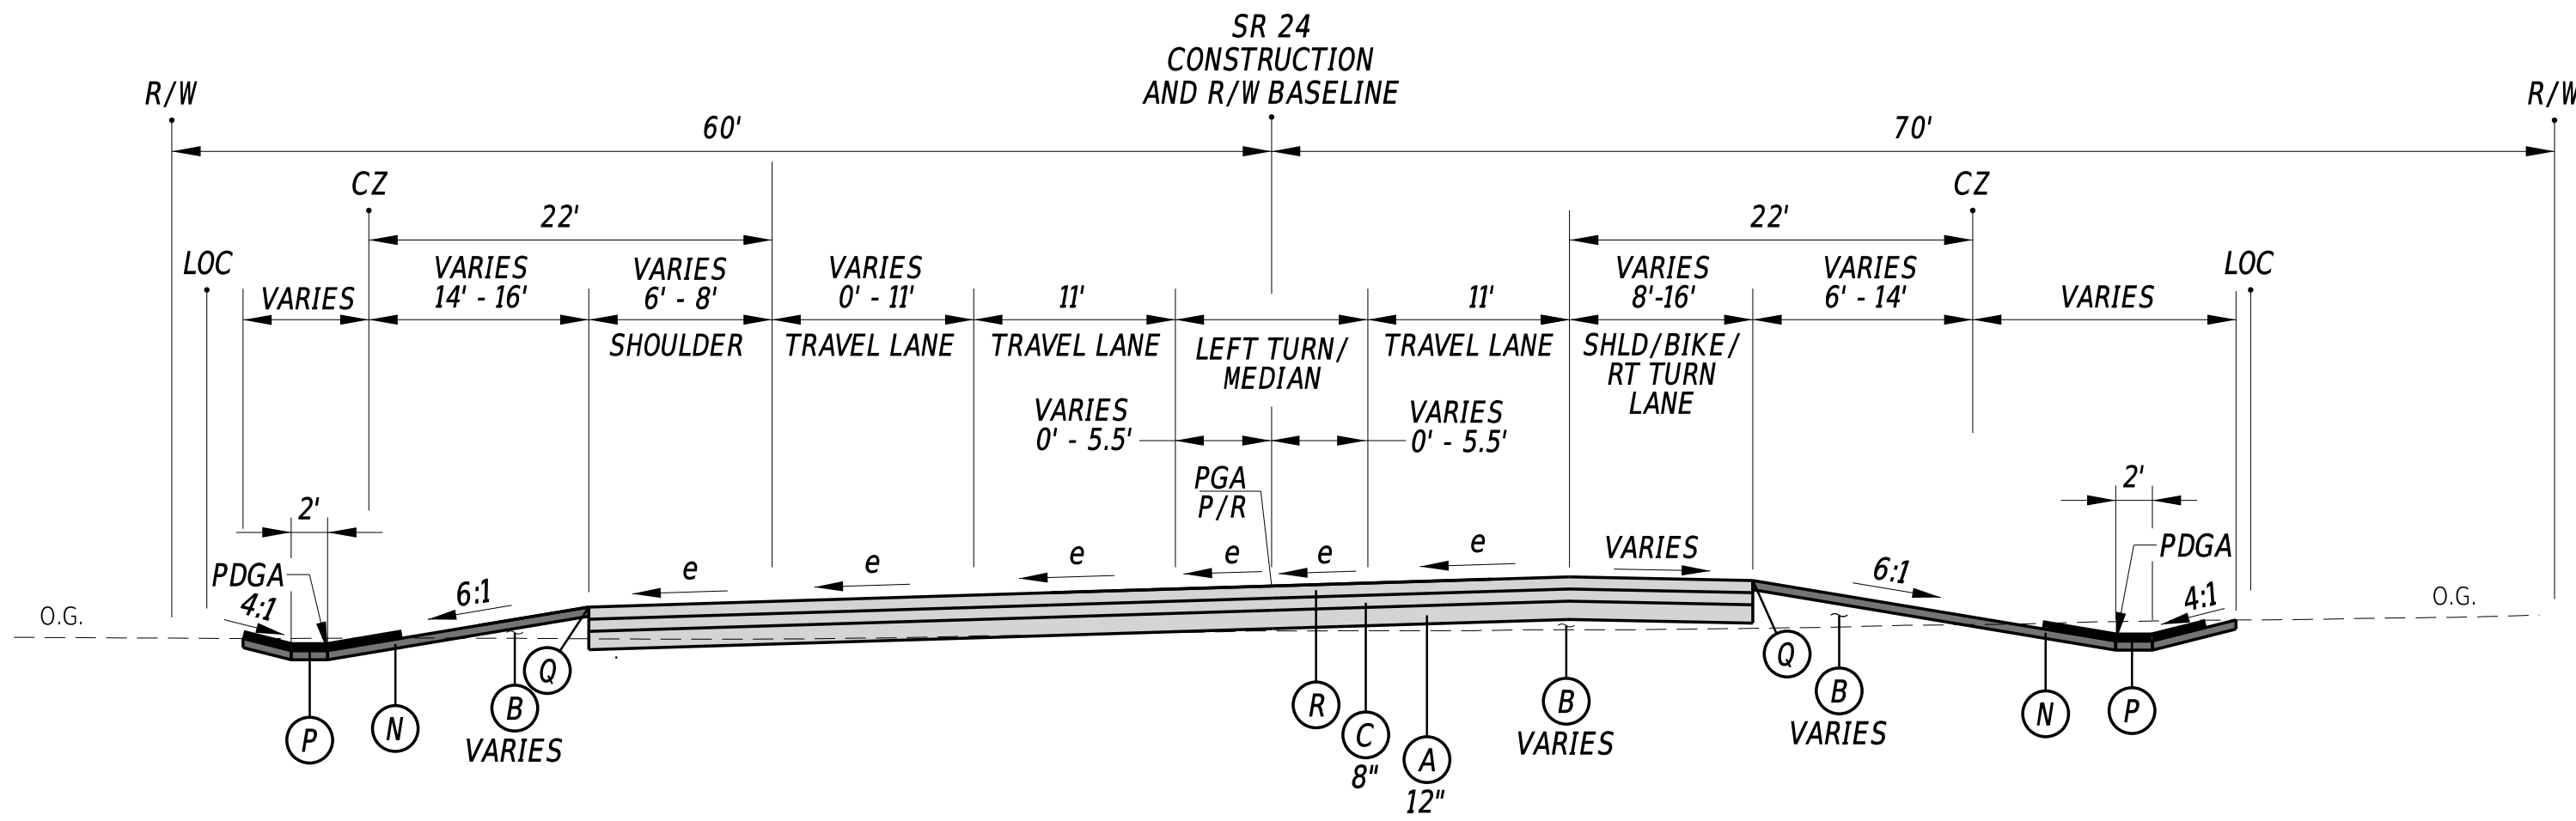

**SR 24 -
TYPICAL SUPERELEVATED SECTION**
STATION 9002+75 TO STATION 9011+78

ADDENDA / REVISIONS

NOT TO SCALE

**CM/GC,
NORTH MILLSBORO BYPASS,
US 113 TO SR 24**

CONTRACT

T202112701

COUNTY

SUSSEX

BRIDGE NO.

N/A

DESIGNED BY: S. BEALL

CHECKED BY: T. OLIVER

TYPICAL SECTIONS


SECTION

WRA


SHEET NO.

11


3/4/2022
6:13:17 PM
N:\322149-002\CADD\US 113 NM Bypass\T505_NMBP.dgn

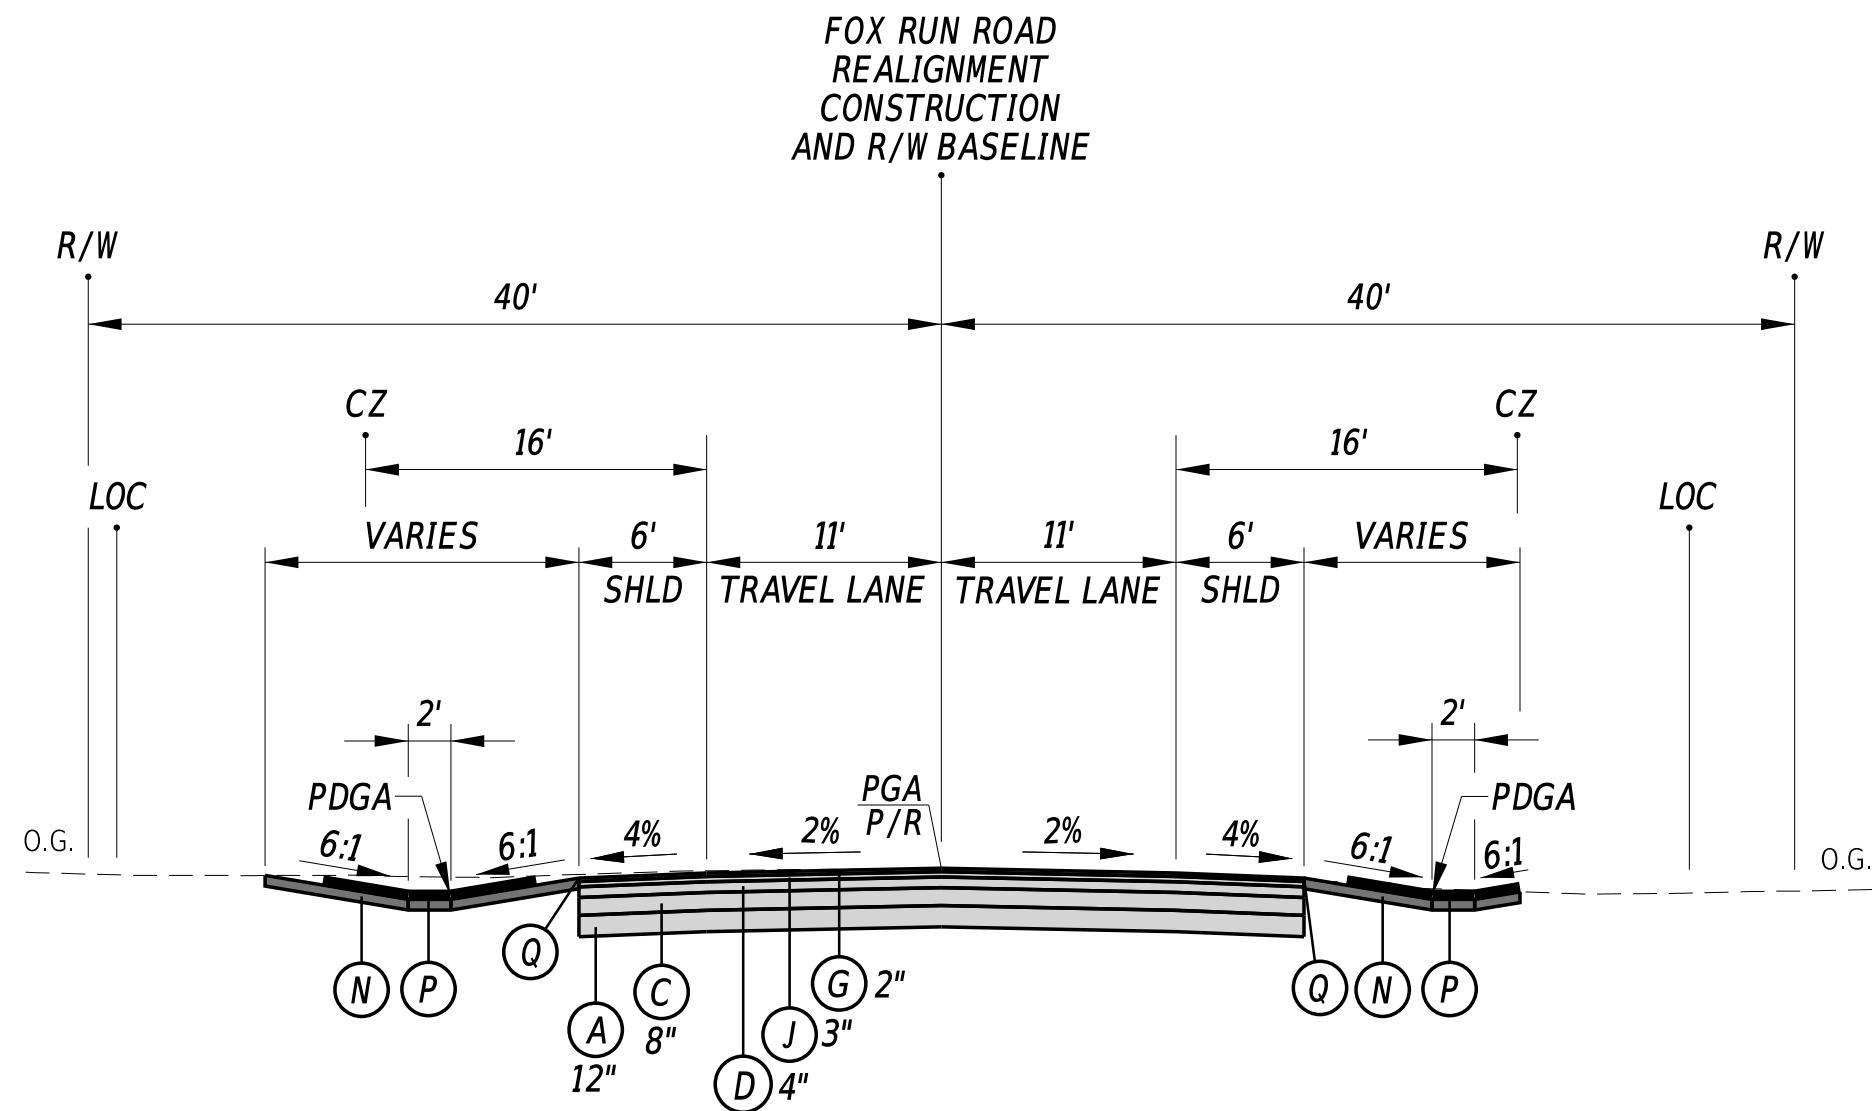

**FOX RUN ROAD REALIGNMENT -
TYPICAL NORMAL SECTION**
STATION 6100+00 TO STATION 6101+00
STATION 6106+00 TO STATION 6108+50
STATION 6113+50 TO STATION 6115+50

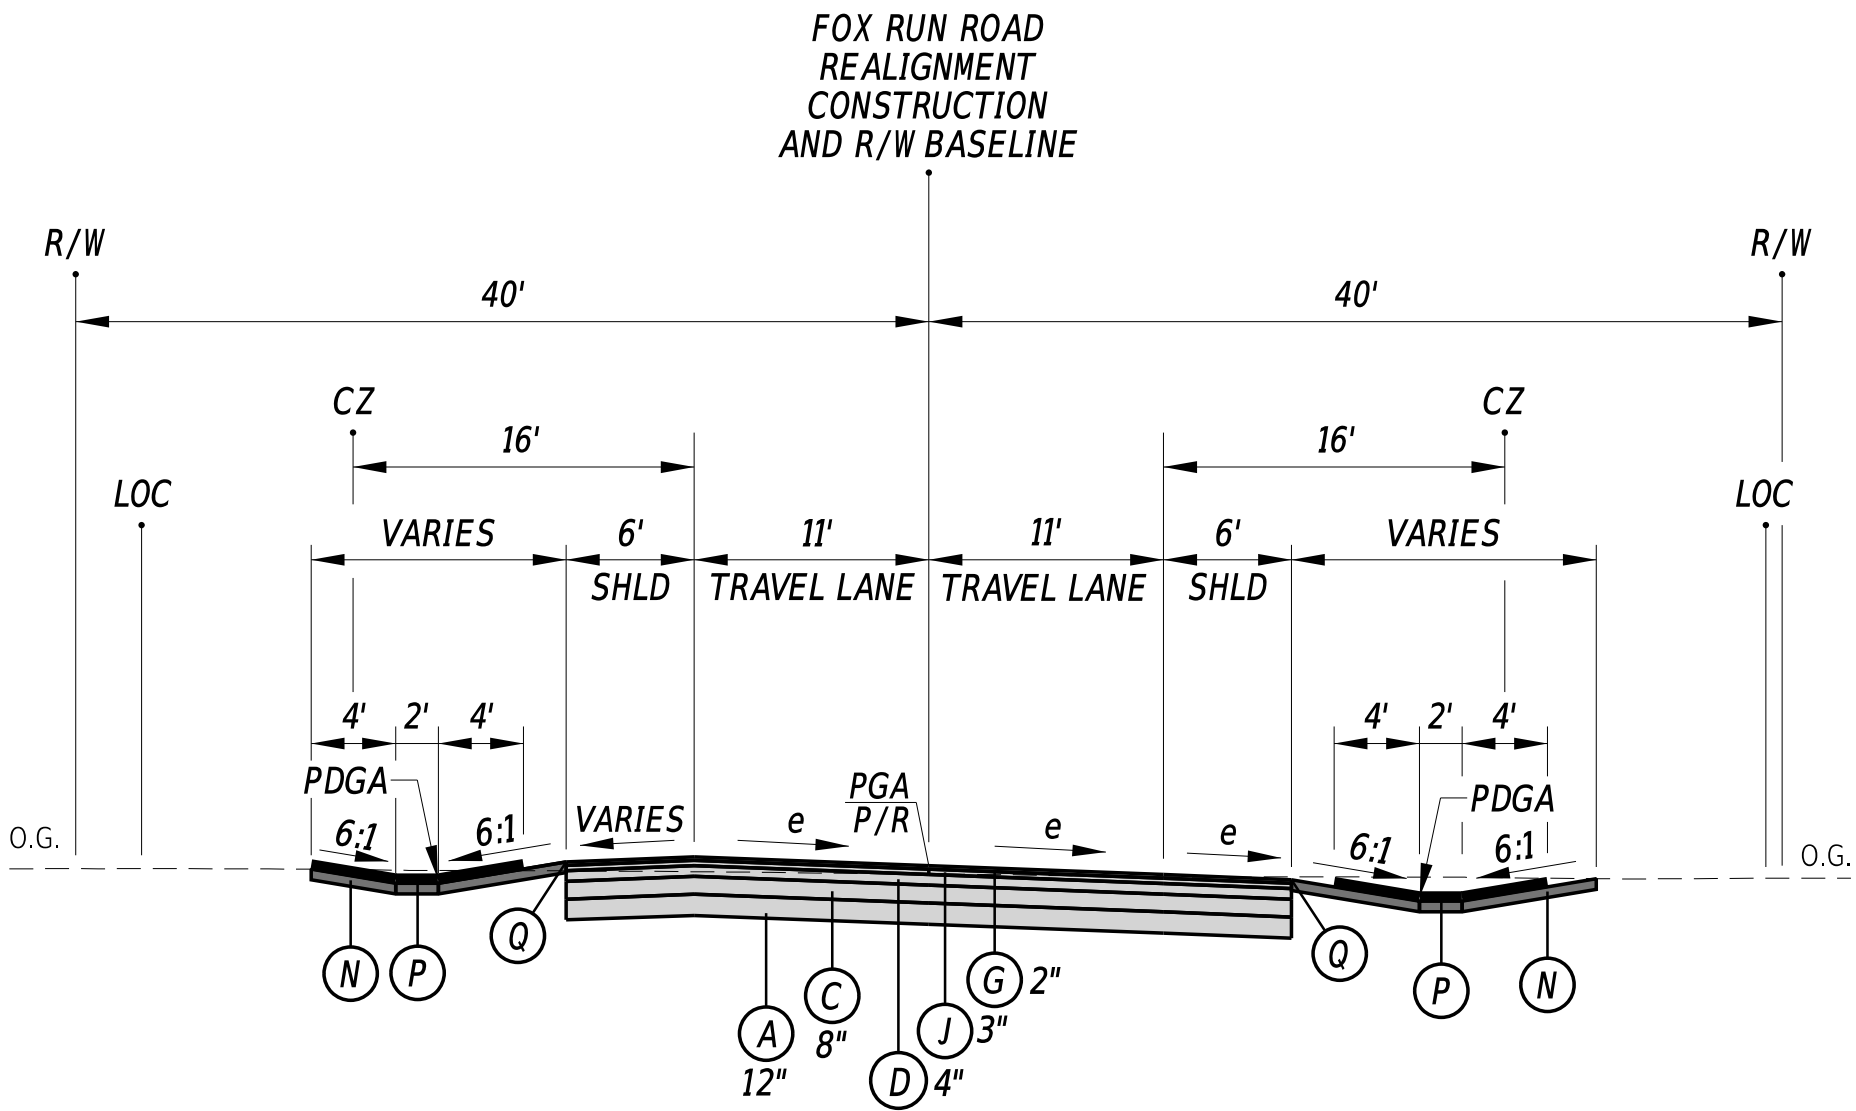

**FOX RUN ROAD REALIGNMENT -
TYPICAL SUPERELEVATED SECTION**
STATION 6101+00 TO STATION 6106+00
STATION 6108+50 TO STATION 6113+50
STATION 6115+50 TO STATION 6127+00

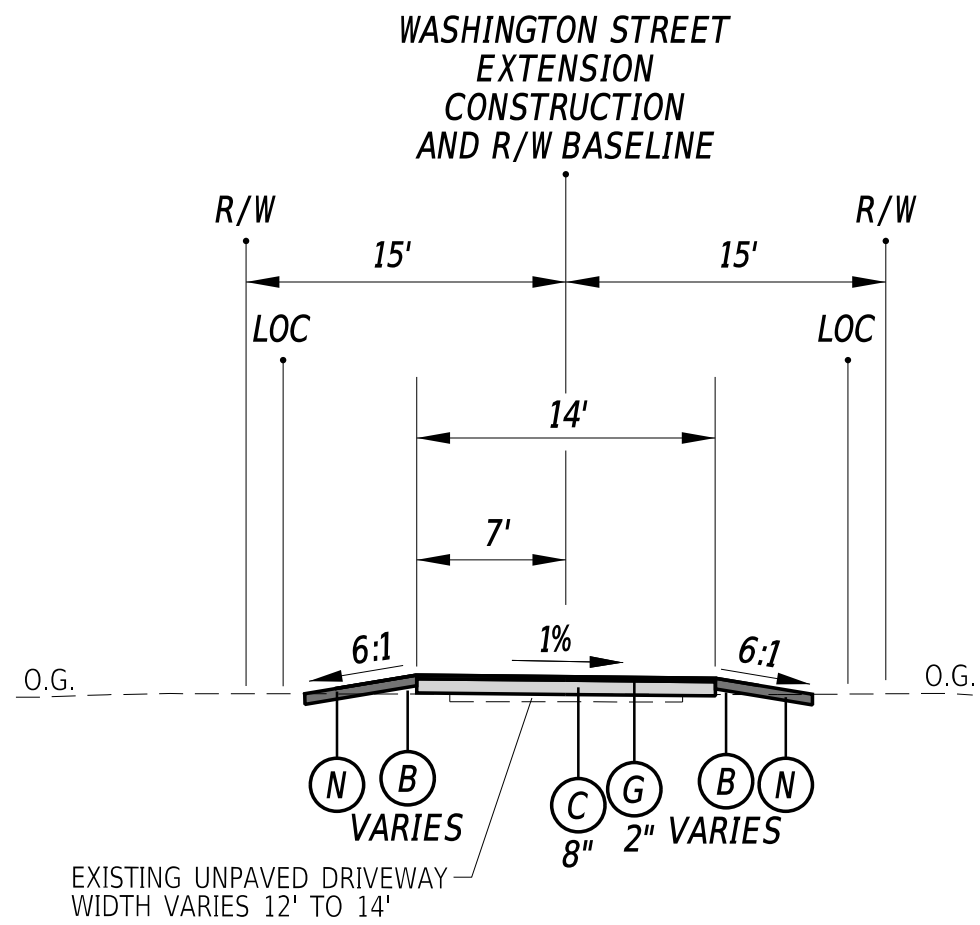

**WASHINGTON STREET EXTENSION -
TYPICAL NORMAL SECTION**
STATION 0+00.00 TO STATION 20+68.00

LEGEND

- (A) ITEM 209001 - BORROW, TYPE A
- (B) ITEM 209006 - BORROW, TYPE F
- (C) ITEM 301001 - GABC
- (D) ITEM 401014 - SUPERPAVE TYPE B, PG 64-22
- (E) ITEM 401005 - SUPERPAVE TYPE C, PG 64-22 (CARBONATE STONE)
- (F) ITEM 401015 - SUPERPAVE TYPE B, PG 70-22
- (G) ITEM 401046 - SUPERPAVE TYPE C, PG 76-22 (NON-CARBONATE STONE)
- (H) ITEM 401036 - SUPERPAVE TYPE C, PG 64-22, WEDGE
- (J) ITEM 401016 - SUPERPAVE TYPE B, PG 76-22
- (K) ITEM 401045 - SUPERPAVE TYPE C, PG 70-22 (NON-CARBONATE STONE)
- (L) ITEM 720021 - GALVANIZED STEEL BEAM GUARDRAIL, TYPE 1-31
- (M) ITEM 760010 - PAVEMENT MILLING, BITUMINOUS CONCRETE PAVEMENT
- (N) ITEM 908004 - TOPSOIL, 6" DEPTH OR ITEM 908010 - TOPSOILING, 6" DEPTH
- (P) ITEM 908014 - PERMANENT GRASS SEEDING, DRY GROUND
- (Q) ITEM 908020 - EROSION CONTROL BLANKET MULCH (8' ROLL WIDTH, MIN.)
- (Q) SAFETY EDGE (INCIDENTAL TO RESPECTIVE SUPERPAVE ITEMS)

MATERIAL	LIFT THICKNESS	
	MINIMUM	MAXIMUM
BITUMINOUS CONCRETE, TYPE 'C' (4.75 MM MIX)	0.5"	1"
BITUMINOUS CONCRETE, TYPE 'C' (9.25 MM MIX)	1.25"	2"
BITUMINOUS CONCRETE, TYPE 'C' (12.5 MM MIX)	1.5"	2"
BITUMINOUS CONCRETE, TYPE 'B' (19 MM MIX), (76-22, 70-22)	2.25"	4"
BITUMINOUS CONCRETE, TYPE 'B' (19 MM MIX), (64-22)	2.25"	6"
GRADED AGGREGATE BASE COURSE	4"	8"

- NOTES:
- PGA - POINT OF GRADE APPLICATION
PDGA - POINT OF DITCH GRADE APPLICATION
P/R - POINT OF ROTATION
 - THE PGA IS APPLIED TO THE TOP OF THE FINAL PAVEMENT SURFACE. IN AREAS WHERE THE PGA IS LOCATED WITHIN THE RAISED MEDIAN, ITS VERTICAL LOCATION SHALL BE THE TOP OF ADJACENT PAVEMENT ELEVATION PROJECTED AT THE PROPOSED CROSS SLOPE TO THE CONSTRUCTION BASELINE.
 - EROSION CONTROL BLANKET IS REQUIRED ON ALL EMBANKMENT SLOPES STEEPER THAN 3:1.

FILL SLOPE RATIO CHART	
HEIGHT OF EMBANKMENT	SLOPE RATIO
0' TO 5'	6:1
5' TO 10'	4:1
>10'	3:1

ADDENDA / REVISIONS

NOT TO SCALE

CM/GC,
NORTH MILLSBORO BYPASS,
US 113 TO SR 24

CONTRACT	BRIDGE NO.	N/A
T202112701	DESIGNED BY:	S. BEALL
COUNTY	CHECKED BY:	T. OLIVER
SUSSEX		

TYPICAL SECTIONS

SECTION
WRA
SHEET NO.
12

3/4/2022
6:13:18 PM
N:\132149-002\CADD\US 113 NM Bypass\HVO1_NMBP.dgn

CONSTRUCTION ALIGNMENT CONTROL FOX RUN ROAD (S326)				
POINT NO.	STATION	OFFSET	NORTHING	EASTING
30050	0+00.00	0.00'	219970.5053	685858.3789
30056	5+00.00	0.00'	219574.7723	686163.9855
30057	10+00.00	0.00'	219179.0393	686469.5922
30058	15+00.00	0.00'	218777.1218	686766.9238
30059	20+00.00	0.00'	218370.7101	687058.1789


CONSTRUCTION ALIGNMENT CONTROL CONRAIL RAILROAD				
POINT NO.	STATION	OFFSET	NORTHING	EASTING
30065	386+00.00	0.00'	219347.2480	687192.0339
30066	390+00.00	0.00'	219015.3669	687415.3161
30067	391+00.00	0.00'	218932.3966	687471.1366

CONSTRUCTION ALIGNMENT CONTROL JERSEY ROAD (S305)				
POINT NO.	STATION	OFFSET	NORTHING	EASTING
30080	69+00.00	0.00'	218673.2927	694461.7949
30084	93+00.00	0.00'	219064.3099	696726.6178
30085	85+00.00	0.00'	219092.3965	695927.1110
30086	90+00.00	0.00'	219074.8423	696426.8027

CONSTRUCTION ALIGNMENT CONTROL GRAVEL HILL ROAD (S248)				
POINT NO.	STATION	OFFSET	NORTHING	EASTING
30060	158+00.00	0.00'	219996.8159	691049.1364
30061	162+00.00	0.00'	219600.4470	691102.9104

CONSTRUCTION ALIGNMENT CONTROL HOLLYVILLE ROAD (S305)				
POINT NO.	STATION	OFFSET	NORTHING	EASTING
30100	0+00.00	0.00'	218849.5805	694683.4047
30105	23+00.00	0.00'	221141.0672	694820.0891
30106	5+00.00	0.00'	219349.3260	694699.3543
30107	10+00.00	0.00'	219849.0716	694715.3039
30108	15+00.00	0.00'	220348.8171	694731.2536

CONSTRUCTION ALIGNMENT CONTROL JOHN J. WILLIAMS HWY (SR 24)				
POINT NO.	STATION	OFFSET	NORTHING	EASTING
30078	40+00.00	0.00'	218924.5623	694322.9459
30079	45+00.00	0.00'	219034.8092	694810.6401

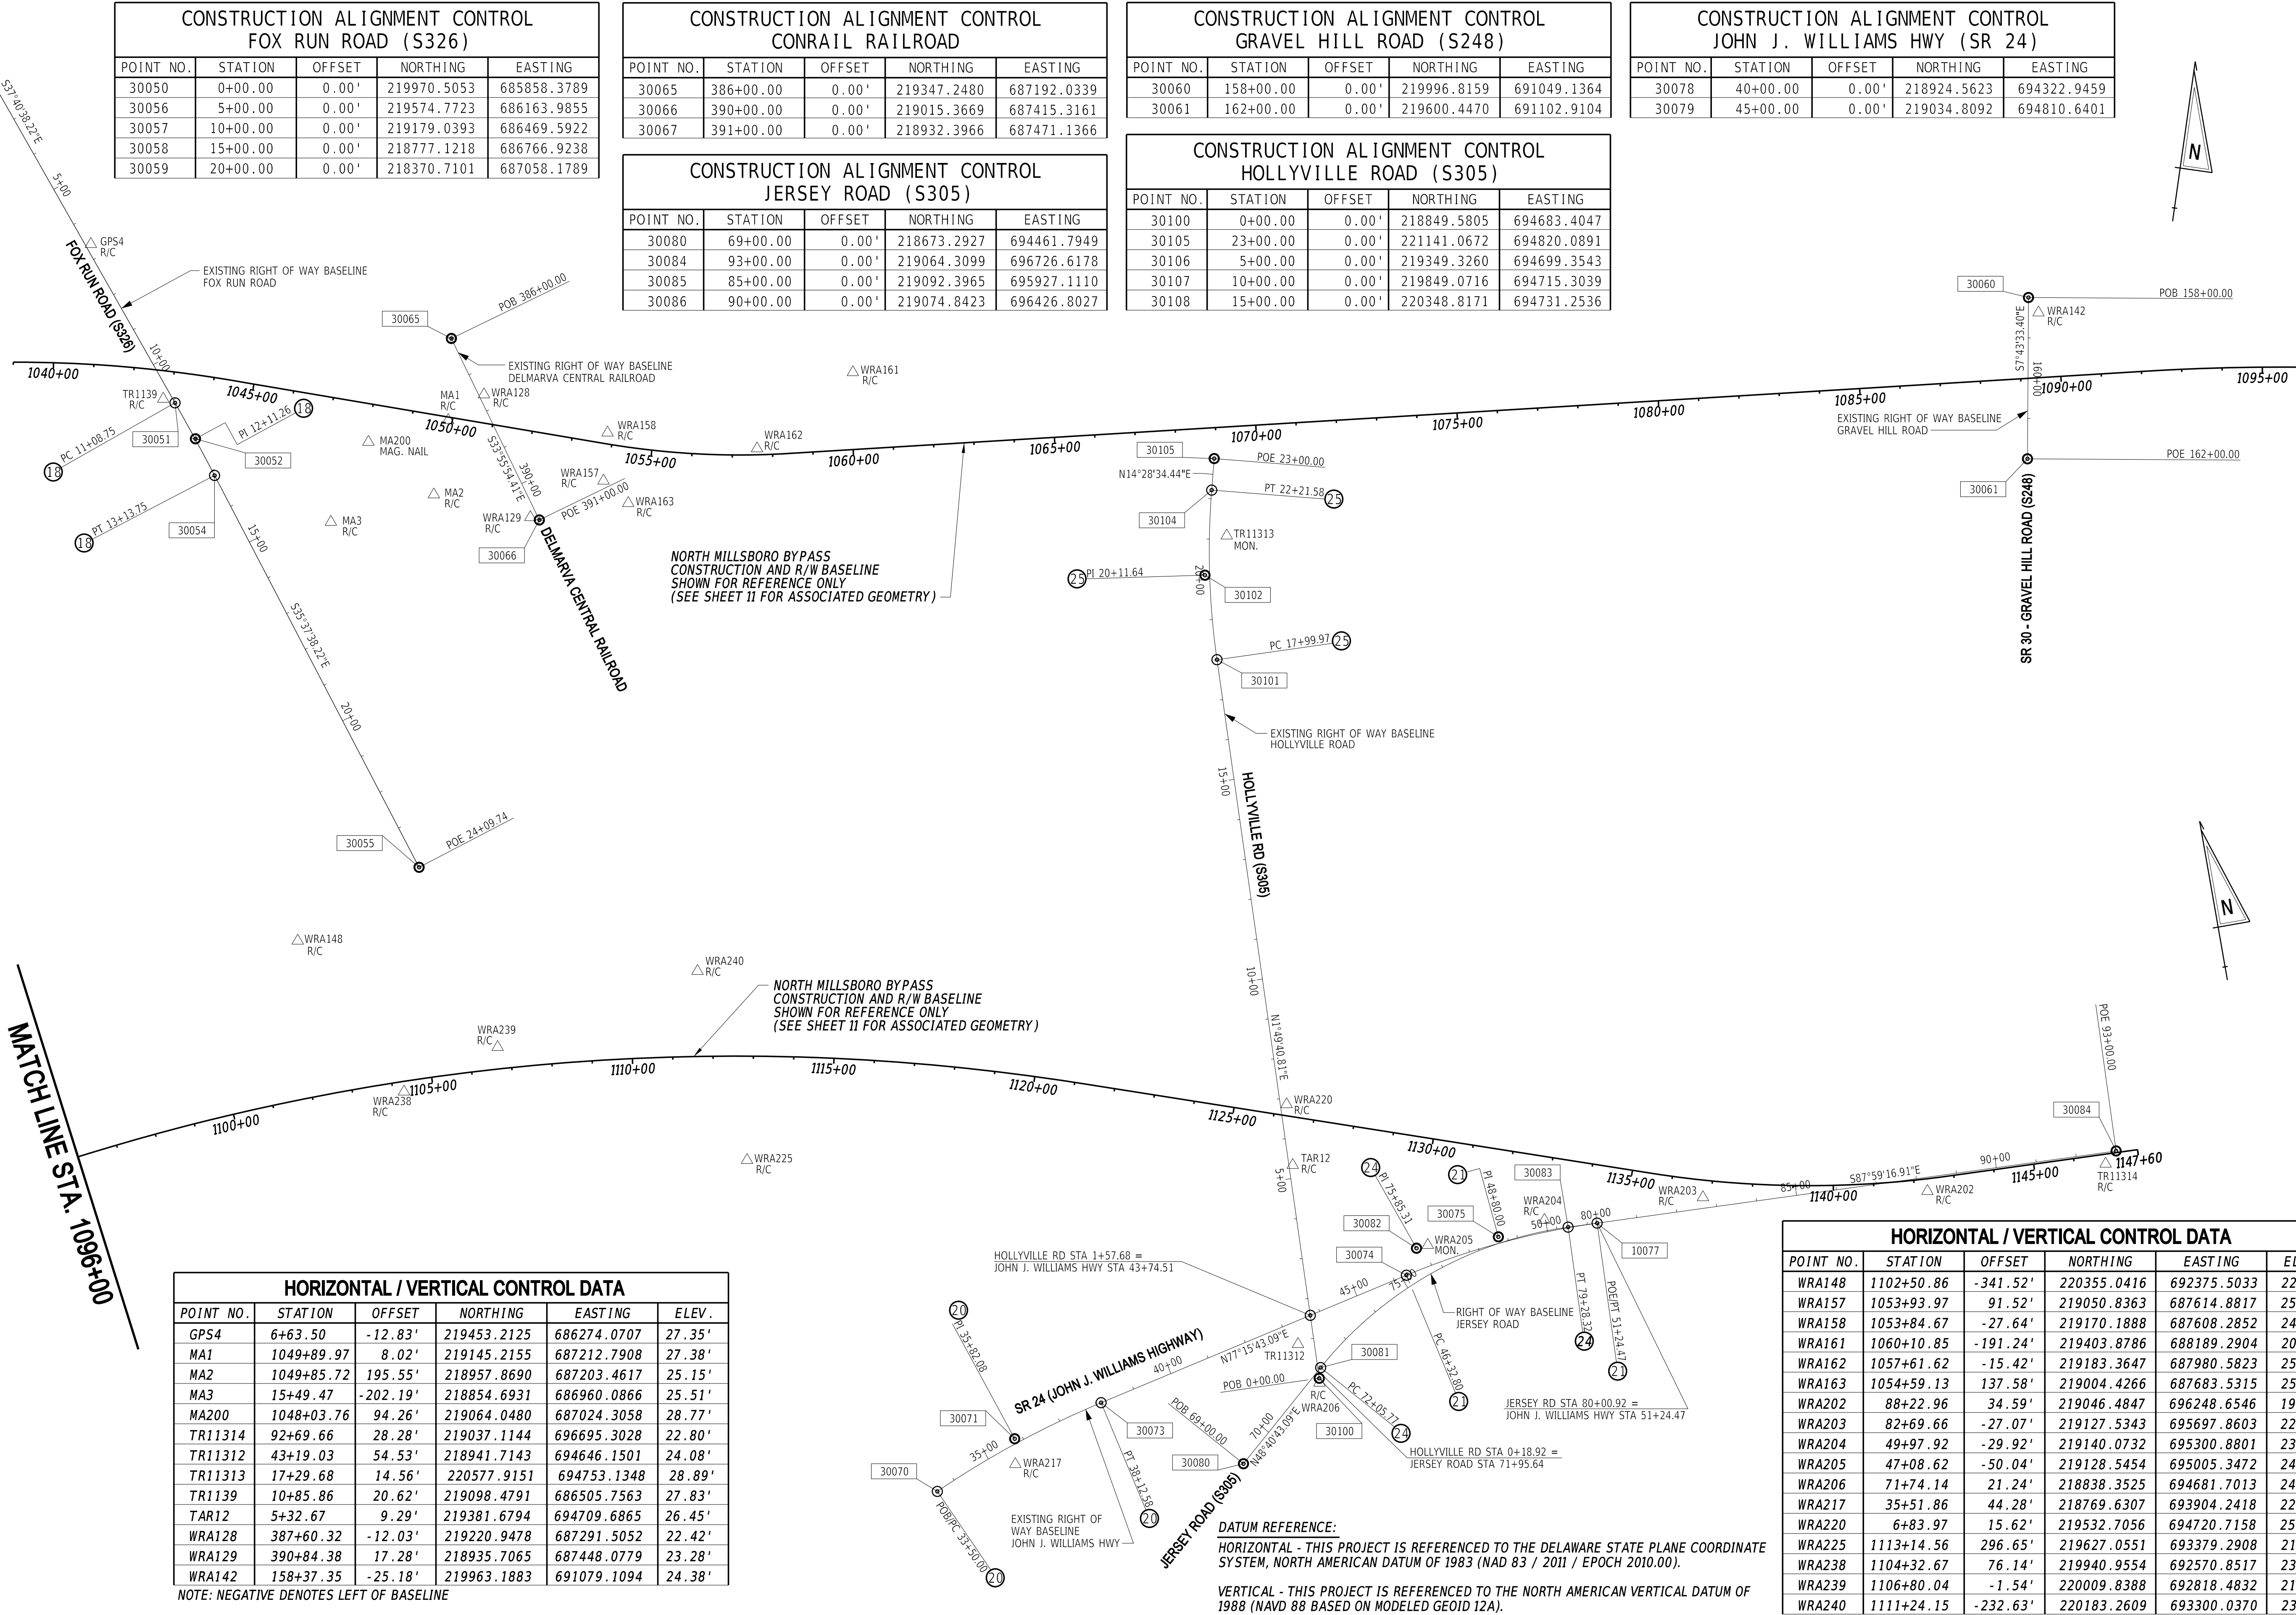

CONSTRUCTION ALIGNMENT CONTROL GRAVEL HILL ROAD CONNECTOR				
POINT NO.	STATION	OFFSET	NORTHING	EASTING
37000	7000+00.00	0.00'	220776.7244	690943.2163
37005	7016+48.19	0.00'	219989.1914	692080.6095


CONSTRUCTION ALIGNMENT CONTROL PROPOSED FOX RUN ROAD				
POINT NO.	STATION	OFFSET	NORTHING	EASTING
36000	6100+00.00	0.00'	219838.4383	685961.0268
36017	6127+40.00	0.00'	218080.0223	687263.1752

CONSTRUCTION ALIGNMENT CONTROL SR 24 (JOHN J. WILLIAMS HIGHWAY)				
POINT NO.	STATION	OFFSET	NORTHING	EASTING
39005	9012+75.00	0.00'	219570.6435	694523.2994

CONSTRUCTION ALIGNMENT CONTROL HOLLYVILLE ROAD				
POINT NO.	STATION	OFFSET	NORTHING	EASTING
39005	9012+75.00	0.00'	219570.6435	694523.2994
39006	9026+50.00	0.00'	220923.3753	694769.7576
39007	9015+00.00	0.00'	219791.9996	694563.6289
39008	9020+00.00	0.00'	220283.9021	694653.2501

CONSTRUCTION ALIGNMENT CONTROL FOX RUN DRIVEWAY				
POINT NO.	STATION	OFFSET	NORTHING	EASTING
36500	6500+00.00	0.00'	218581.7788	686906.9165
36505	6503+47.03	0.00'	218613.3765	687214.8484


CONSTRUCTION ALIGNMENT CONTROL WASHINGTON STREET EXTENSION				
POINT NO.	STATION	OFFSET	NORTHING	EASTING
36050	0+00.00	0.00'	220184.8629	692686.8165
36055	6+71.43	0.00'	220177.7786	693338.1237
36056	8+05.87	0.00'	220191.7166	693471.8363
36057	14+67.56	0.00'	220389.3763	694103.3114
36058	19+50.59	0.00'	220529.2902	694565.6325
36059	20+93.90	0.00'	220564.9080	694704.4474
36060	10+00.00	0.00'	220249.7072	693657.1023
36061	15+00.00	0.00'	220398.7736	694134.3631

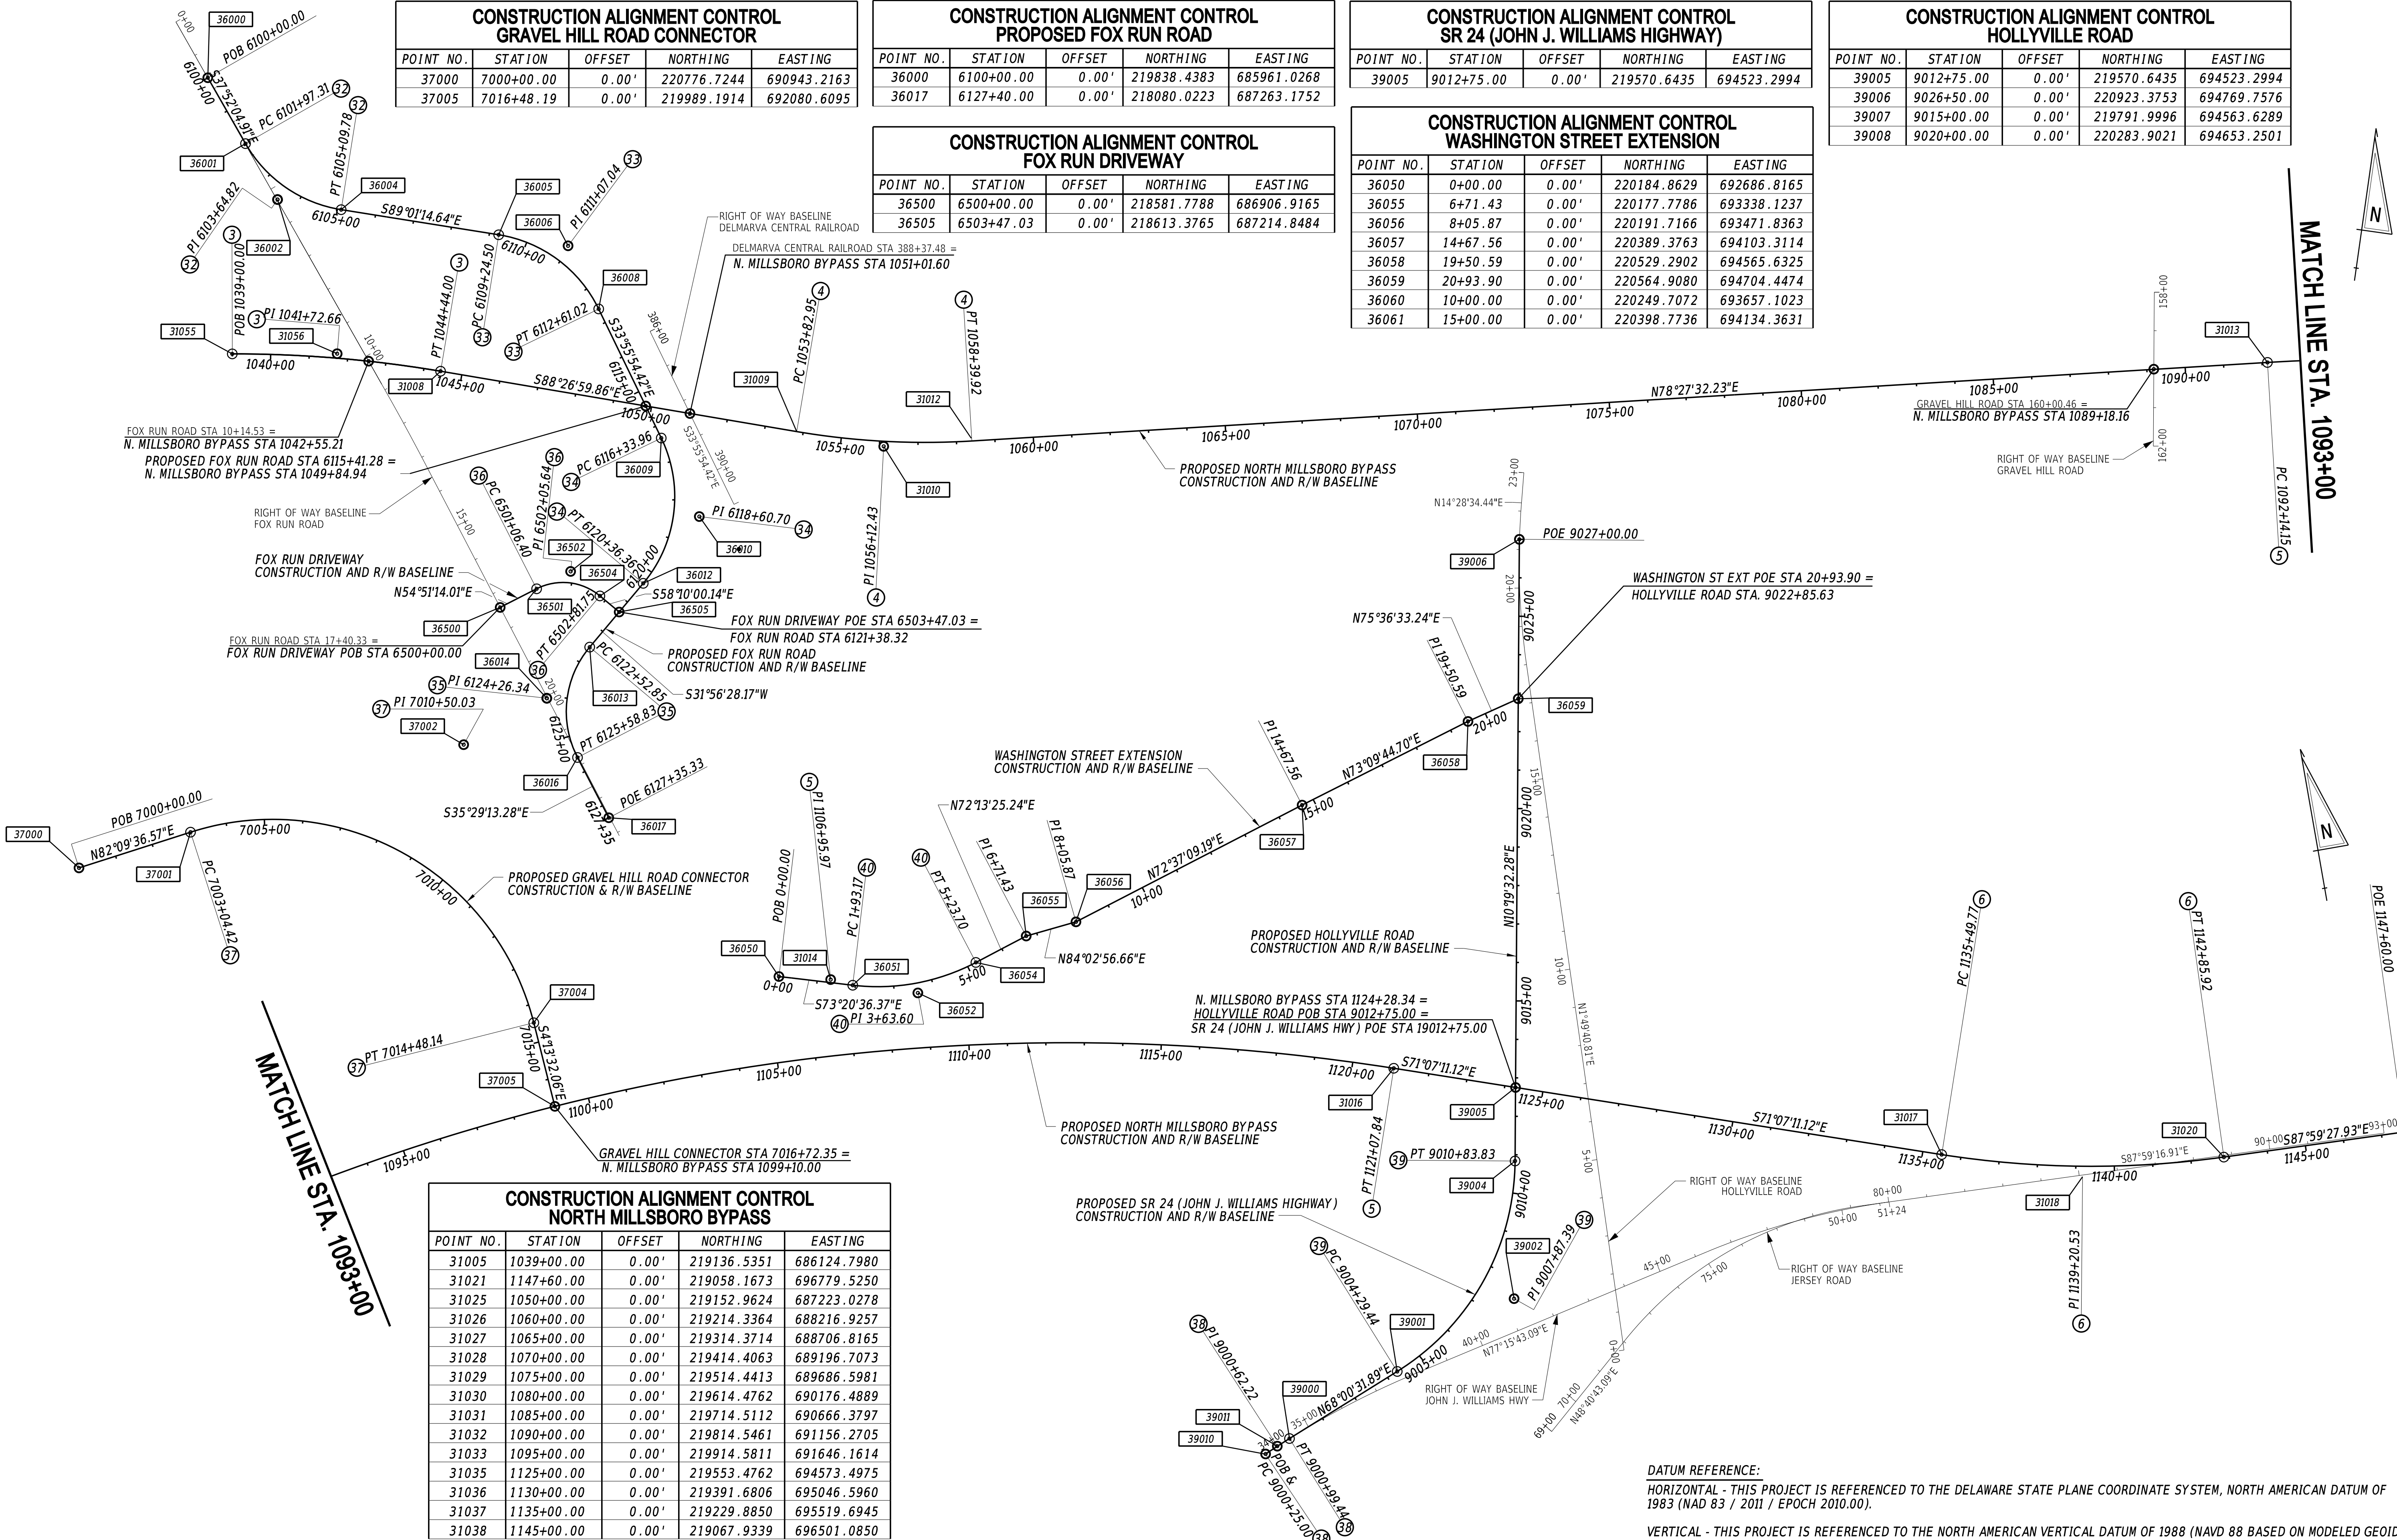

CONSTRUCTION ALIGNMENT CONTROL NORTH MILLSBORO BYPASS				
POINT NO.	STATION	OFFSET	NORTHING	EASTING
31005	1039+00.00	0.00'	219136.5351	686124.7980
31021	1147+60.00	0.00'	219058.1673	696779.5250
31025	1050+00.00	0.00'	219152.9624	687223.0278
31026	1060+00.00	0.00'	219214.3364	688216.9257
31027	1065+00.00	0.00'	219314.3714	688706.8165
31028	1070+00.00	0.00'	219414.4063	689196.7073
31029	1075+00.00	0.00'	219514.4413	689686.5981
31030	1080+00.00	0.00'	219614.4762	690176.4889
31031	1085+00.00	0.00'	219714.5112	690666.3797
31032	1090+00.00	0.00'	219814.5461	691156.2705
31033	1095+00.00	0.00'	219914.5811	691646.1614
31035	1125+00.00	0.00'	219553.4762	694573.4975
31036	1130+00.00	0.00'	219391.6806	695046.5960
31037	1135+00.00	0.00'	219229.8850	695519.6945
31038	1145+00.00	0.00'	219067.9339	696501.0850

DATUM REFERENCE:
HORIZONTAL - THIS PROJECT IS REFERENCED TO THE DELAWARE STATE PLANE COORDINATE SYSTEM, NORTH AMERICAN DATUM OF 1983 (NAD 83 / 2011 / EPOCH 2010.00).
VERTICAL - THIS PROJECT IS REFERENCED TO THE NORTH AMERICAN VERTICAL DATUM OF 1988 (NAVD 88 BASED ON MODELED GEOID 12A).

ADDENDA / REVISIONS

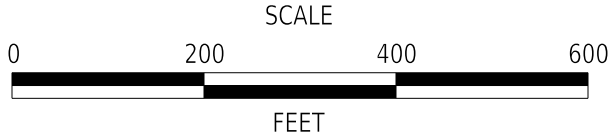

CM/GC,
NORTH MILLSBORO BYPASS,
US 113 TO SR 24

CONTRACT	BRIDGE NO.	N/A
T202112701	DESIGNED BY:	S. BEALL
COUNTY	CHECKED BY:	T. OLIVER
SUSSEX		


HORIZONTAL AND
VERTICAL CONTROL
PROPOSED BASELINES

SECTION
WRA
SHEET NO.
14

3/4/2022
6:13:20 PM
N:\132149-002\CADD\US 113 NM Bypass\HV03_NMBP.dgn


NORTH MILLSBORO BYPASS CIRCULAR CURVE NO. ③				FOX RUN ROAD CIRCULAR CURVE NO. ⑱				HOLLYVILLE ROAD CIRCULAR CURVE NO. ②5													
Element: Circular PC (31055)1039+00.00219136.5351686124.7980 PI (31056)1041+72.66219175.3776686394.6729 CC (31007)215969.1732686580.6689 PT (31008)1044+44.00219168.0023686667.2289 Radius:3200.00 Delta:9°44'24.87" Right Degree of Curvature(Arc):1°47'25.78" Length:544.00 Tangent:272.66 Chord:543.34 Middle Ordinate:11.55 External:11.59 Tangent Direction: N 81°48'35.27" E Radial Direction: S 8°11'24.73" E Chord Direction: N 86°40'47.71" E Radial Direction: S 1°33'00.14" W Tangent Direction: S 88°26'59.86" E				Element: Circular PC (30051)11+08.75219092.9674686536.0616 PI (30052)12+11.26219011.8335686598.7177 CC (30053)215590.9733682001.2958 PT (30054)13+13.75218928.5102686658.4313 Radius:5729.58 Delta:2°03'00.00" Right Degree of Curvature(Arc):1°00'00.00" Length:205.00 Tangent:102.51 Chord:204.99 Middle Ordinate:0.92 External:0.92 Tangent Direction: S 37°40'38.22" E Radial Direction: S 52°19'21.78" W Chord Direction: S 36°39'08.22" E Radial Direction: S 54°22'21.78" W Tangent Direction: S 35°37'38.22" E				Element: Circular PC (30101)17+99.97220648.6365694740.8225 PI (30102)20+11.64220860.1929694747.5744 CC (30103)220587.7134696649.7099 PT (30104)22+21.58221065.1370694800.4859 Radius:1909.86 Delta:12°38'53.63" Right Degree of Curvature(Arc):3°00'00.00" Length:421.61 Tangent:211.66 Chord:420.75 Middle Ordinate:11.62 External:11.69 Tangent Direction: N 1°49'40.81" E Radial Direction: S 88°10'19.19" E Chord Direction: N 8°09'07.63" E Radial Direction: S 75°31'25.56" E Tangent Direction: N 14°28'34.44" E													
NORTH MILLSBORO BYPASS CIRCULAR CURVE NO. ④				SR 24 CIRCULAR CURVE NO. ⑳				PROPOSED FOX RUN ROAD CIRCULAR CURVE NO. ③2													
Element: Circular PC (31009)1053+82.95219142.6036687605.8389 PI (31010)1056+12.43219136.3961687835.2367 CC (31011)221141.8717687659.9389 PT (31012)1058+39.92219182.3085688060.0787 Radius:2000.00 Delta:13°05'27.91" Left Degree of Curvature(Arc):2°51'53.24" Length:456.97 Tangent:229.48 Chord:455.97 Middle Ordinate:13.04 External:13.12 Tangent Direction: S 88°26'59.86" E Radial Direction: S 1°33'00.14" W Chord Direction: N 85°00'16.19" E Radial Direction: S 11°32'27.77" E Tangent Direction: N 78°27'32.23" E				Element: Circular PC (30070)33+50.00218736.5891693702.2454 PI (30071)35+82.08218832.0657693913.7729 CC (30072)216645.9401694645.8960 PT (30073)38+12.58218883.2373694140.1384 Radius:2293.75 Delta:11°33'17.36" Right Degree of Curvature(Arc):2°29'52.47" Length:462.58 Tangent:232.08 Chord:461.80 Middle Ordinate:11.65 External:11.71 Tangent Direction: N 65°42'25.71" E Radial Direction: S 24°17'34.29" E Chord Direction: N 71°29'04.41" E Radial Direction: S 12°44'16.93" E Tangent Direction: N 77°15'43.07" E				Element: Circular PC (36001)6101+97.31219682.6764686082.1445 PI (36002)6103+64.82219550.4362686184.9723 CC (36003)219897.5221686358.4439 PT (36004)6105+09.78219547.5733686352.4622 Radius:350.00 Delta:51°09'09.73" Left Degree of Curvature(Arc):16°22'12.80" Length:312.47 Tangent:167.51 Chord:302.20 Middle Ordinate:34.30 External:38.02 Tangent Direction: S 37°52'04.91" E Radial Direction: S 52°07'55.09" W Chord Direction: S 63°26'39.78" E Radial Direction: S 0°58'45.36" W Tangent Direction: S 89°01'14.64" E													
NORTH MILLSBORO BYPASS CIRCULAR CURVE NO. ⑤				SR 24 CIRCULAR CURVE NO. ㉑				PROPOSED FOX RUN ROAD CIRCULAR CURVE NO. ③3													
Element: Circular PC (31013)1092+14.15219857.3909691366.0898 PI (31014)1106+95.97220153.8584692817.9494 CC (31015)214517.5810692456.4708 PT (31016)1121+07.84219674.3546694220.0427 Radius:5450.00 Delta:30°25'16.65" Right Degree of Curvature(Arc):1°03'04.68" Length:2893.69 Tangent:1481.82 Chord:2859.82 Middle Ordinate:190.93 External:197.86 Tangent Direction: N 78°27'32.23" E Radial Direction: S 11°32'27.77" E Chord Direction: S 86°19'49.45" E Radial Direction: S 18°52'48.88" W Tangent Direction: S 71°07'11.12" E				Element: Circular PC (30074)46+32.80219064.0907694940.1717 PI (30075)48+80.00219118.5971695181.2894 CC (30076)217201.2235695361.2864 PT (30077)51+24.47219109.9183695428.3387 Radius:1909.87 Delta:14°45'00.00" Right Degree of Curvature(Arc):2°59'59.93" Length:491.67 Tangent:247.20 Chord:490.31 Middle Ordinate:15.80 External:15.93 Tangent Direction: N 77°15'43.09" E Radial Direction: S 12°44'16.91" E Chord Direction: N 84°38'13.09" E Radial Direction: S 2°00'43.09" W Tangent Direction: S 87°59'16.91" E				Element: Circular PC (36005)6109+24.50219540.4856686767.1142 PI (36006)6111+07.04219537.3658686949.6315 CC (36007)219190.5367686761.1325 PT (36008)6112+61.02219385.9086687051.5285 Radius:350.00 Delta:55°05'20.2244" Right Degree of Curvature(Arc):16°22'12.8018" Length:336.52 Tangent:182.54 Chord:323.71 Middle Ordinate:39.67 External:44.74 Tangent Direction: S 89°01'14.6398" E Radial Direction: S 0°58'45.3602" W Chord Direction: S 61°28'34.5276" E Radial Direction: S 56°04'05.5846" W Tangent Direction: S 33°55'54.4154" E													
NORTH MILLSBORO BYPASS CIRCULAR CURVE NO. ⑥				JERSEY ROAD CIRCULAR CURVE NO. ㉒				PROPOSED FOX RUN ROAD CIRCULAR CURVE NO. ③4													
Element: Circular PC (31017)1135+68.38219207.7570695584.3978 PI (31018)1139+39.14219087.7829695935.2082 CC (31019)221573.2495696393.3758 PT (31020)1143+04.53219074.7860696305.7386 Radius:2500.00 Delta:16°52'16.81" Left Degree of Curvature(Arc):2°17'30.59" Length:736.15 Tangent:370.76 Chord:733.49 Middle Ordinate:27.05 External:27.34 Tangent Direction: S 71°07'11.12" E Radial Direction: S 18°52'48.88" W Chord Direction: S 79°33'19.53" E Radial Direction: S 2°00'32.07" W Tangent Direction: S 87°59'27.93" E				Element: Circular PC (30081)72+05.77218875.1871694691.4336 PI (30082)75+85.31219125.7922694976.4770 CC (30083)218157.6899695322.2444 PT (30084)79+28.32219112.4671695355.7857 Radius:955.37 Delta:43°20'00.00" Right Degree of Curvature(Arc):5°59'50.13" Length:722.55 Tangent:379.54 Chord:705.45 Middle Ordinate:67.50 External:72.63 Tangent Direction: N 48°40'43.09" E Radial Direction: S 41°19'16.91" E Chord Direction: N 70°20'43.09" E Radial Direction: S 2°00'43.09" W Tangent Direction: S 87°59'16.91" E				Element: Circular PC (36009)6116+33.96219076.4750687259.7085 PI (36010)6118+60.70218888.3471687386.2767 CC (36011)218881.1031686969.3125 PT (36012)6120+36.36218695.9363687266.3197 Radius:350.00 Delta:65°52'22.5848" Right Degree of Curvature(Arc):16°22'12.8018" Length:402.39 Tangent:226.74 Chord:380.60 Middle Ordinate:56.25 External:67.03 Tangent Direction: S 33°55'54.4154" E Radial Direction: S 56°04'05.5846" W Chord Direction: S 0°59'43.1230" E Radial Direction: N 58°03'31.8307" W Tangent Direction: S 31°56'28.1693" W													
ADDENDA / REVISIONS				NOT TO SCALE				CM/GC, NORTH MILLSBORO BYPASS, US 113 TO SR 24				CONTRACT T202112701 COUNTY SUSSEX		BRIDGE NO. DESIGNED BY: S. BEALL CHECKED BY: T. OLIVER		N/A		HORIZONTAL AND VERTICAL CONTROL		SECTION WRA SHEET NO. 15	

3/4/2022
6:13:23 PM
N:\132149-002\CADD\US 113 NM Bypass\CP01_NMBP.dgn

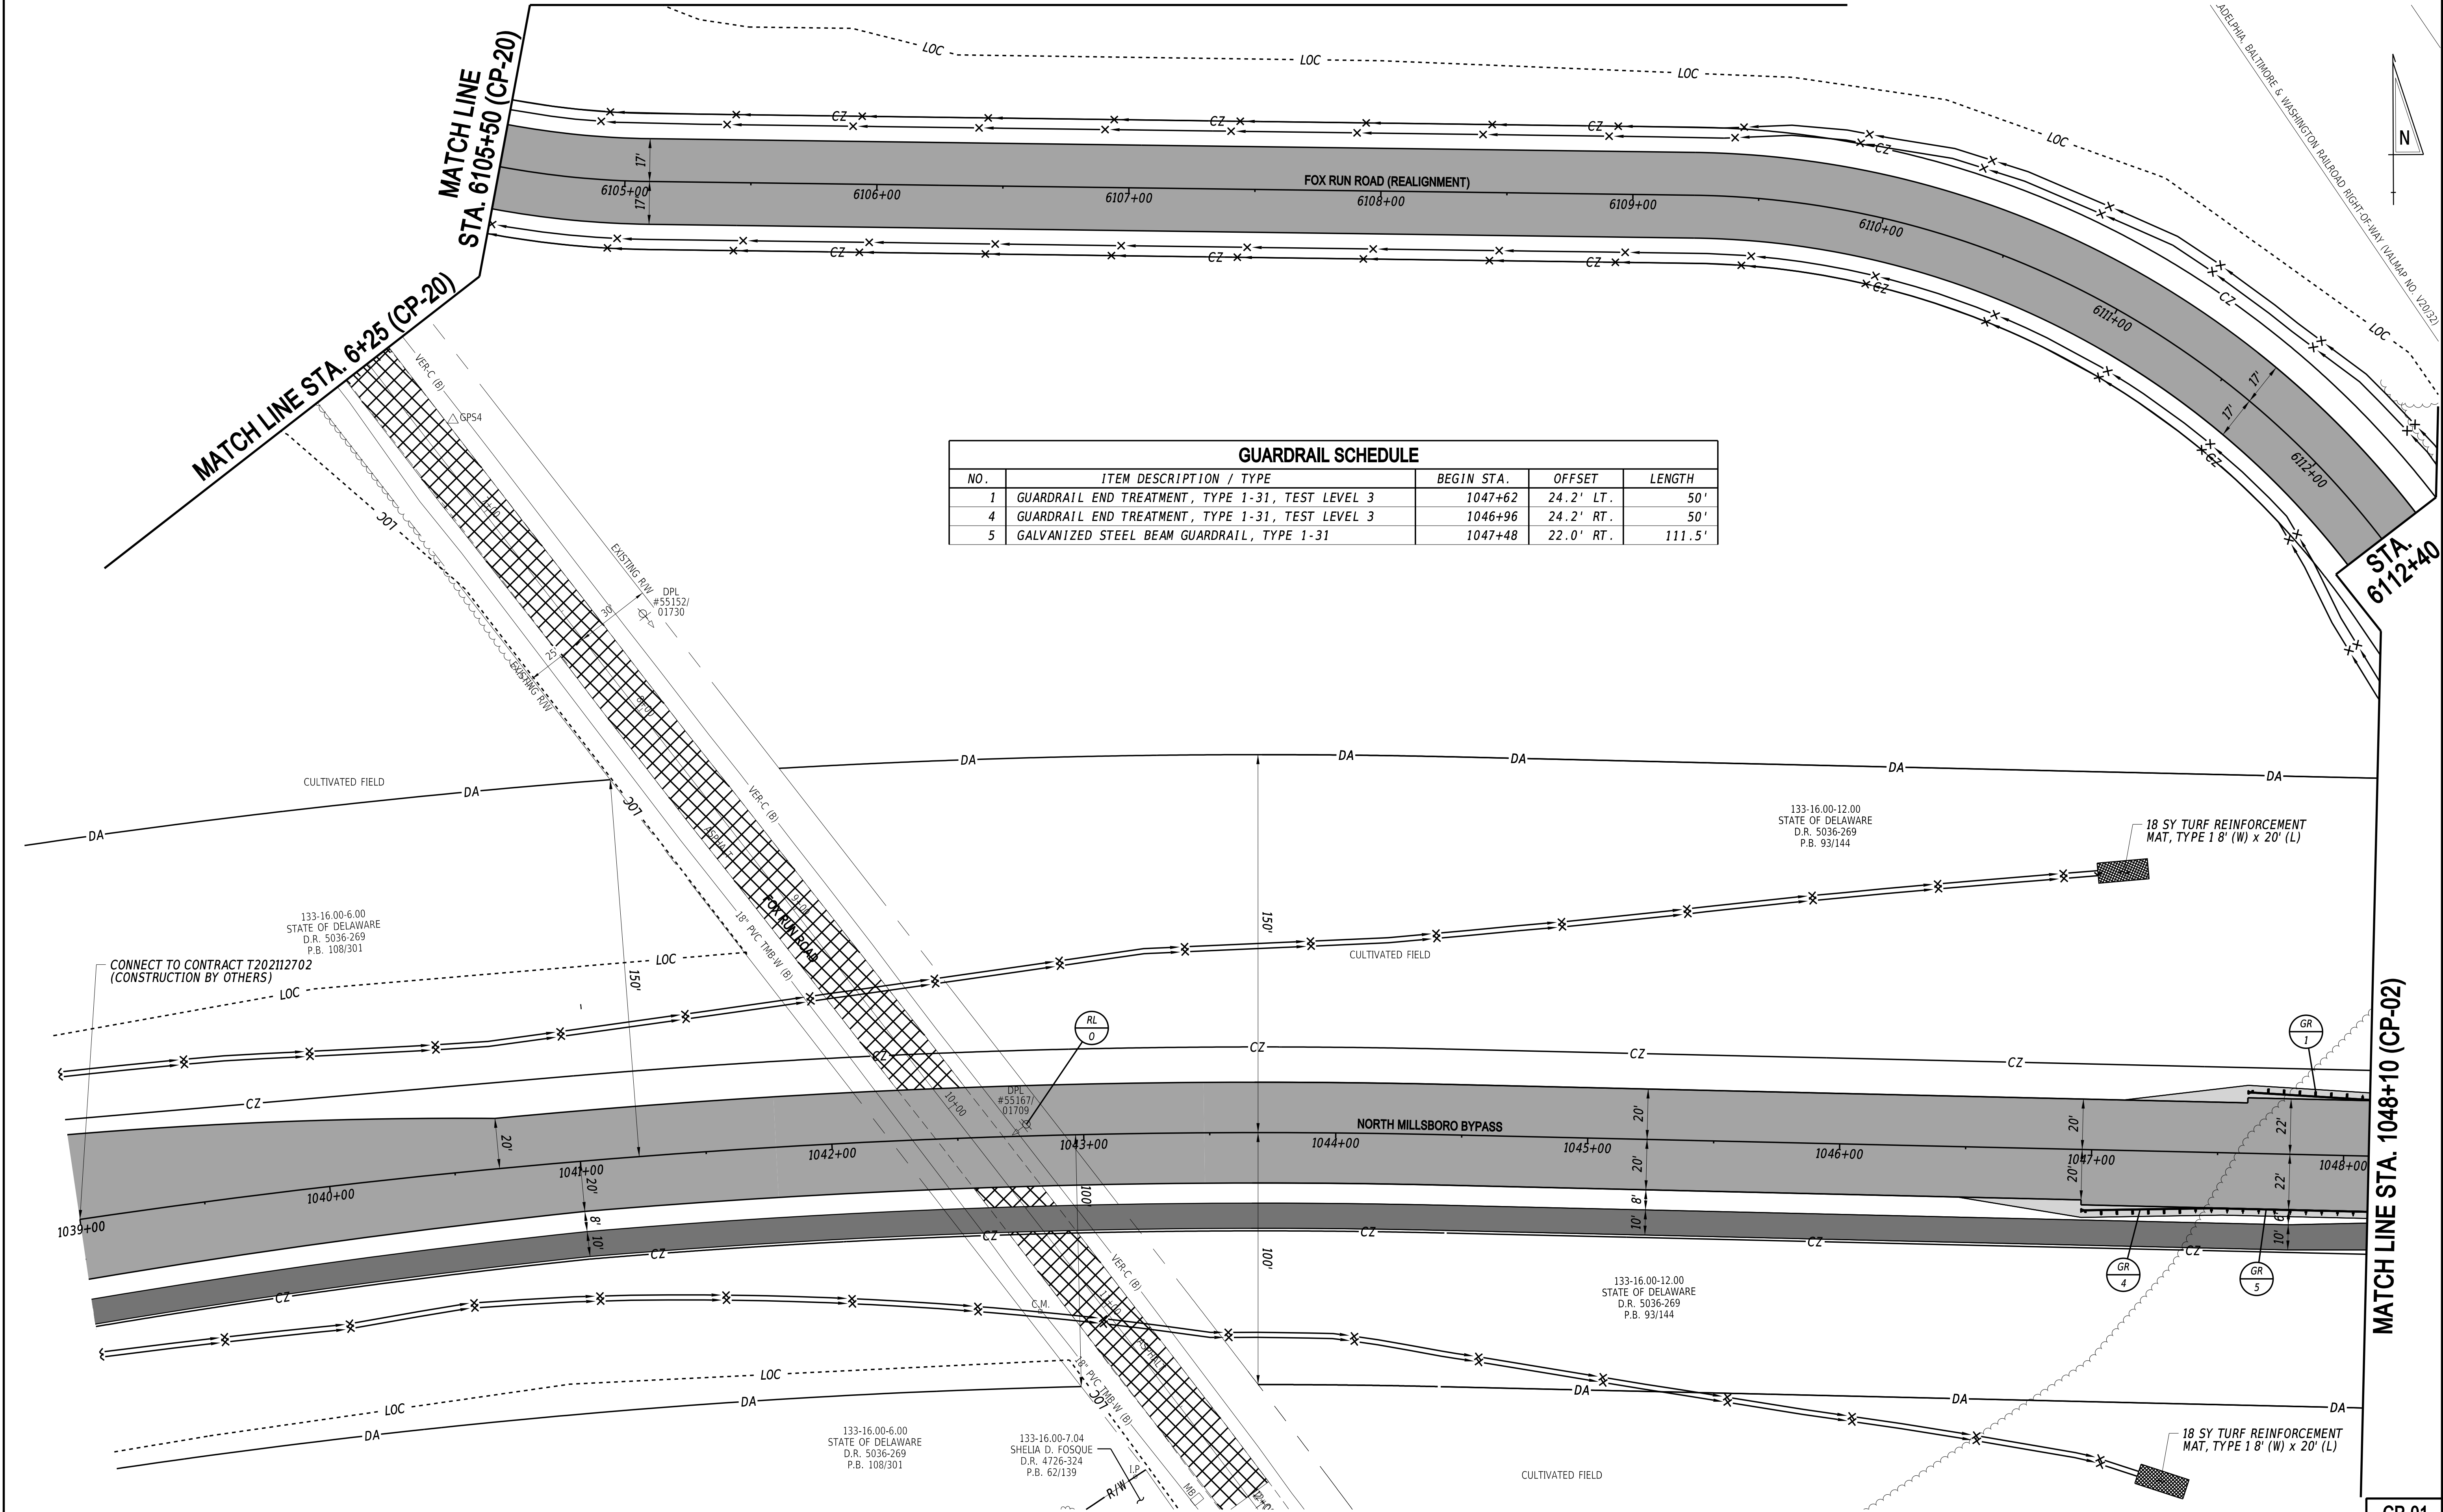

GUARDRAIL SCHEDULE				
NO.	ITEM DESCRIPTION / TYPE	BEGIN STA.	OFFSET	LENGTH
1	GUARDRAIL END TREATMENT, TYPE 1-31, TEST LEVEL 3	1047+62	24.2' LT.	50'
4	GUARDRAIL END TREATMENT, TYPE 1-31, TEST LEVEL 3	1046+96	24.2' RT.	50'
5	GALVANIZED STEEL BEAM GUARDRAIL, TYPE 1-31	1047+48	22.0' RT.	111.5'

ADDENDA / REVISIONS	

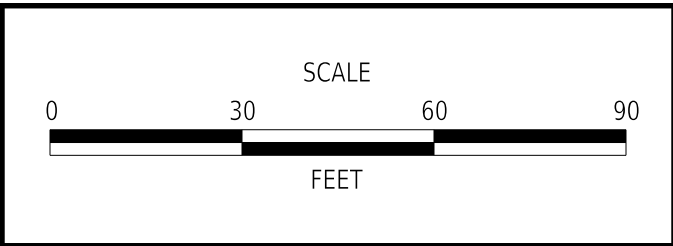


CM/GC,
NORTH MILLSBORO BYPASS,
US 113 TO SR 24

CONTRACT	BRIDGE NO.	N/A
T202112701	DESIGNED BY:	S. BEALL
COUNTY	CHECKED BY:	T. OLIVER
SUSSEX		

CONSTRUCTION PLAN	

CP-01
SECTION
WRA
SHEET NO.
17


GUARDRAIL SCHEDULE				
NO.	ITEM DESCRIPTION / TYPE	BEGIN STA.	OFFSET	LENGTH
2	GALVANIZED STEEL BEAM GUARDRAIL, TYPE 1-31	1048+13	22.0' LT.	30.25'
3	GUARDRAIL TO BARRIER CONNECTION, APPROACH TYPE 1-31	1048+44	22.0' LT.	19.75'
6	GUARDRAIL TO BARRIER CONNECTION, APPROACH TYPE 1-31	1048+60	22.0' RT.	19.75'
7	GUARDRAIL TO BARRIER CONNECTION, APPROACH TYPE 1-31	1051+95	22.0' LT.	19.75'
8	GALVANIZED STEEL BEAM GUARDRAIL, TYPE 1-31	1052+14	22.0' LT.	111.5'
9	GUARDRAIL END TREATMENT, TYPE 1-31, TEST LEVEL 3	1053+26	22.0' LT.	50'
10	GUARDRAIL TO BARRIER CONNECTION, APPROACH TYPE 1-31	1052+11	22.0' RT.	19.75'
11	GALVANIZED STEEL BEAM GUARDRAIL, TYPE 1-31	1052+30	22.0' RT.	30.25'
12	GUARDRAIL END TREATMENT, TYPE 1-31, TEST LEVEL 3	1052+61	22.0' RT.	50'
37	GALVANIZED STEEL BEAM GUARDRAIL, TYPE 1-31	6115+08	24.0' LT.	76.0'
38	GUARDRAIL END TREATMENT, TYPE 1-31, TEST LEVEL 3	6116+34	24.0' LT.	40'

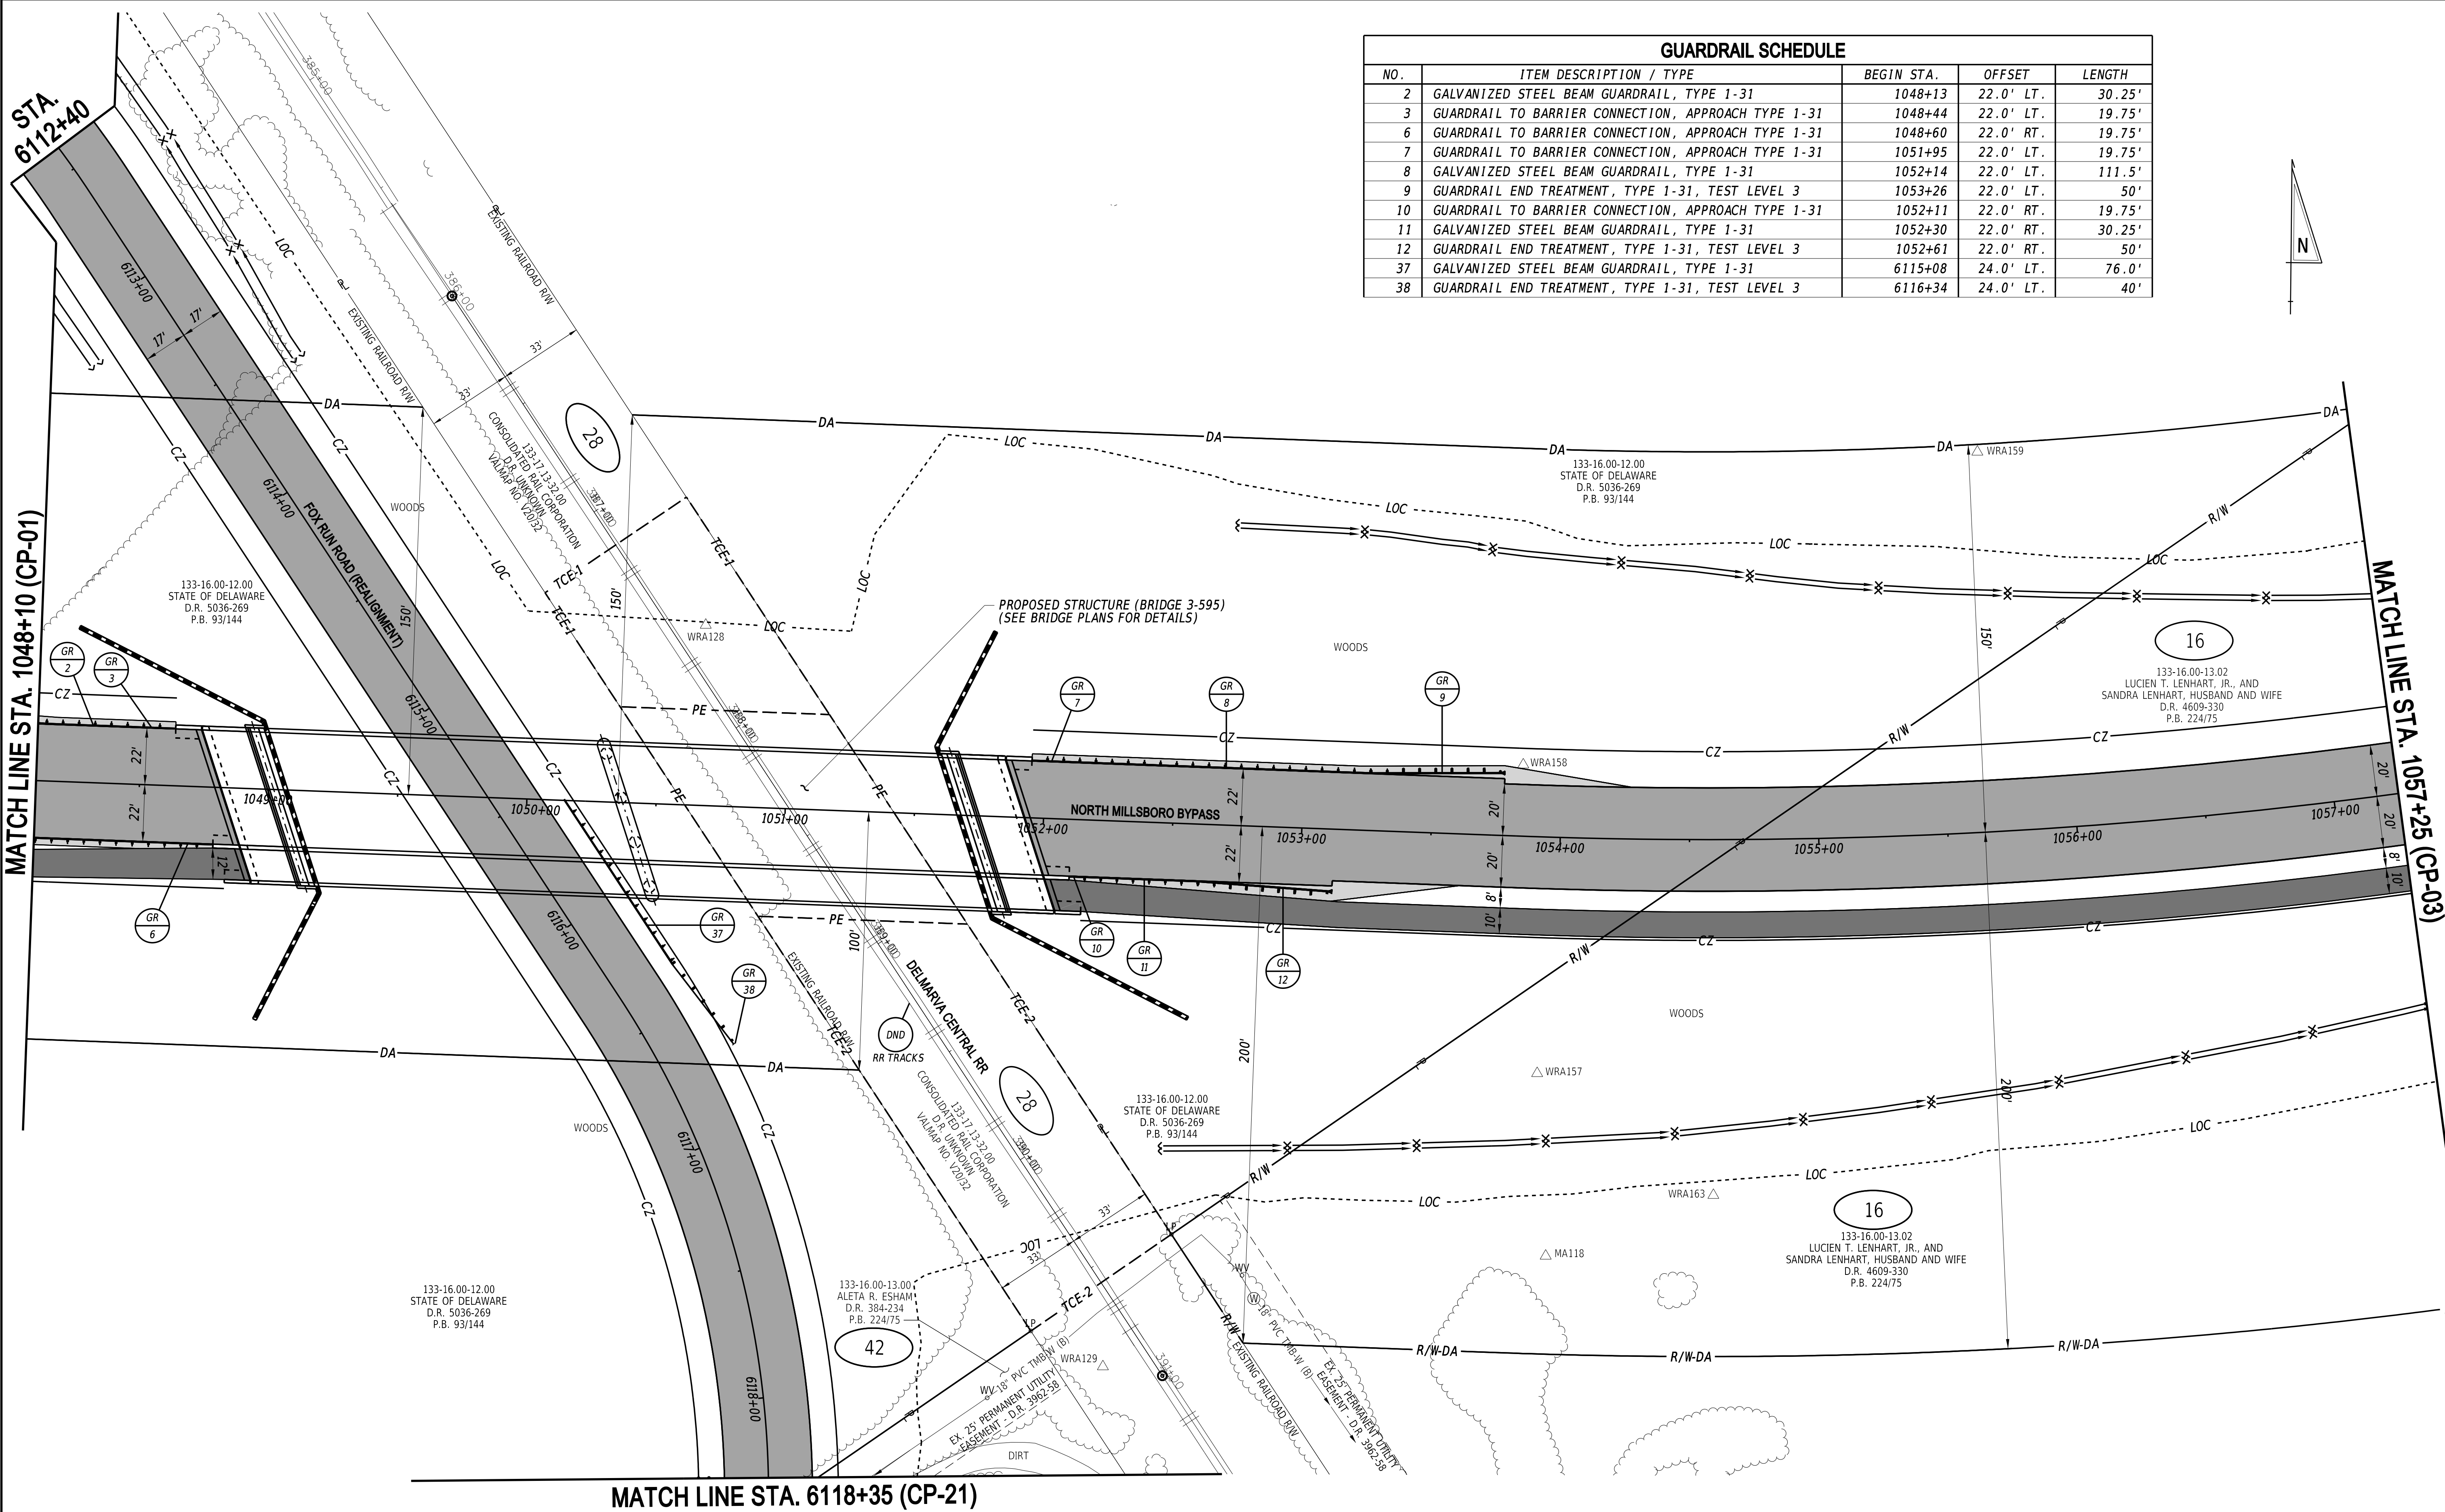

ADDENDA / REVISIONS		SCALE 0 30 60 90 FEET	CM/GC, NORTH MILLSBORO BYPASS, US 113 TO SR 24	CONTRACT T202112701	BRIDGE NO. 3-595	CONSTRUCTION PLAN	CP-02
				COUNTY SUSSEX	DESIGNED BY: S. BEALL CHECKED BY: T. OLIVER		SECTION WRA SHEET NO. 18

3/4/2022
6:13:24 PM
N:\132149-002\CADD\US 113 NM Bypass\CP02_NMBP.dgn

DELDOT SWM FACILITY SCHEDULE		
NO.	TYPE / DESCRIPTION	LOCATION
101	INFILTRATION TRENCH	STA. 1058+00 LT. TO STA. 1060+00 LT.

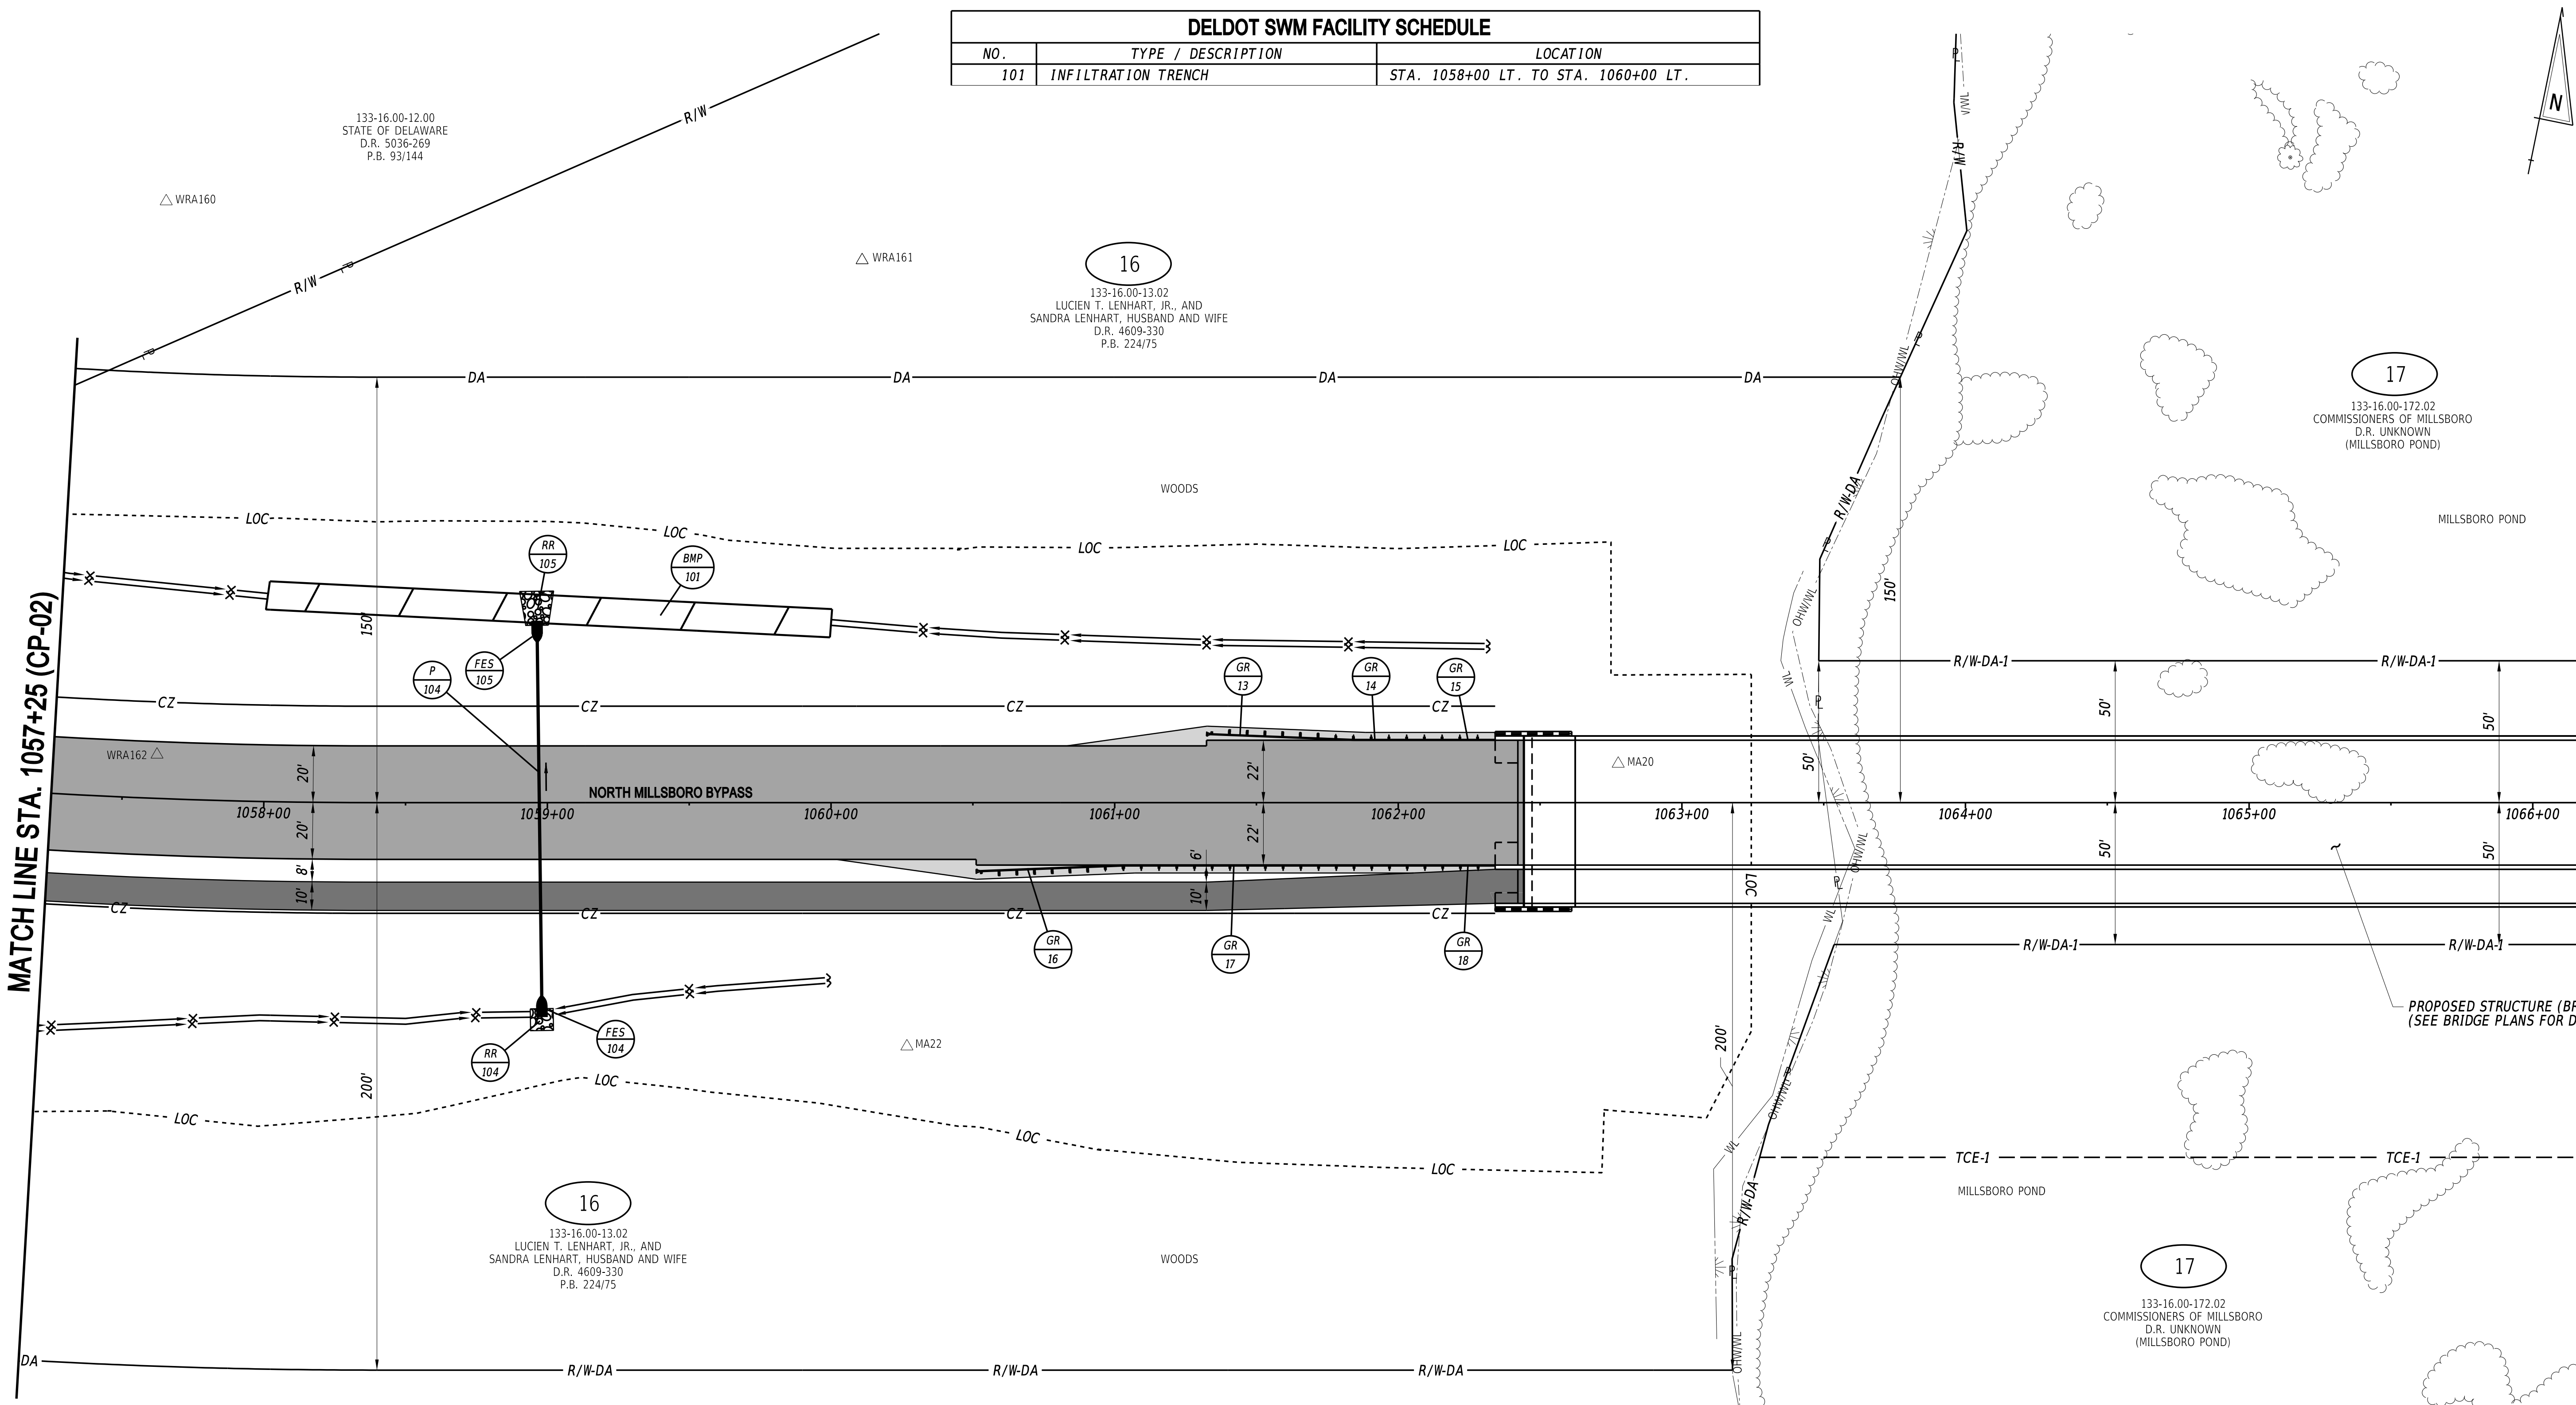

DRAINAGE PIPE SCHEDULE						
NO.	SIZE / TYPE	CLASS	LENGTH	SLOPE	INT. EL.	DIS. EL.
104	18" RCP	IV	135'	0.0191	22.50	19.92

FLARED END SECTION SCHEDULE			
NO.	SIZE / TYPE	SLOPE	SAFETY GRATE
104	18" RCP	0.0191	NO
105	18" RCP	0.0191	NO

RIPRAP SCHEDULE		
NO.	TYPE	AREA (SY)
104	R-4	7
105	R-4	14

GUARDRAIL SCHEDULE				
NO.	ITEM DESCRIPTION / TYPE	BEGIN STA.	OFFSET	LENGTH
13	GUARDRAIL END TREATMENT, TYPE 1-31, TEST LEVEL 3	1061+32	24.2' LT.	50'
14	GALVANIZED STEEL BEAM GUARDRAIL, TYPE 1-31	1061+84	22.0' LT.	30.25'
15	GUARDRAIL TO BARRIER CONNECTION, APPROACH TYPE 1-31	1062+14	22.0' LT.	19.75'
16	GUARDRAIL END TREATMENT, TYPE 1-31, TEST LEVEL 3	1060+51	24.2' RT.	50'
17	GALVANIZED STEEL BEAM GUARDRAIL, TYPE 1-31	1061+03	22.0' RT.	111.5'
18	GUARDRAIL TO BARRIER CONNECTION, APPROACH TYPE 1-31	1062+14	22.0' RT.	19.75'

3/4/2022 6:13:25 PM N:\32149-002\CADD\US 113 NM Bypass\CP03_NMBP.dgn

ADDENDA / REVISIONS

SCALE

0 30 60 90

FEET

CM/GC,
NORTH MILLSBORO BYPASS,
US 113 TO SR 24

CONTRACT	BRIDGE NO.	3-596
T202112701	DESIGNED BY:	S. BEALL
COUNTY	CHECKED BY:	T. OLIVER
SUSSEX		

CONSTRUCTION PLAN


SECTION	CP-03
WRA	
SHEET NO.	19

GUARDRAIL SCHEDULE				
NO.	ITEM DESCRIPTION / TYPE	BEGIN STA.	OFFSET	LENGTH
19	GUARDRAIL TO BARRIER CONNECTION, APPROACH TYPE 1-31	1070+44	22.0' LT.	19.75'
20	GALVANIZED STEEL BEAM GUARDRAIL, TYPE 1-31	1070+64	22.0' LT.	111.5'
21	GUARDRAIL END TREATMENT, TYPE 1-31, TEST LEVEL 3	1071+76	22.0' LT.	50'
22	GUARDRAIL TO BARRIER CONNECTION, APPROACH TYPE 1-31	1070+44	22.0' RT.	19.75'
23	GALVANIZED STEEL BEAM GUARDRAIL, TYPE 1-31	1070+64	22.0' RT.	30.25'
24	GUARDRAIL END TREATMENT, TYPE 1-31, TEST LEVEL 3	1070+94	22.0' RT.	50'




MATCH LINE STA. 1066+50 (CP-03)

MATCH LINE STA. 1075+50 (CP-05)

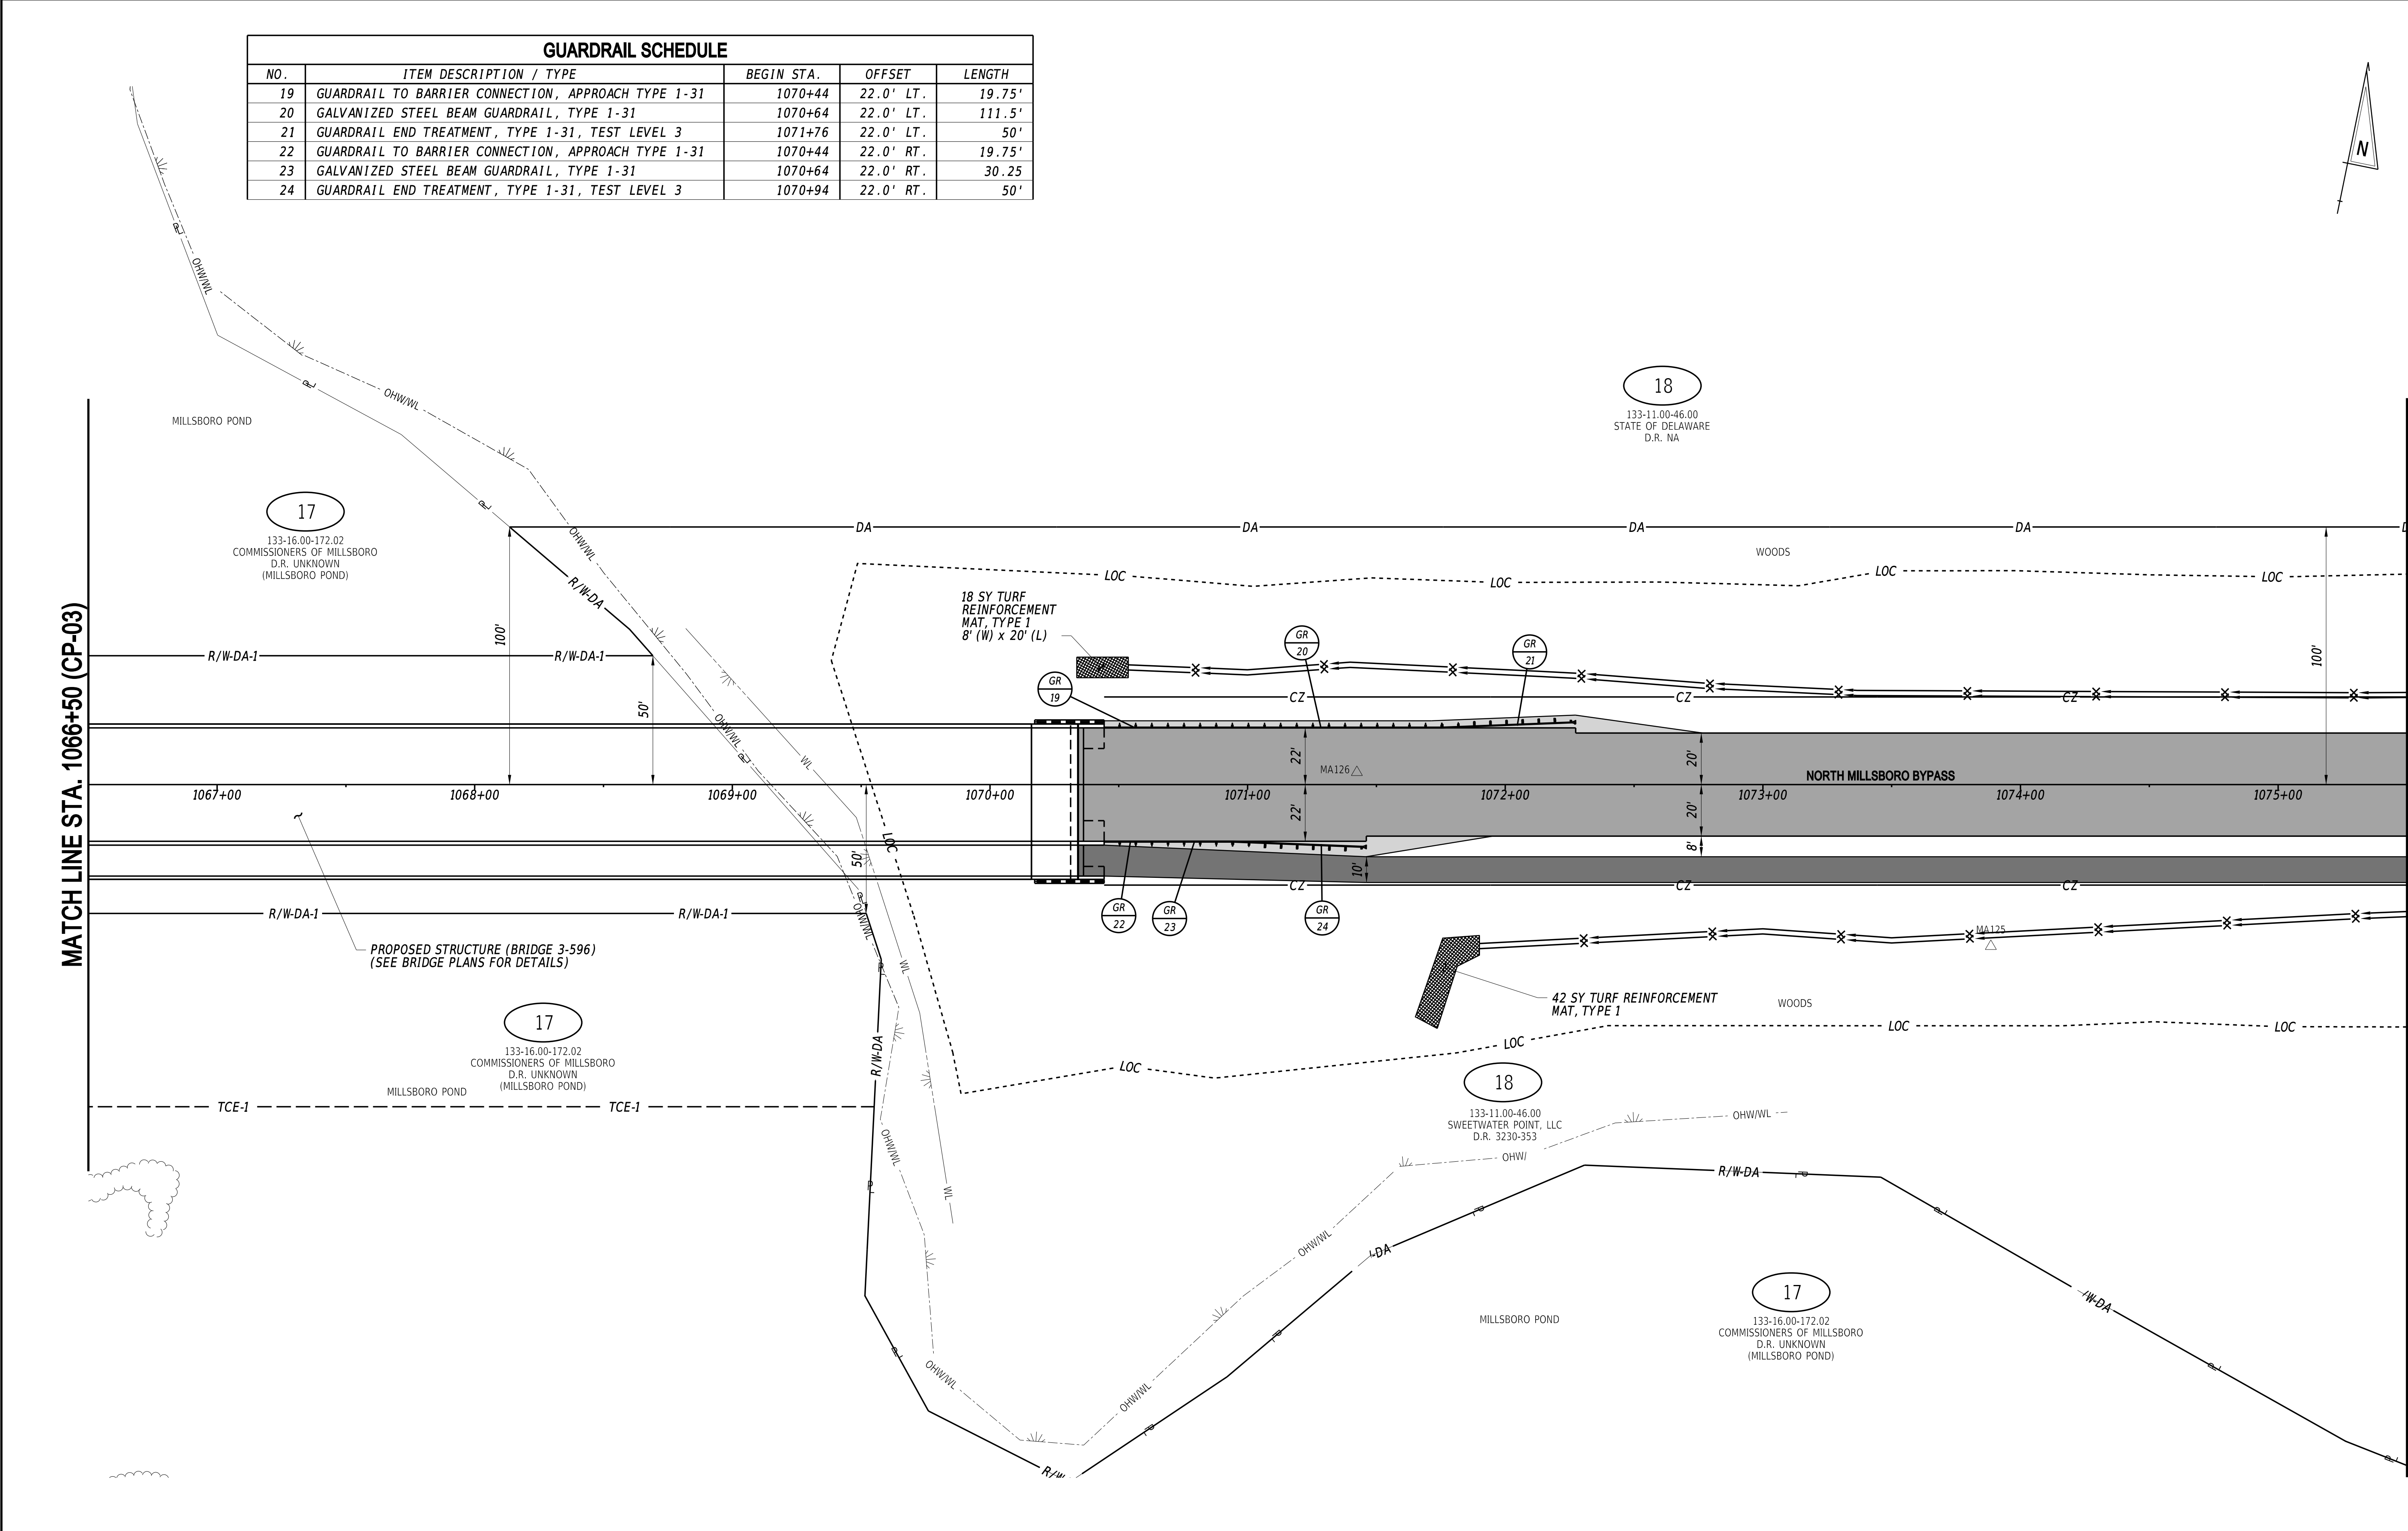

ADDENDA / REVISIONS

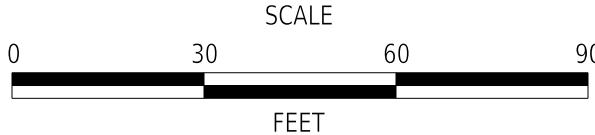

CM/GC,
NORTH MILLSBORO BYPASS,
US 113 TO SR 24

CONTRACT	BRIDGE NO.	3-596
T202112701	DESIGNED BY:	S. BEALL
COUNTY	CHECKED BY:	T. OLIVER
SUSSEX		

CONSTRUCTION PLAN

CP-04
SECTION
WRA
SHEET NO.
20


DRAINAGE PIPE SCHEDULE						
NO.	SIZE / TYPE	CLASS	LENGTH	SLOPE	INT. EL.	DIS. EL.
106	18" RCP	IV	73'	0.0050	21.25	20.82

FLARED END SECTION SCHEDULE			
NO.	SIZE / TYPE	SLOPE	SAFETY GRATE
106	18" RCP	0.0050	NO
107	18" RCP	0.0050	NO


RIPRAP SCHEDULE		
NO.	TYPE	AREA (SY)
107	R-4	14

GUARDRAIL SCHEDULE				
NO.	ITEM DESCRIPTION / TYPE	BEGIN STA.	OFFSET	LENGTH
25	GUARDRAIL END TREATMENT, TYPE 1-31, TEST LEVEL 3	1079+65	22.0' LT.	50'
26	GALVANIZED STEEL BEAM GUARDRAIL, TYPE 1-31	1080+16	22.0' LT.	30.25
27	GUARDRAIL TO BARRIER CONNECTION, APPROACH TYPE 1-31	1080+47	22.0' LT.	19.75'
28	GUARDRAIL END TREATMENT, TYPE 1-31, TEST LEVEL 3	1078+83	22.0' RT.	50'
29	GALVANIZED STEEL BEAM GUARDRAIL, TYPE 1-31	1079+35	22.0' RT.	111.5'
30	GUARDRAIL TO BARRIER CONNECTION, APPROACH TYPE 1-31	1080+47	22.0' RT.	19.75'

RIGHT-OF-WAY MONUMENT SCHEDULE					
NO.	TYPE	STATION	OFFSET	NORTHING	EASTING
1	CAPPED REBAR	1080+51.99	-100.00	219722.8555	690207.4182

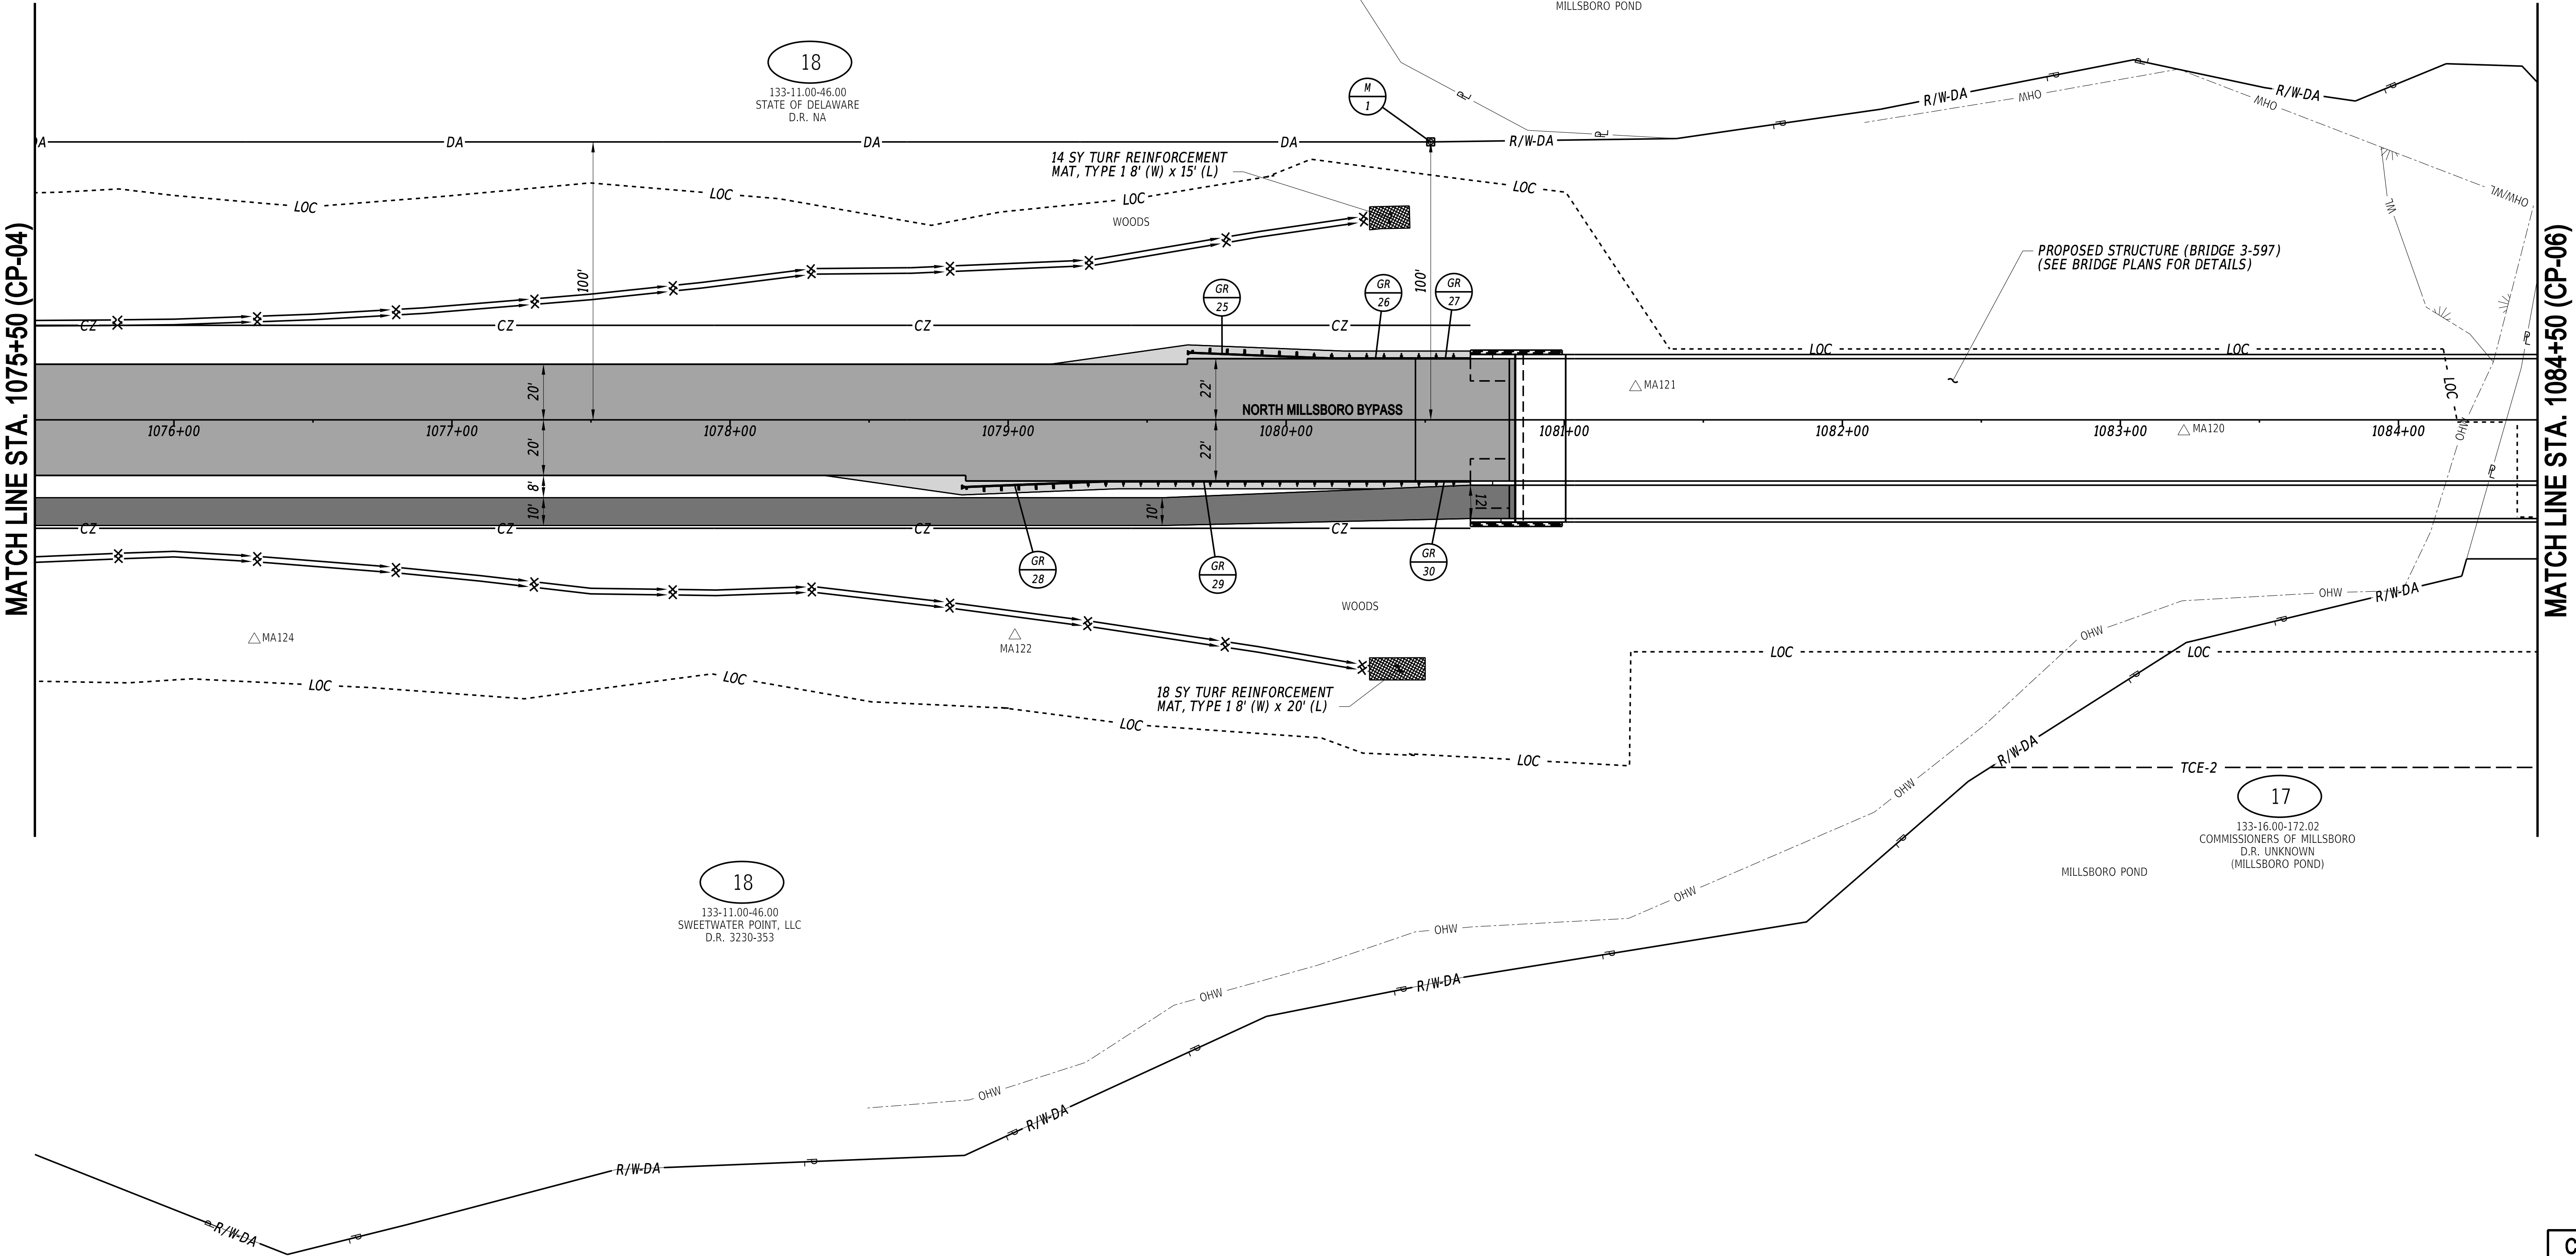

ADDENDA / REVISIONS

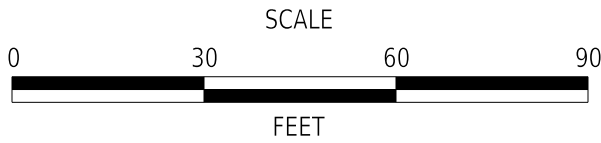

CM/GC,
NORTH MILLSBORO BYPASS,
US 113 TO SR 24

CONTRACT	BRIDGE NO.	3-597
T202112701	DESIGNED BY:	S. BEALL
COUNTY	CHECKED BY:	T. OLIVER
SUSSEX		

CONSTRUCTION PLAN

CP-05

SECTION
WRA
SHEET NO.
21


GUARDRAIL SCHEDULE				
NO.	ITEM DESCRIPTION / TYPE	BEGIN STA.	OFFSET	LENGTH
31	GUARDRAIL TO BARRIER CONNECTION, APPROACH TYPE 1-31	1090+32	22.0' LT.	19.75'
32	GALVANIZED STEEL BEAM GUARDRAIL, TYPE 1-31	1090+51	22.0' LT.	111.5'
33	GUARDRAIL END TREATMENT, TYPE 1-31, TEST LEVEL 3	1091+63	22.0' LT.	50'
34	GUARDRAIL TO BARRIER CONNECTION, APPROACH TYPE 1-31	1090+32	22.0' RT.	19.75'
35	GALVANIZED STEEL BEAM GUARDRAIL, TYPE 1-31	1090+51	22.0' RT.	30.25'
36	GUARDRAIL END TREATMENT, TYPE 1-31, TEST LEVEL 3	1090+82	22.0' RT.	50'

MATCH LINE STA. 1084+50 (CP-05)

MATCH LINE STA. 1093+50 (CP-07)

3/4/2022
6:13:34 PM
N:\132149-002\CADD\US 113 NM Bypass\CP06_NMBP.dgn

ADDENDA / REVISIONS

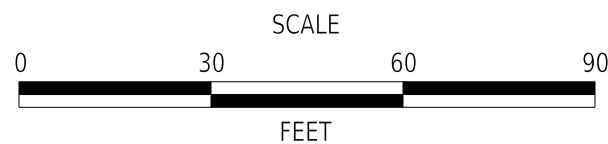

CM/GC,
NORTH MILLSBORO BYPASS,
US 113 TO SR 24

CONTRACT	BRIDGE NO.	3-597
T7202112701	DESIGNED BY:	S. BEALL
COUNTY	CHECKED BY:	T. OLIVER
SUSSEX		

CONSTRUCTION PLAN

CP-06

SECTION

WRA

SHEET NO.

22

DRAINAGE PIPE SCHEDULE						
NO.	SIZE / TYPE	CLASS	LENGTH	SLOPE	INT. EL.	DIS. EL.
109	24" RCP	IV	166'	0.0030	18.70	18.20
110	18" RCP	IV	95'	0.0050	20.05	19.57

FLARED END SECTION SCHEDULE			
NO.	SIZE / TYPE	SLOPE	SAFETY GRATE
108	24" RCP	0.0030	NO
109	24" RCP	0.0030	NO
110	18" RCP	0.0050	NO
111	18" RCP	0.0050	NO


RIPRAP SCHEDULE		
NO.	TYPE	AREA (SY)
108	R-4	5
109	R-4	14
110	R-4	5
111	R-4	14

MATCH LINE STA. 1093+50 (CP-06)

PARCEL 20 IS FULL ACQUISITION AND HAS BEEN IDENTIFIED AS A LOCATION FOR POTENTIAL BORROW. FINAL DRAINAGE AND GRADING WILL BE DEVELOPED AS BORROW NEEDS AND EXCAVATION DEPTH ARE AGREED UPON BETWEEN DELDOT AND THE CONTRACTOR.


MATCH LINE STA. 7014+00 (CP-17)

MATCH LINE STA. 1102+50 (CP-08)

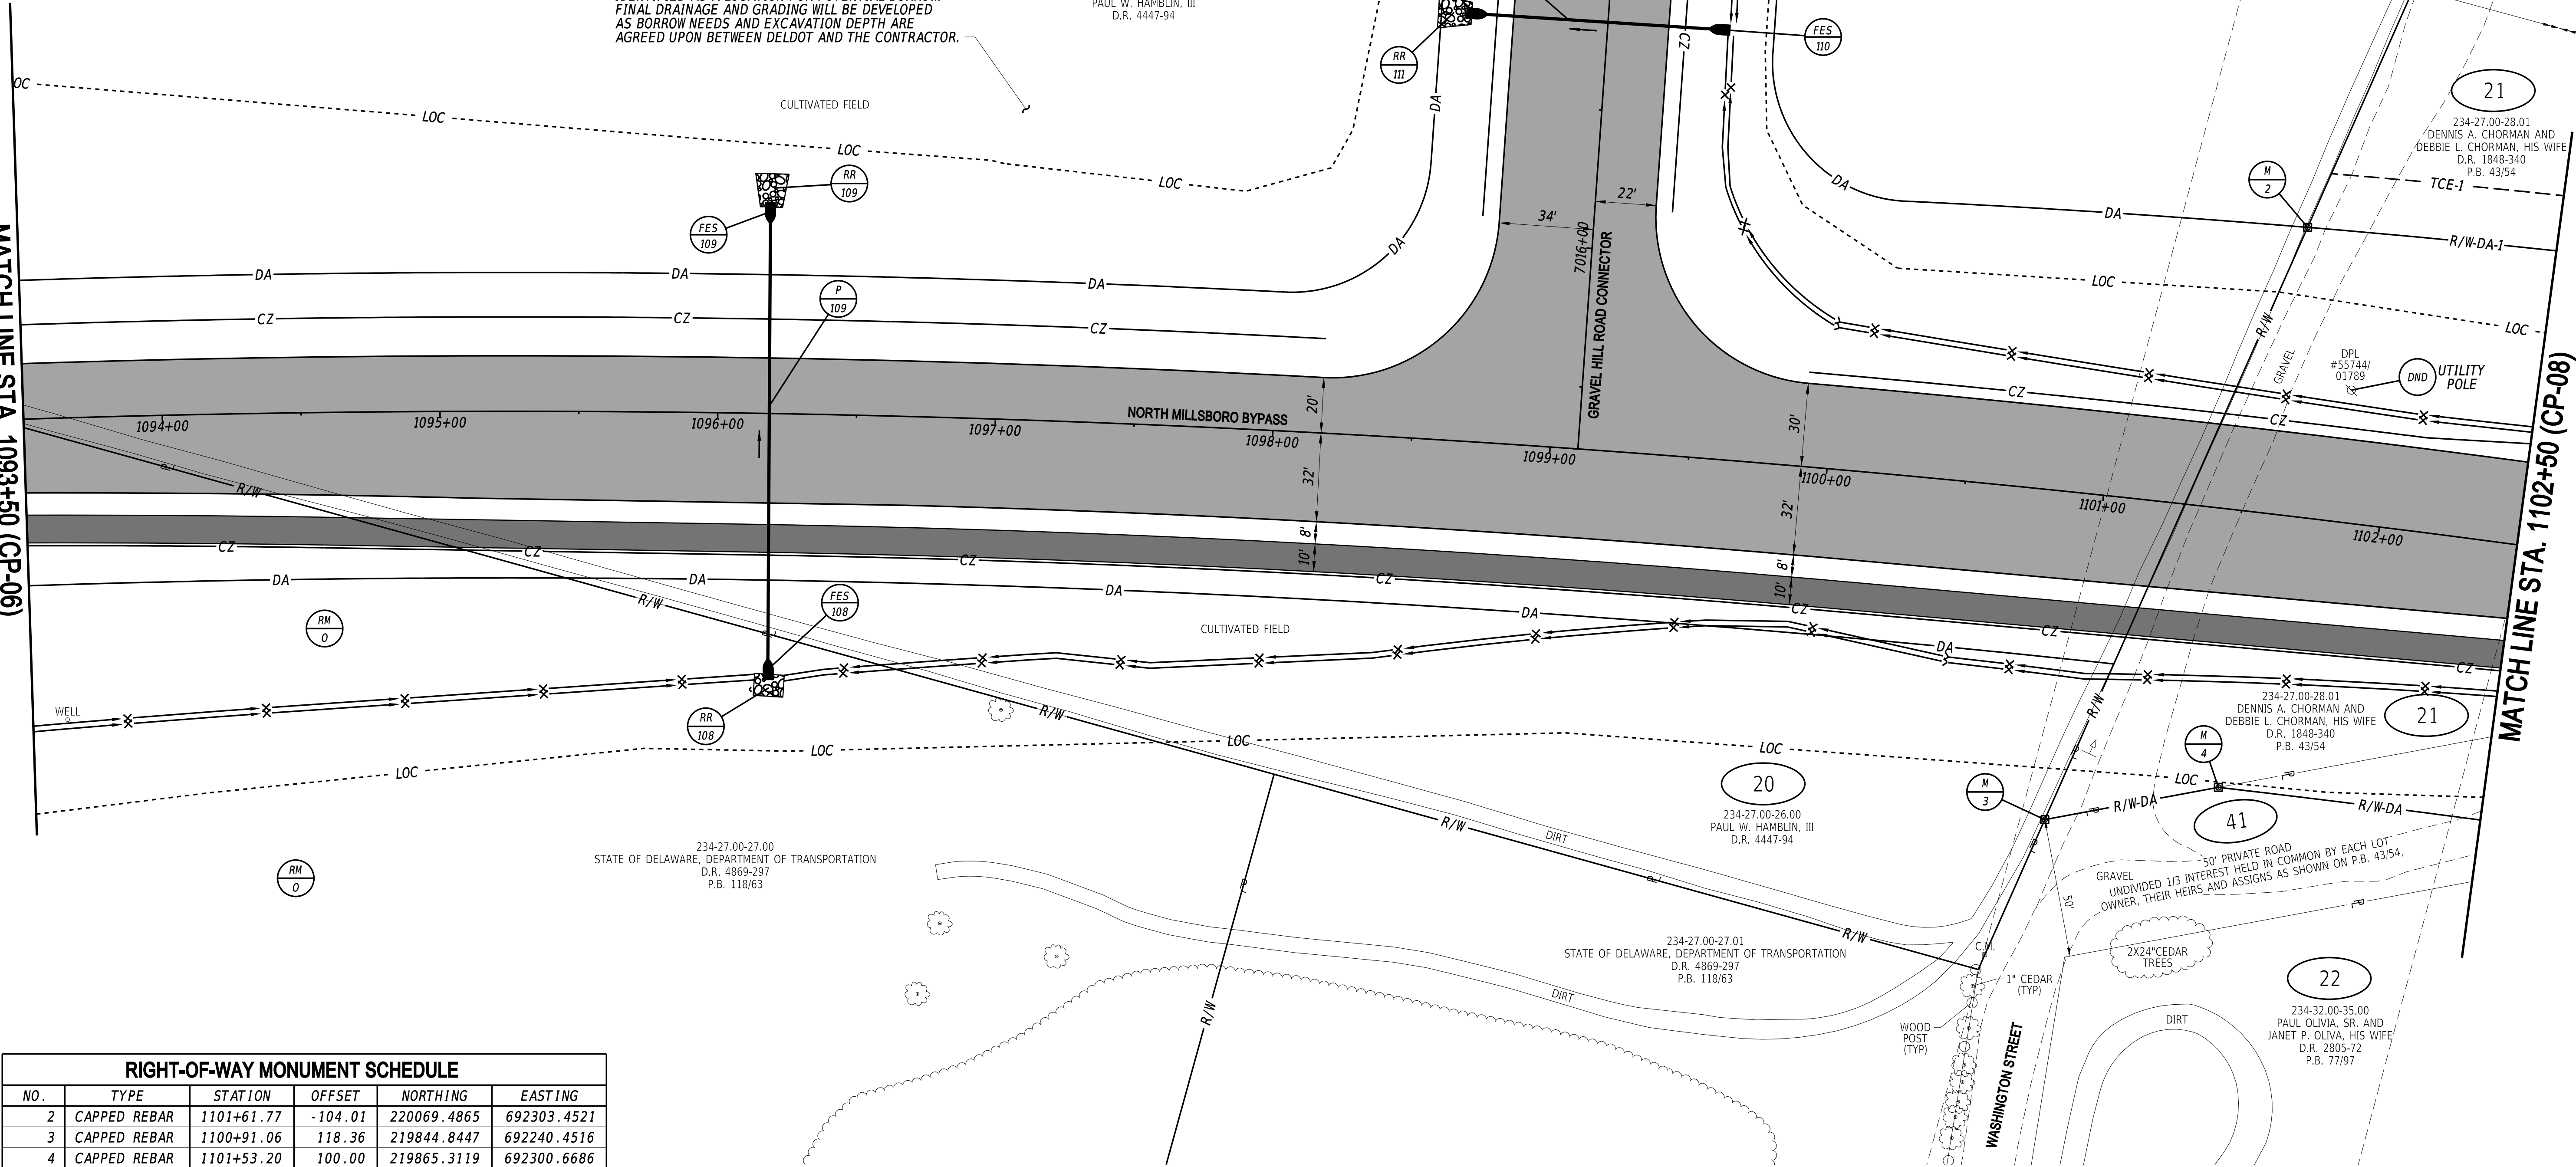

RIGHT-OF-WAY MONUMENT SCHEDULE					
NO.	TYPE	STATION	OFFSET	NORTHING	EASTING
2	CAPPED REBAR	1101+61.77	-104.01	220069.4865	692303.4521
3	CAPPED REBAR	1100+91.06	118.36	219844.8447	692240.4516
4	CAPPED REBAR	1101+53.20	100.00	219865.3119	692300.6686

ADDENDA / REVISIONS

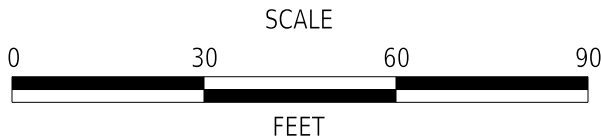

CM/GC,
NORTH MILLSBORO BYPASS,
US 113 TO SR 24

CONTRACT

T202112701

COUNTY

SUSSEX

BRIDGE NO.

N/A

DESIGNED BY: S. BEALL

CHECKED BY: T. OLIVER

CONSTRUCTION PLAN


CP-07

SECTION

WRA

SHEET NO.

23

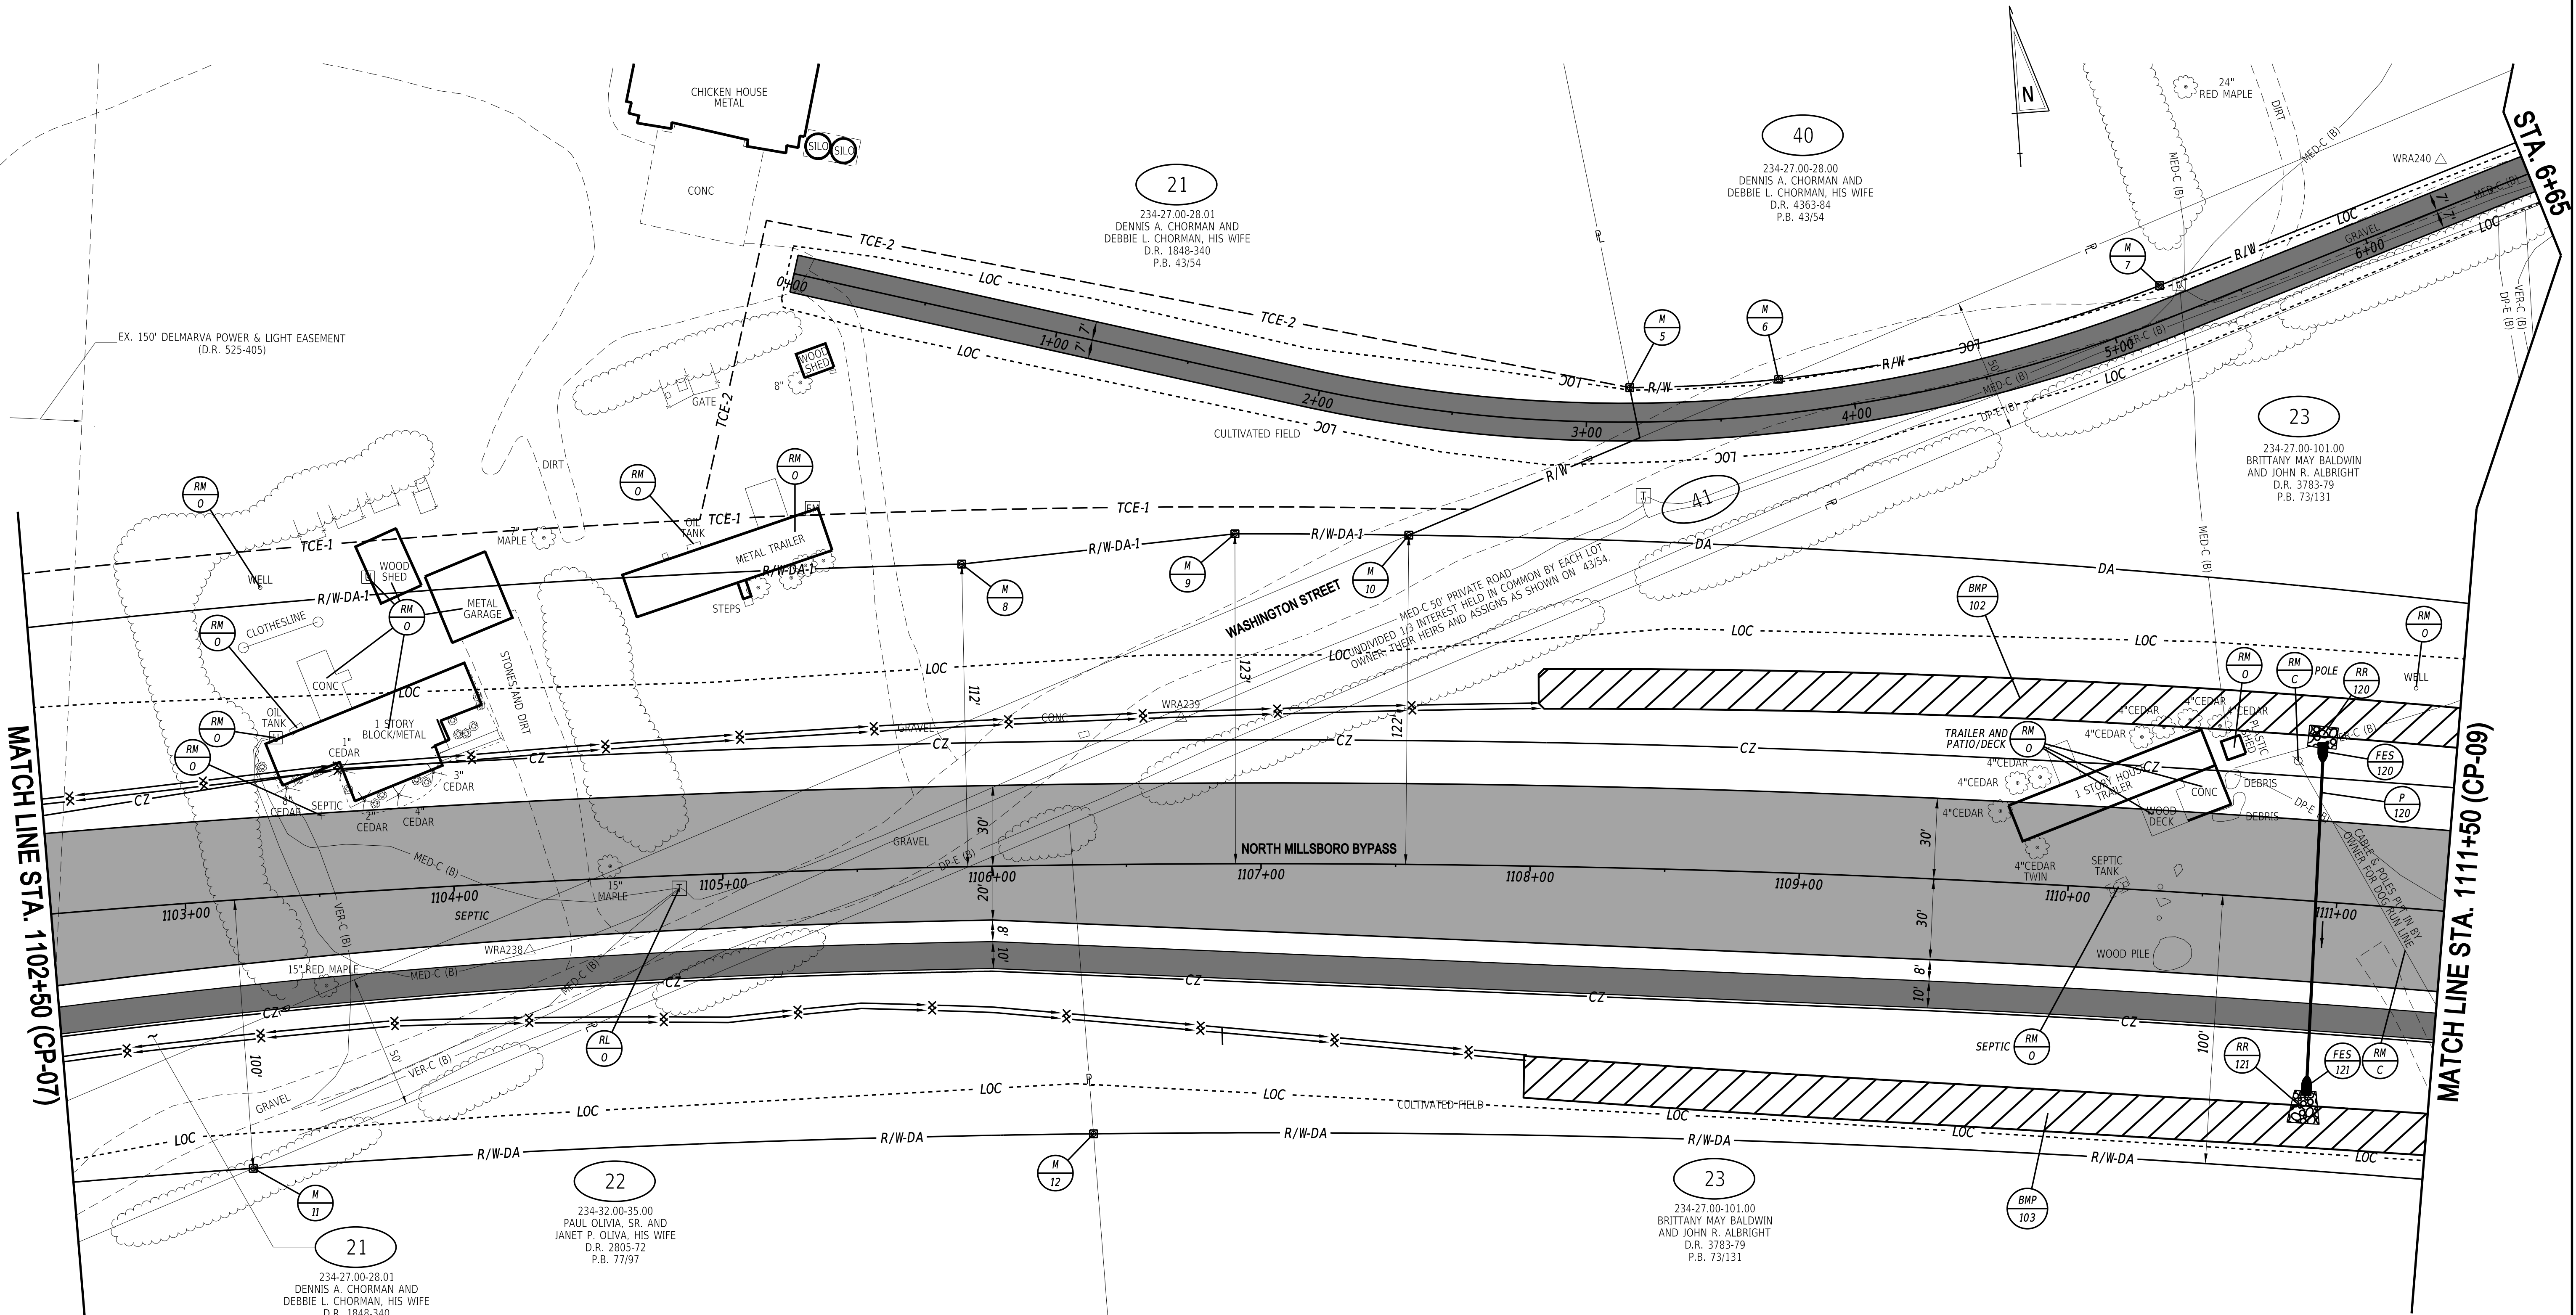

RIGHT-OF-WAY MONUMENT SCHEDULE					
NO.	TYPE	STATION	OFFSET	NORTHING	EASTING
5	CAPPED REBAR	3+16.10	-12.82	220120.4533	692993.4537
6	CAPPED REBAR	3+72.83	-12.84	220119.6059	693048.8314
7	CAPPED REBAR	5+22.53	-12.50	220144.2290	693192.5376
8	CAPPED REBAR	0+84.29	91.80	220072.7578	692741.2528
9	CAPPED REBAR	1+80.89	58.73	220076.7502	692843.2878
10	CAPPED REBAR	2+40.07	47.35	220071.6269	692907.6715
11	CAPPED REBAR	1103+18.29	100.00	219867.5774	692462.7048
12	CAPPED REBAR	1106+36.59	100.00	219858.0916	692774.9788


FLARED END SECTION SCHEDULE			
NO.	SIZE / TYPE	SLOPE	SAFETY GRATE
120	18" RCP	0.0035	NO
121	18" RCP	0.0035	NO

RIPRAP SCHEDULE		
NO.	TYPE	AREA (SY)
120	R-4	5
121	R-4	14

DRAINAGE PIPE SCHEDULE						
NO.	SIZE / TYPE	CLASS	LENGTH	SLOPE	INT. EL.	DIS. EL.
120	18" RCP	IV	131'	0.0035	19.90	19.45

DELDOT SWM FACILITY SCHEDULE		
NO.	TYPE / DESCRIPTION	LOCATION
102	INFILTRATION TRENCH	STA. 1108+00 LT. TO STA. 1114+50 LT.
103	INFILTRATION TRENCH	STA. 1108+00 RT. TO STA. 1114+50 RT.

ADDENDA / REVISIONS

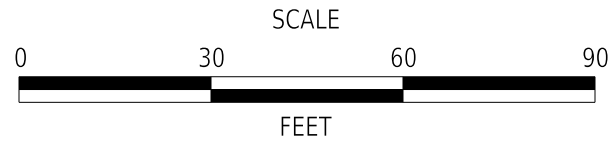

CM/GC,
NORTH MILLSBORO BYPASS,
US 113 TO SR 24


CONTRACT	BRIDGE NO.	N/A
T202112701	DESIGNED BY:	S. BEALL
COUNTY	CHECKED BY:	T. OLIVER
SUSSEX		

CONSTRUCTION PLAN


CP-08
SECTION
WRA
SHEET NO.
24

DELDOT SWM FACILITY SCHEDULE		
NO.	TYPE / DESCRIPTION	LOCATION
104	INFILTRATION TRENCH	STA. 1118+00 RT. TO STA. 1120+00 RT.

RIGHT-OF-WAY MONUMENT SCHEDULE					
NO.	TYPE	STATION	OFFSET	NORTHING	EASTING
13	CAPPED REBAR	7+92.00	-12.50	220202.7116	693456.7486
14	CAPPED REBAR	7+12.04	15.00	220167.0698	693380.0702
15	CAPPED REBAR	8+5.73	15.00	220176.9531	693474.8845
16	CAPPED REBAR	1114+44.56	-131.48	219978.9634	693608.0887
17	CAPPED REBAR	1119+40.47	-102.62	219824.1449	694091.0804
18	CAPPED REBAR	1112+02.10	100.00	219796.3767	693326.4227

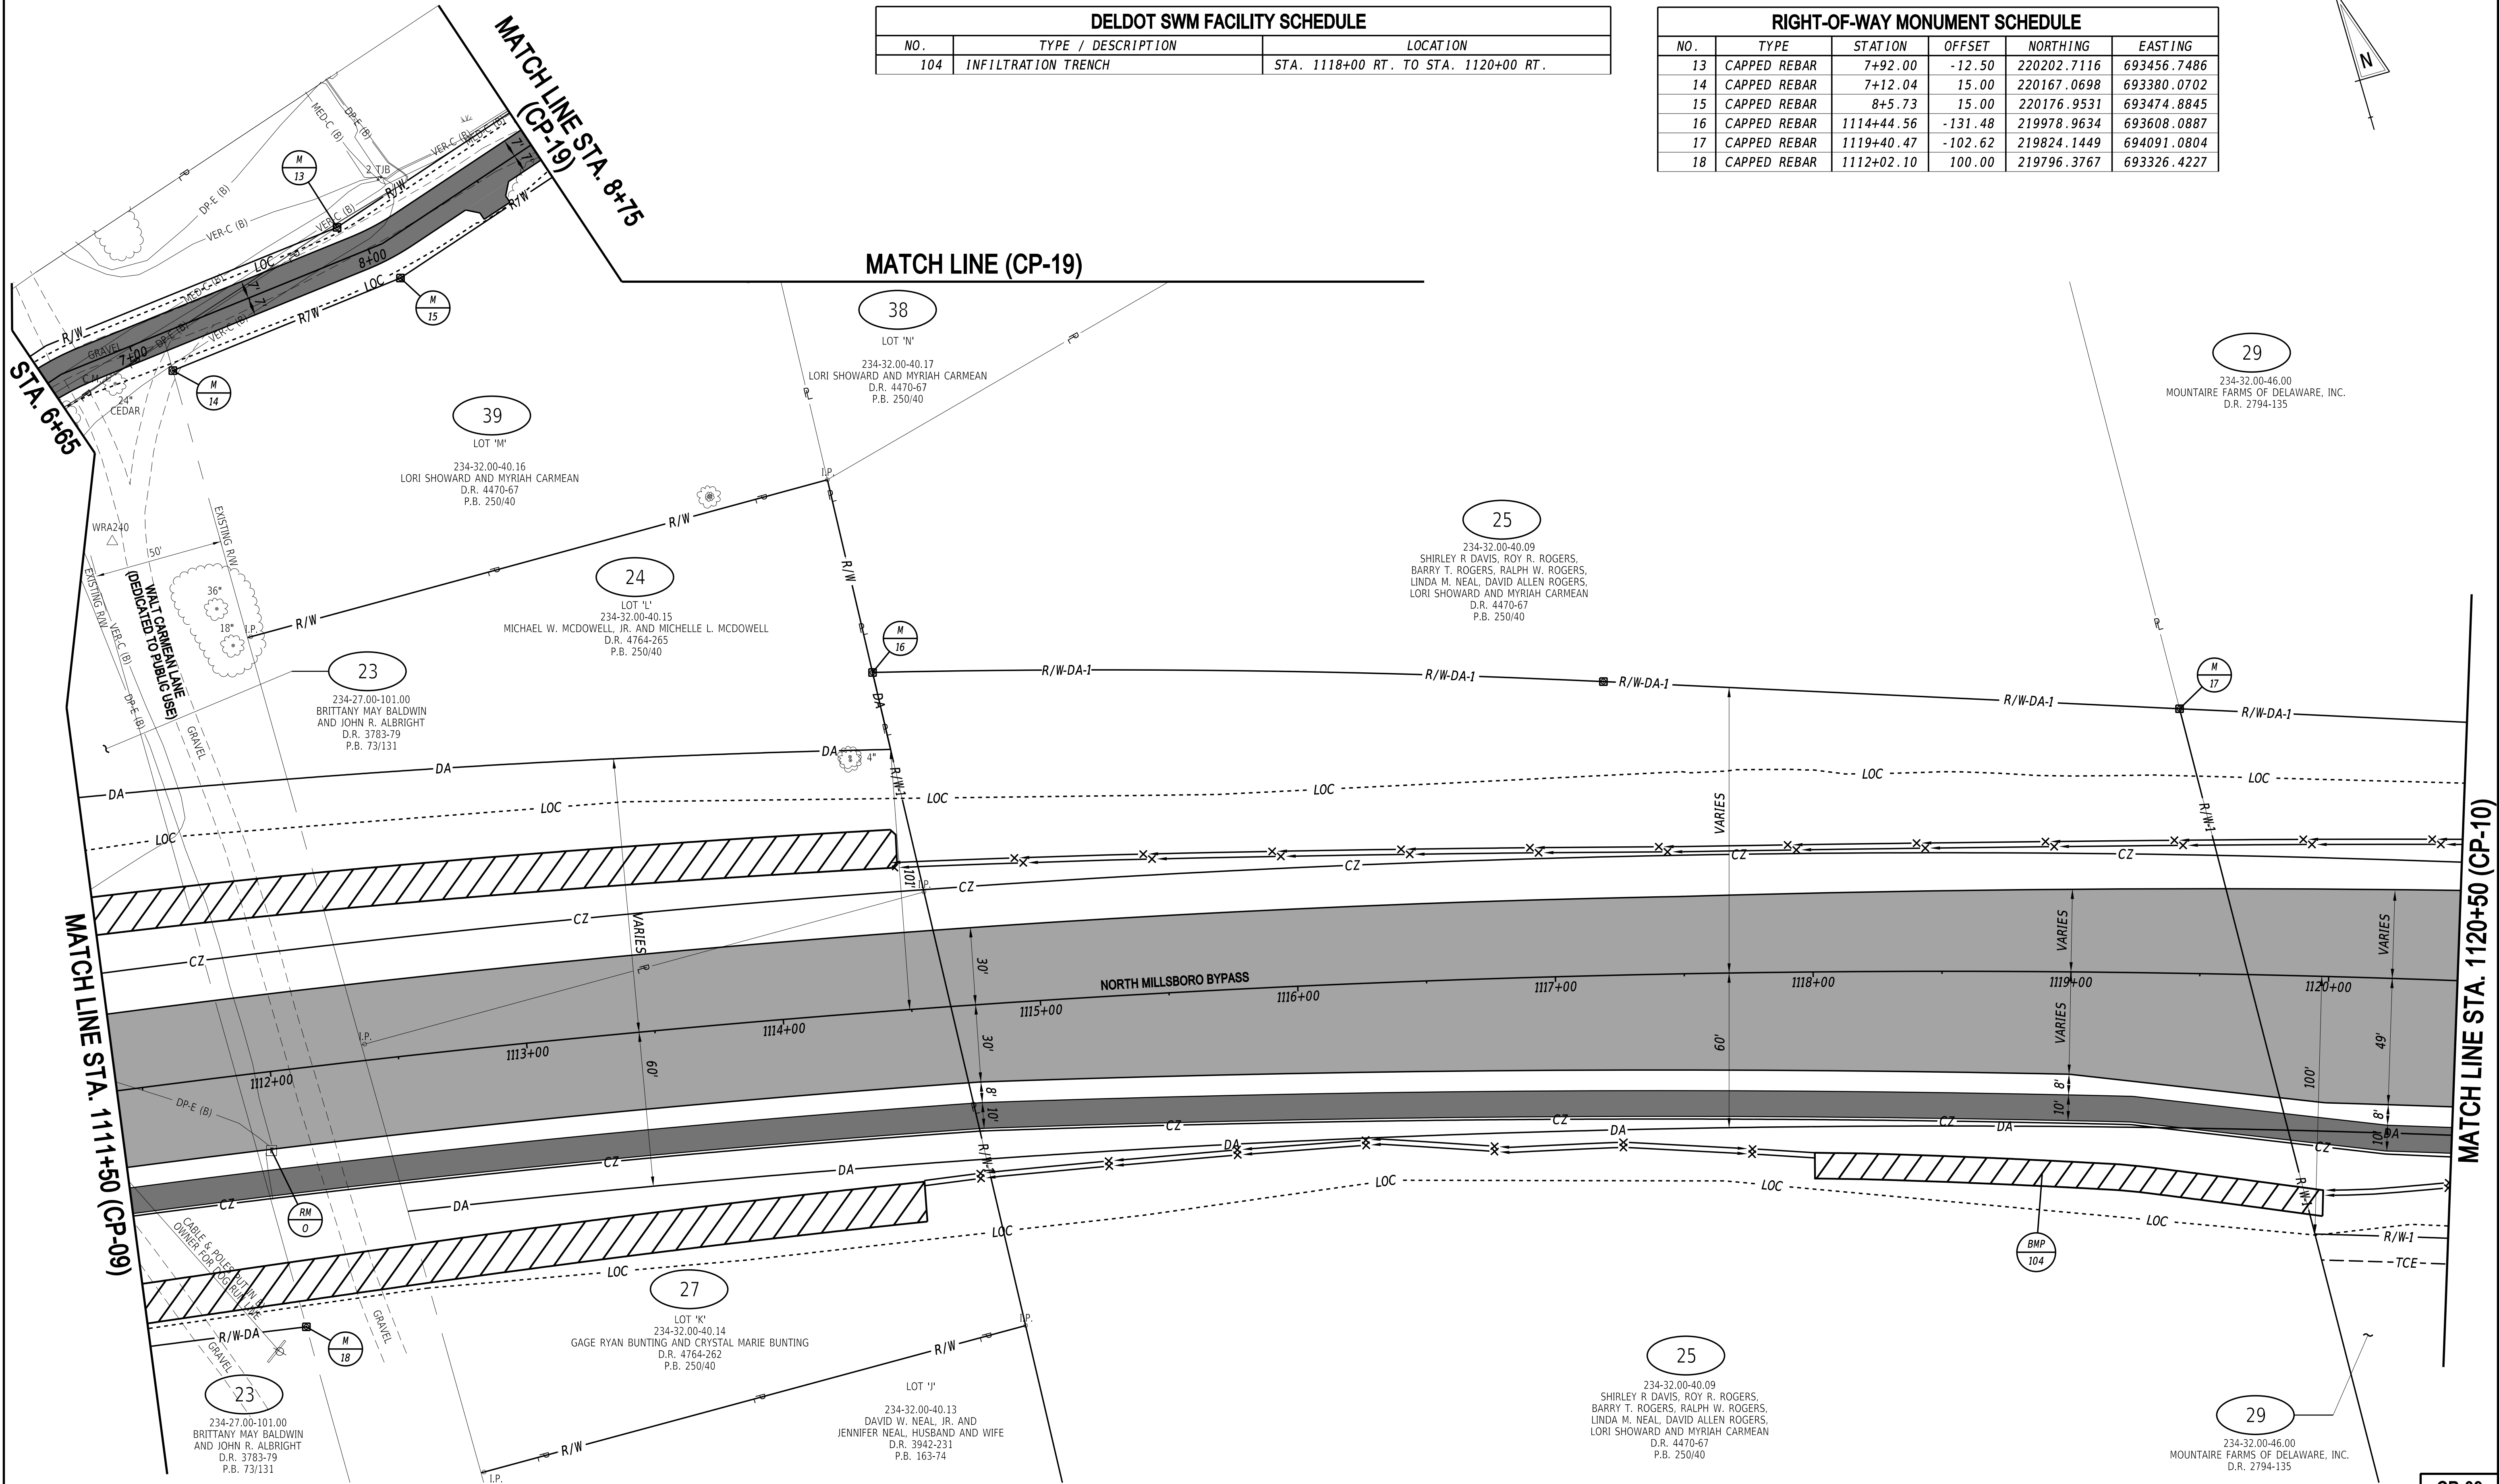

ADDENDA / REVISIONS	

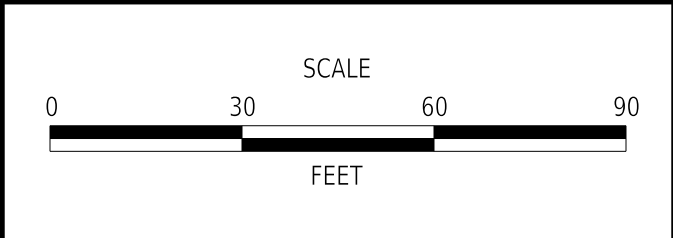

CM/GC,
NORTH MILLSBORO BYPASS,
US 113 TO SR 24

CONTRACT	BRIDGE NO.	N/A
T202112701	DESIGNED BY:	S. BEALL
COUNTY	CHECKED BY:	T. OLIVER
SUSSEX		

CONSTRUCTION PLAN	
SECTION	WRA
SHEET NO.	25

CP-09
SECTION
WRA
SHEET NO.
25

3/4/2022
6:13:37 PM
N:\132149-002\CADD\US 113 NM Bypass\CP09_NMBP.dgn

DRAINAGE PIPE SCHEDULE						
NO.	SIZE / TYPE	CLASS	LENGTH	SLOPE	INT. EL.	DIS. EL.
132	18" RCP	IV	150'	0.0025	20.53	20.16
133	18" RCP	IV	160'	0.0025	20.15	19.75
134	18" RCP	IV	139	0.0031	20.43	20.00

FLARED END SECTION SCHEDULE			
NO.	SIZE / TYPE	SLOPE	SAFETY GRATE
132	18" RCP	0.0025	YES
133	18" RCP	0.0025	YES
134	18" RCP	0.0031	NO
135	18" RCP	0.0031	NO

RIPRAP SCHEDULE		
NO.	TYPE	AREA (SY)
131	R-4	4
133	R-4	13
134	R-4	4
135	R-4	13

MANHOLE SCHEDULE					
NO.	STATION	OFFSET	TYPE/SIZE	T.G. EL.	INVERT EL.
133	9010+63.05	109.11'	48" x 24"	25.47	20.15

DELDOT SWM FACILITY SCHEDULE		
NO.	TYPE / DESCRIPTION	LOCATION
105	INFILTRATION BASIN	STA. 1127+09 RT. TO STA. 1132+50 RT.

- NOTES:
1. SEE SHEETS 90-92 FOR SWM RISER STRUCTURE AND SWM BASIN DETAILS.
2. CONTRACTOR TO USE CLASS A BEDDING, SEE SHEETS 90-92 FOR SWM DETAILS.

MATCH LINE STA. 1120+50 (CP-09)


MATCH LINE STA. 1129+50 (CP-11)

RIGHT-OF-WAY MONUMENT SCHEDULE					
NO.	TYPE	STATION	OFFSET	NORTHING	EASTING
19	CAPPED REBAR	9013+91.17	-100.00	219702.8540	694445.7411
20	CAPPED REBAR	1126+33.75	-100.00	219604.8142	694732.4143
21	CAPPED REBAR	1121+07.84	110.00	219570.2730	694184.4476
22	CAPPED REBAR	9011+82.90	-60.00	219490.7900	694447.7630
23	CAPPED REBAR	9010+83.83	-60.00	219393.3288	694447.7630

ROADWAY CORE SCHEDULE				
NO.	STATION	OFFSET	DESCRIPTION	
PC-9	1126+46.35	7.4' RT.	5.25" HMA / 1" ST / ORIGINAL	
PC-9	1126+46.35	7.4' RT.	5.25" HMA / 1" ST / ORIGINAL	

3/4/2022 6:13:38 PM N:\132149-002\CADD\US 113 NM Bypass\CP10_NMBP.dgn

ADDENDA / REVISIONS

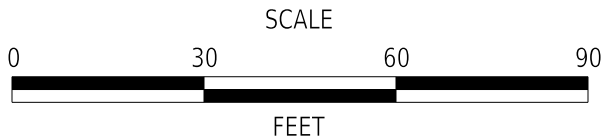

CM/GC,
NORTH MILLSBORO BYPASS,
US 113 TO SR 24

CONTRACT	BRIDGE NO.	N/A
T202112701	DESIGNED BY:	S. BEALL
COUNTY	CHECKED BY:	T. OLIVER
SUSSEX		

CONSTRUCTION PLAN

CP-10

SECTION

WRA

SHEET NO.

26

DRAINAGE INLET SCHEDULE						
NO.	STATION	OFFSET	BOX SIZE	GRATE	T.G. EL.	INV. EL.
136	1132+32.08	120' RT.	48" x 30"	2	25.06	21.31

NOTES:


1. SEE SHEETS XX-XX FOR SWM RISER STRUCTURE AND SWM BASIN DETAILS.
2. CONTRACTOR TO USE CLASS A BEDDING, SEE SHEETS XX-XX FOR SWM DETAILS.

DRAINAGE PIPE SCHEDULE						
NO.	SIZE / TYPE	CLASS	LENGTH	SLOPE	INT. EL.	DIS. EL.
136	24" RCP	IV	146'	0.0030	19.87	19.43

FLARED END SECTION SCHEDULE			
NO.	SIZE / TYPE	SLOPE	SAFETY GRATE
137	24" RCP	0.0030	NO
138	18" RCP	0.0030	NO


RIPRAP SCHEDULE		
NO.	TYPE	AREA (SY)
137	R-4	25
138	R-4	5

RIGHT-OF-WAY MONUMENT SCHEDULE					
NO.	TYPE	STATION	OFFSET	NORTHING	EASTING
24	CAPPED REBAR	1135+68.38	-100.00	219302.3767	695616.7570

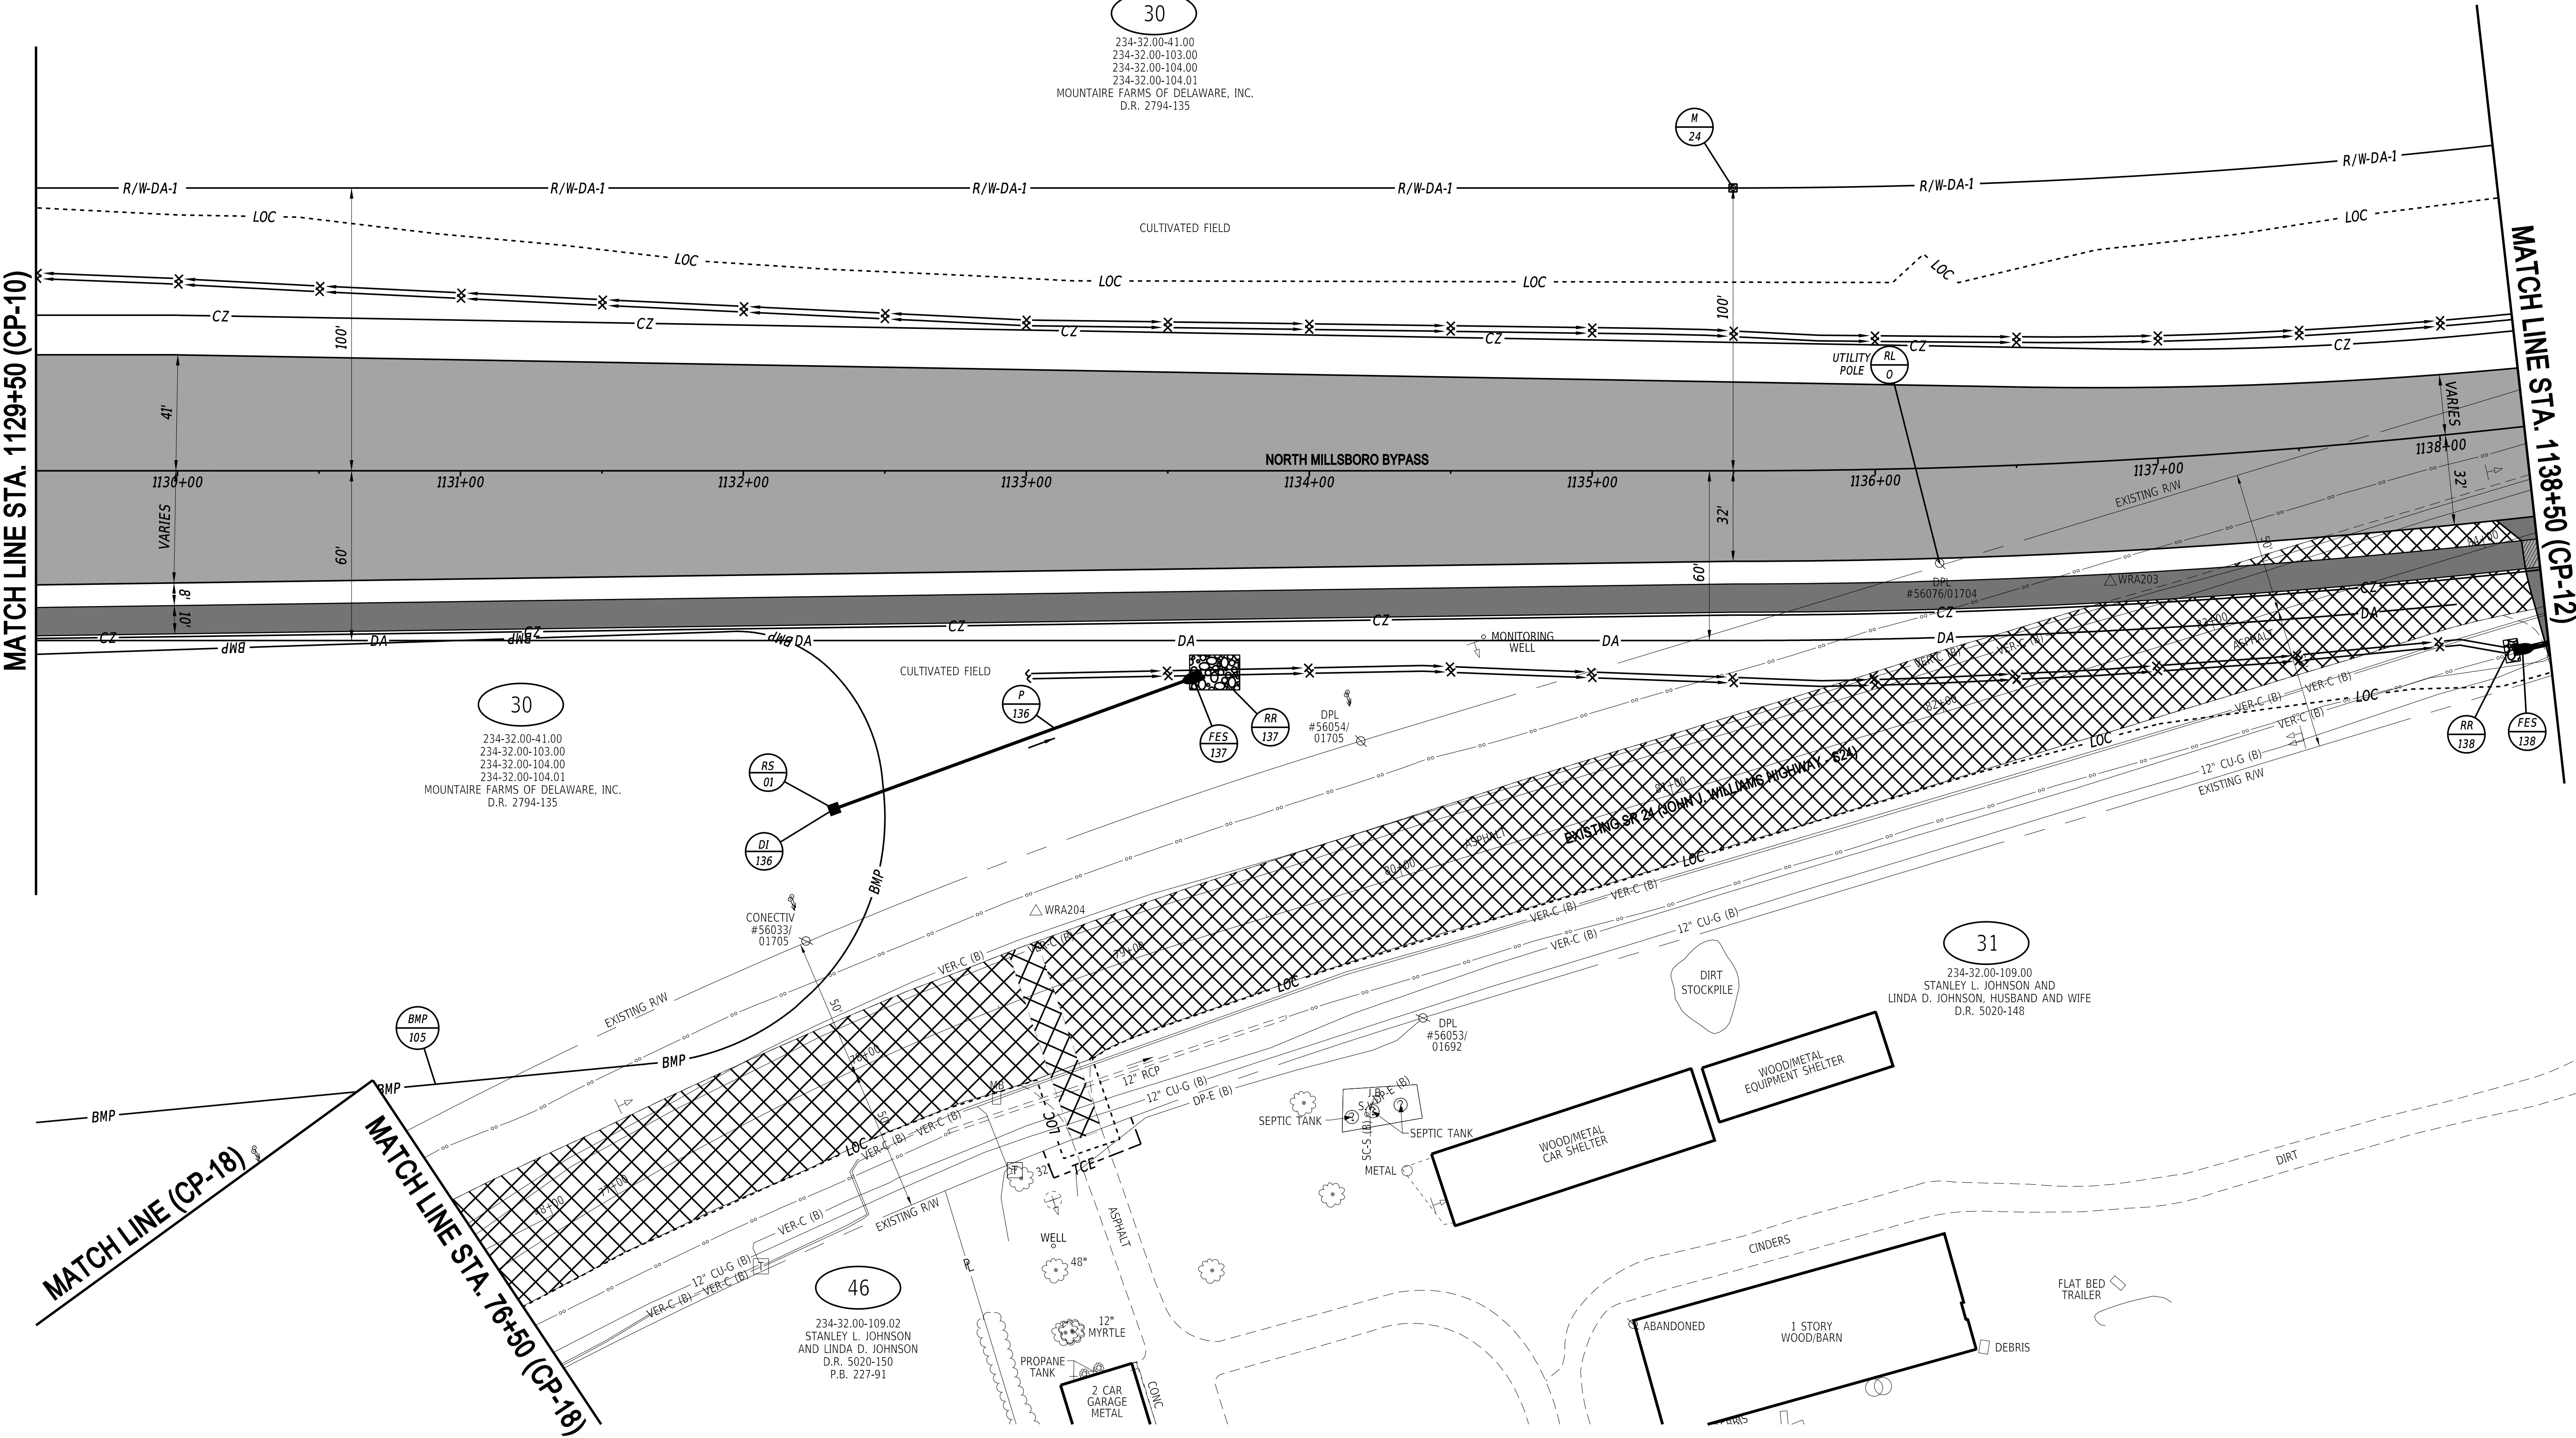

3/4/2022 6:13:39 PM N:\132149-002\CADD\US 113 NM Bypass\CP11_NMBP.dgn

ADDENDA / REVISIONS	

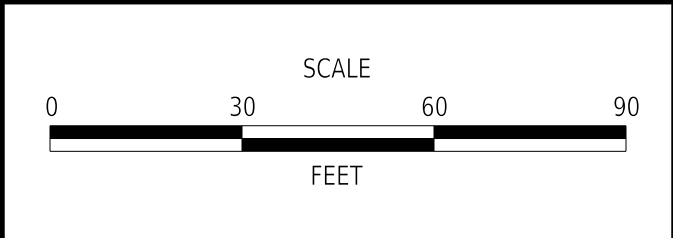

CM/GC,
NORTH MILLSBORO BYPASS,
US 113 TO SR 24

CONTRACT	BRIDGE NO.	N/A
T202112701	DESIGNED BY:	S. BEALL
COUNTY	CHECKED BY:	T. OLIVER
SUSSEX		

CONSTRUCTION PLAN

CP-11
SECTION
WRA
SHEET NO.
27

DRAINAGE PIPE SCHEDULE						
NO.	SIZE / TYPE	CLASS	LENGTH	SLOPE	INT. EL.	DIS. EL.
138	18" RCP	IV	204'	0.0046	18.00	17.06
140	18" RCP	IV	82'	0.0058	17.48	17.00
151	18" RCP	IV	12'	0.0046	17.06	17.00


FLARED END SECTION SCHEDULE			
NO.	SIZE / TYPE	SLOPE	SAFETY GRATE
139	18" RCP	0.0050	NO
140	18" RCP	0.0058	NO
141	18" RCP	0.0058	NO

RIPRAP SCHEDULE		
NO.	TYPE	AREA (SY)
139	R-4	14
140	R-4	5
141	R-4	14

ROADWAY CORE SCHEDULE			
NO.	STATION	OFFSET	DESCRIPTION
PC-10	1143+06.91	15.7' LT.	8.5" HMA / 8.5" PCC / 6+" FILL
PC-11	1143+06.91	8.0' LT.	8" HMA / ORIGINAL


DELDOT SWM FACILITY SCHEDULE		
NO.	TYPE / DESCRIPTION	LOCATION
106	INFILTRATION TRENCH	STA. 1140+30 LT. TO STA. 1142+50 LT.
107	INFILTRATION TRENCH	STA. 1141+50 RT. TO STA. 1142+00 RT.

MANHOLE SCHEDULE					
NO.	STATION	OFFSET	TYPE/SIZE	T.G. EL.	INVERT EL.
150	1140+21.15	62.65 RT.	48" x 30"	20.50	17.06

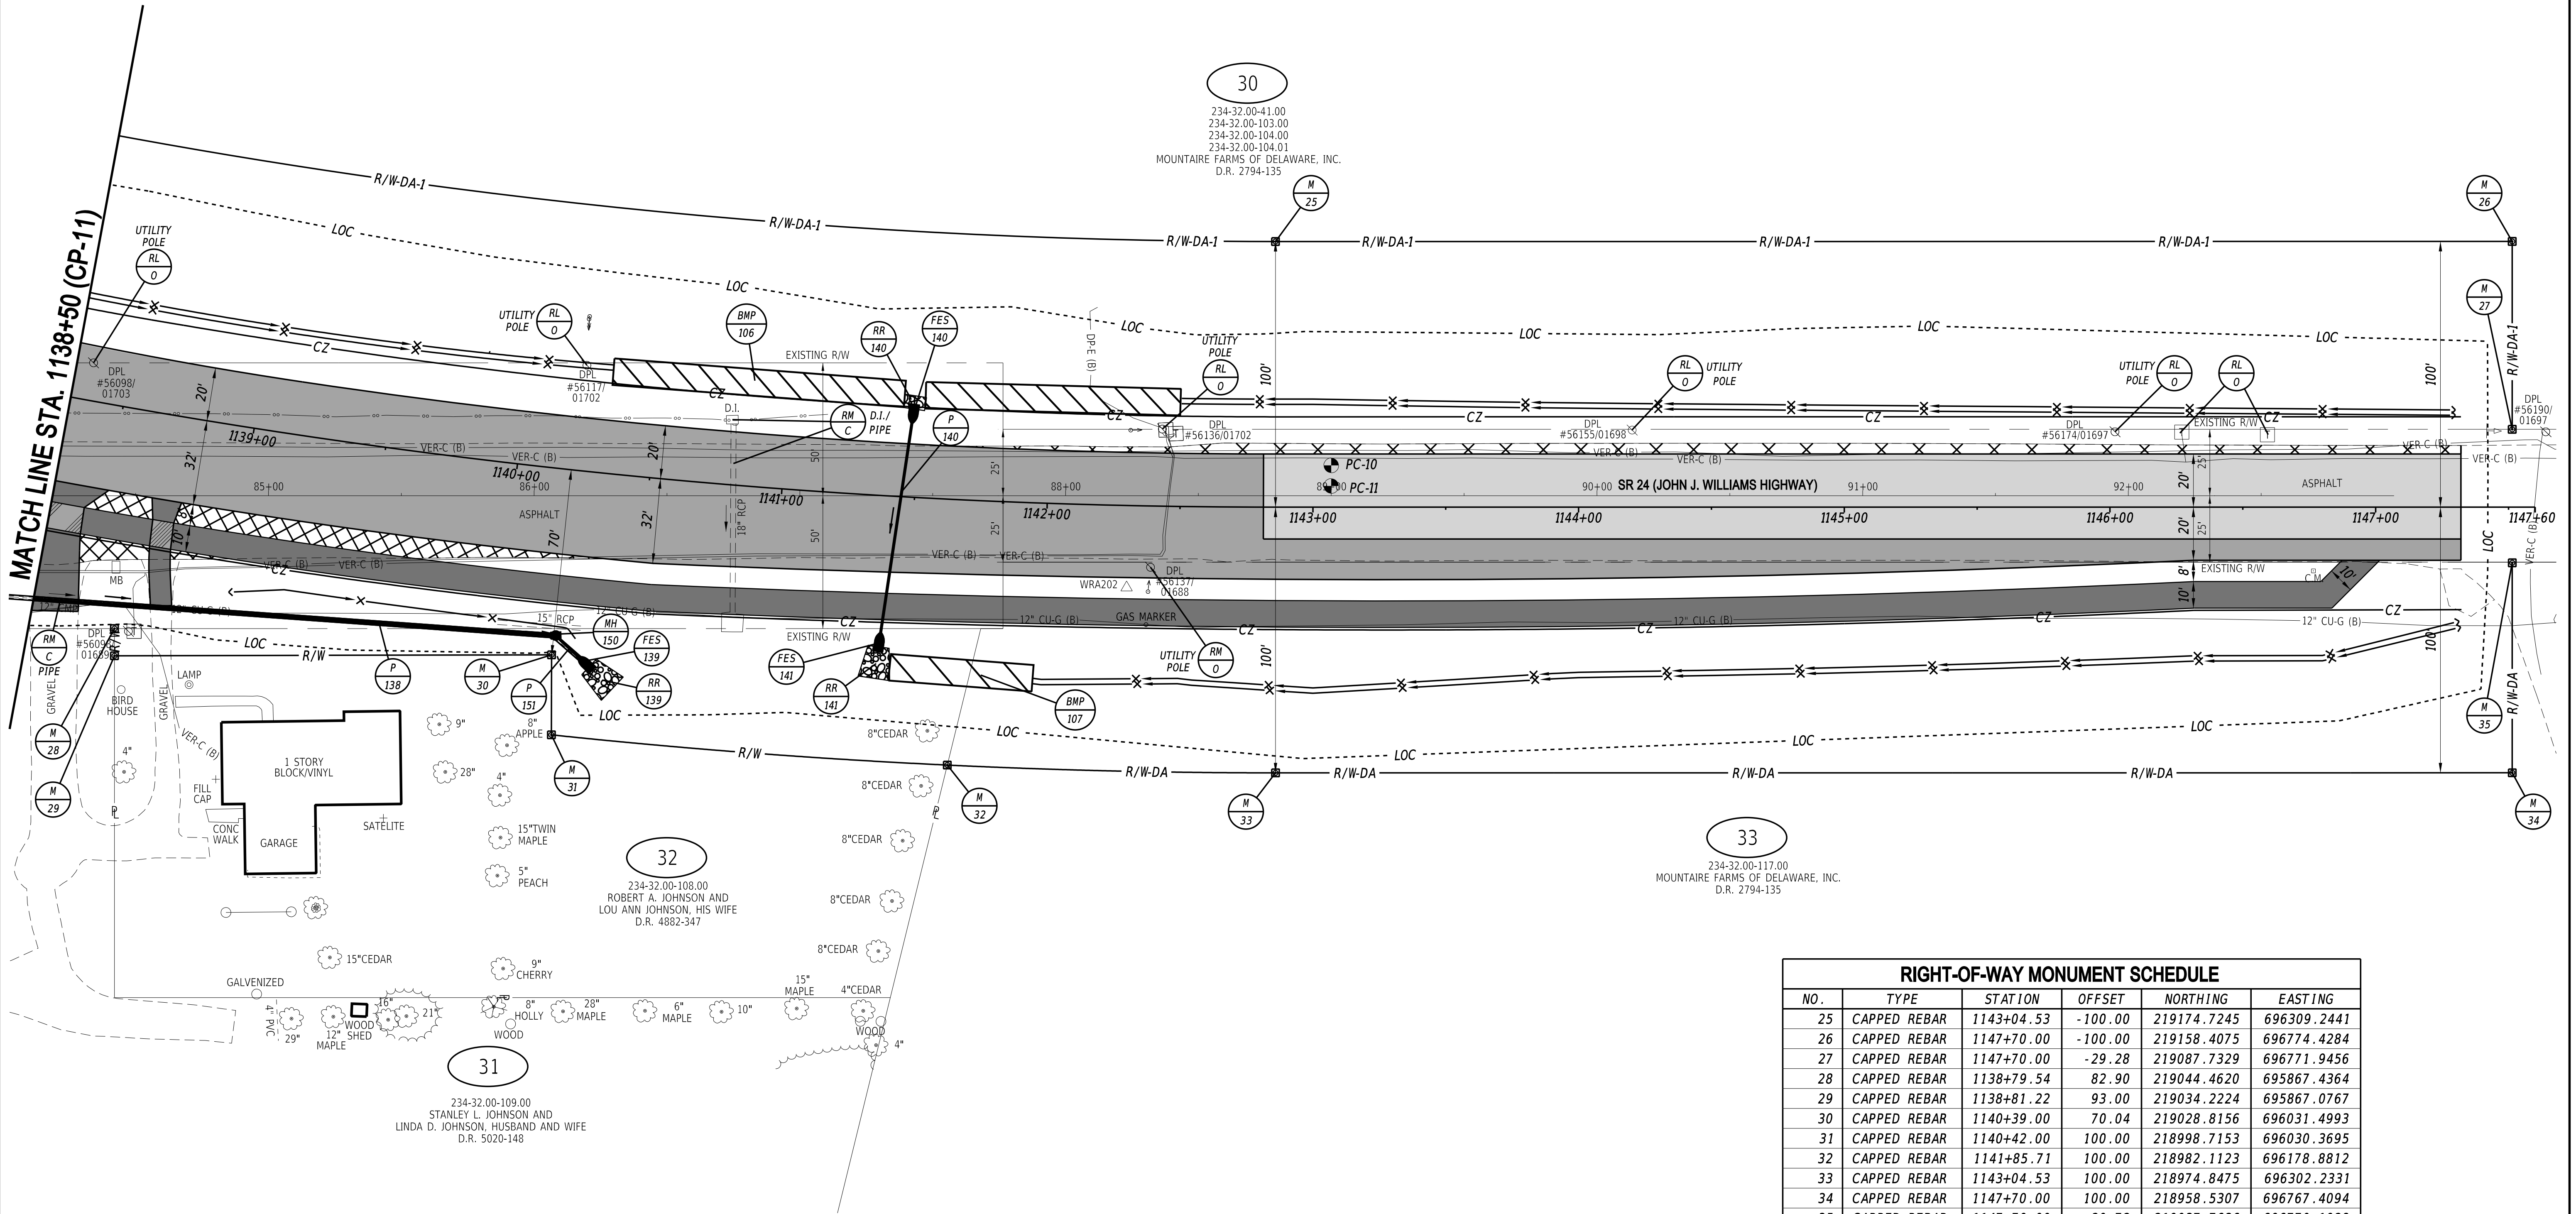

RIGHT-OF-WAY MONUMENT SCHEDULE					
NO.	TYPE	STATION	OFFSET	NORTHING	EASTING
25	CAPPED REBAR	1143+04.53	-100.00	219174.7245	696309.2441
26	CAPPED REBAR	1147+70.00	-100.00	219158.4075	696774.4284
27	CAPPED REBAR	1147+70.00	-29.28	219087.7329	696771.9456
28	CAPPED REBAR	1138+79.54	82.90	219044.4620	695867.4364
29	CAPPED REBAR	1138+81.22	93.00	219034.2224	695867.0767
30	CAPPED REBAR	1140+39.00	70.04	219028.8156	696031.4993
31	CAPPED REBAR	1140+42.00	100.00	218998.7153	696030.3695
32	CAPPED REBAR	1141+85.71	100.00	218982.1123	696178.8812
33	CAPPED REBAR	1143+04.53	100.00	218974.8475	696302.2331
34	CAPPED REBAR	1147+70.00	100.00	218958.5307	696767.4094
35	CAPPED REBAR	1147+70.00	20.72	219037.7636	696770.1928

ADDENDA / REVISIONS

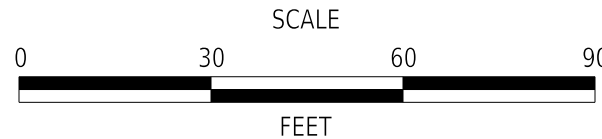

CM/GC,
NORTH MILLSBORO BYPASS,
US 113 TO SR 24

CONTRACT	BRIDGE NO.	N/A
T202112701	DESIGNED BY:	S. BEALL
COUNTY	CHECKED BY:	T. OLIVER
SUSSEX		

CONSTRUCTION PLAN


CP-12

SECTION

WRA

SHEET NO.

28

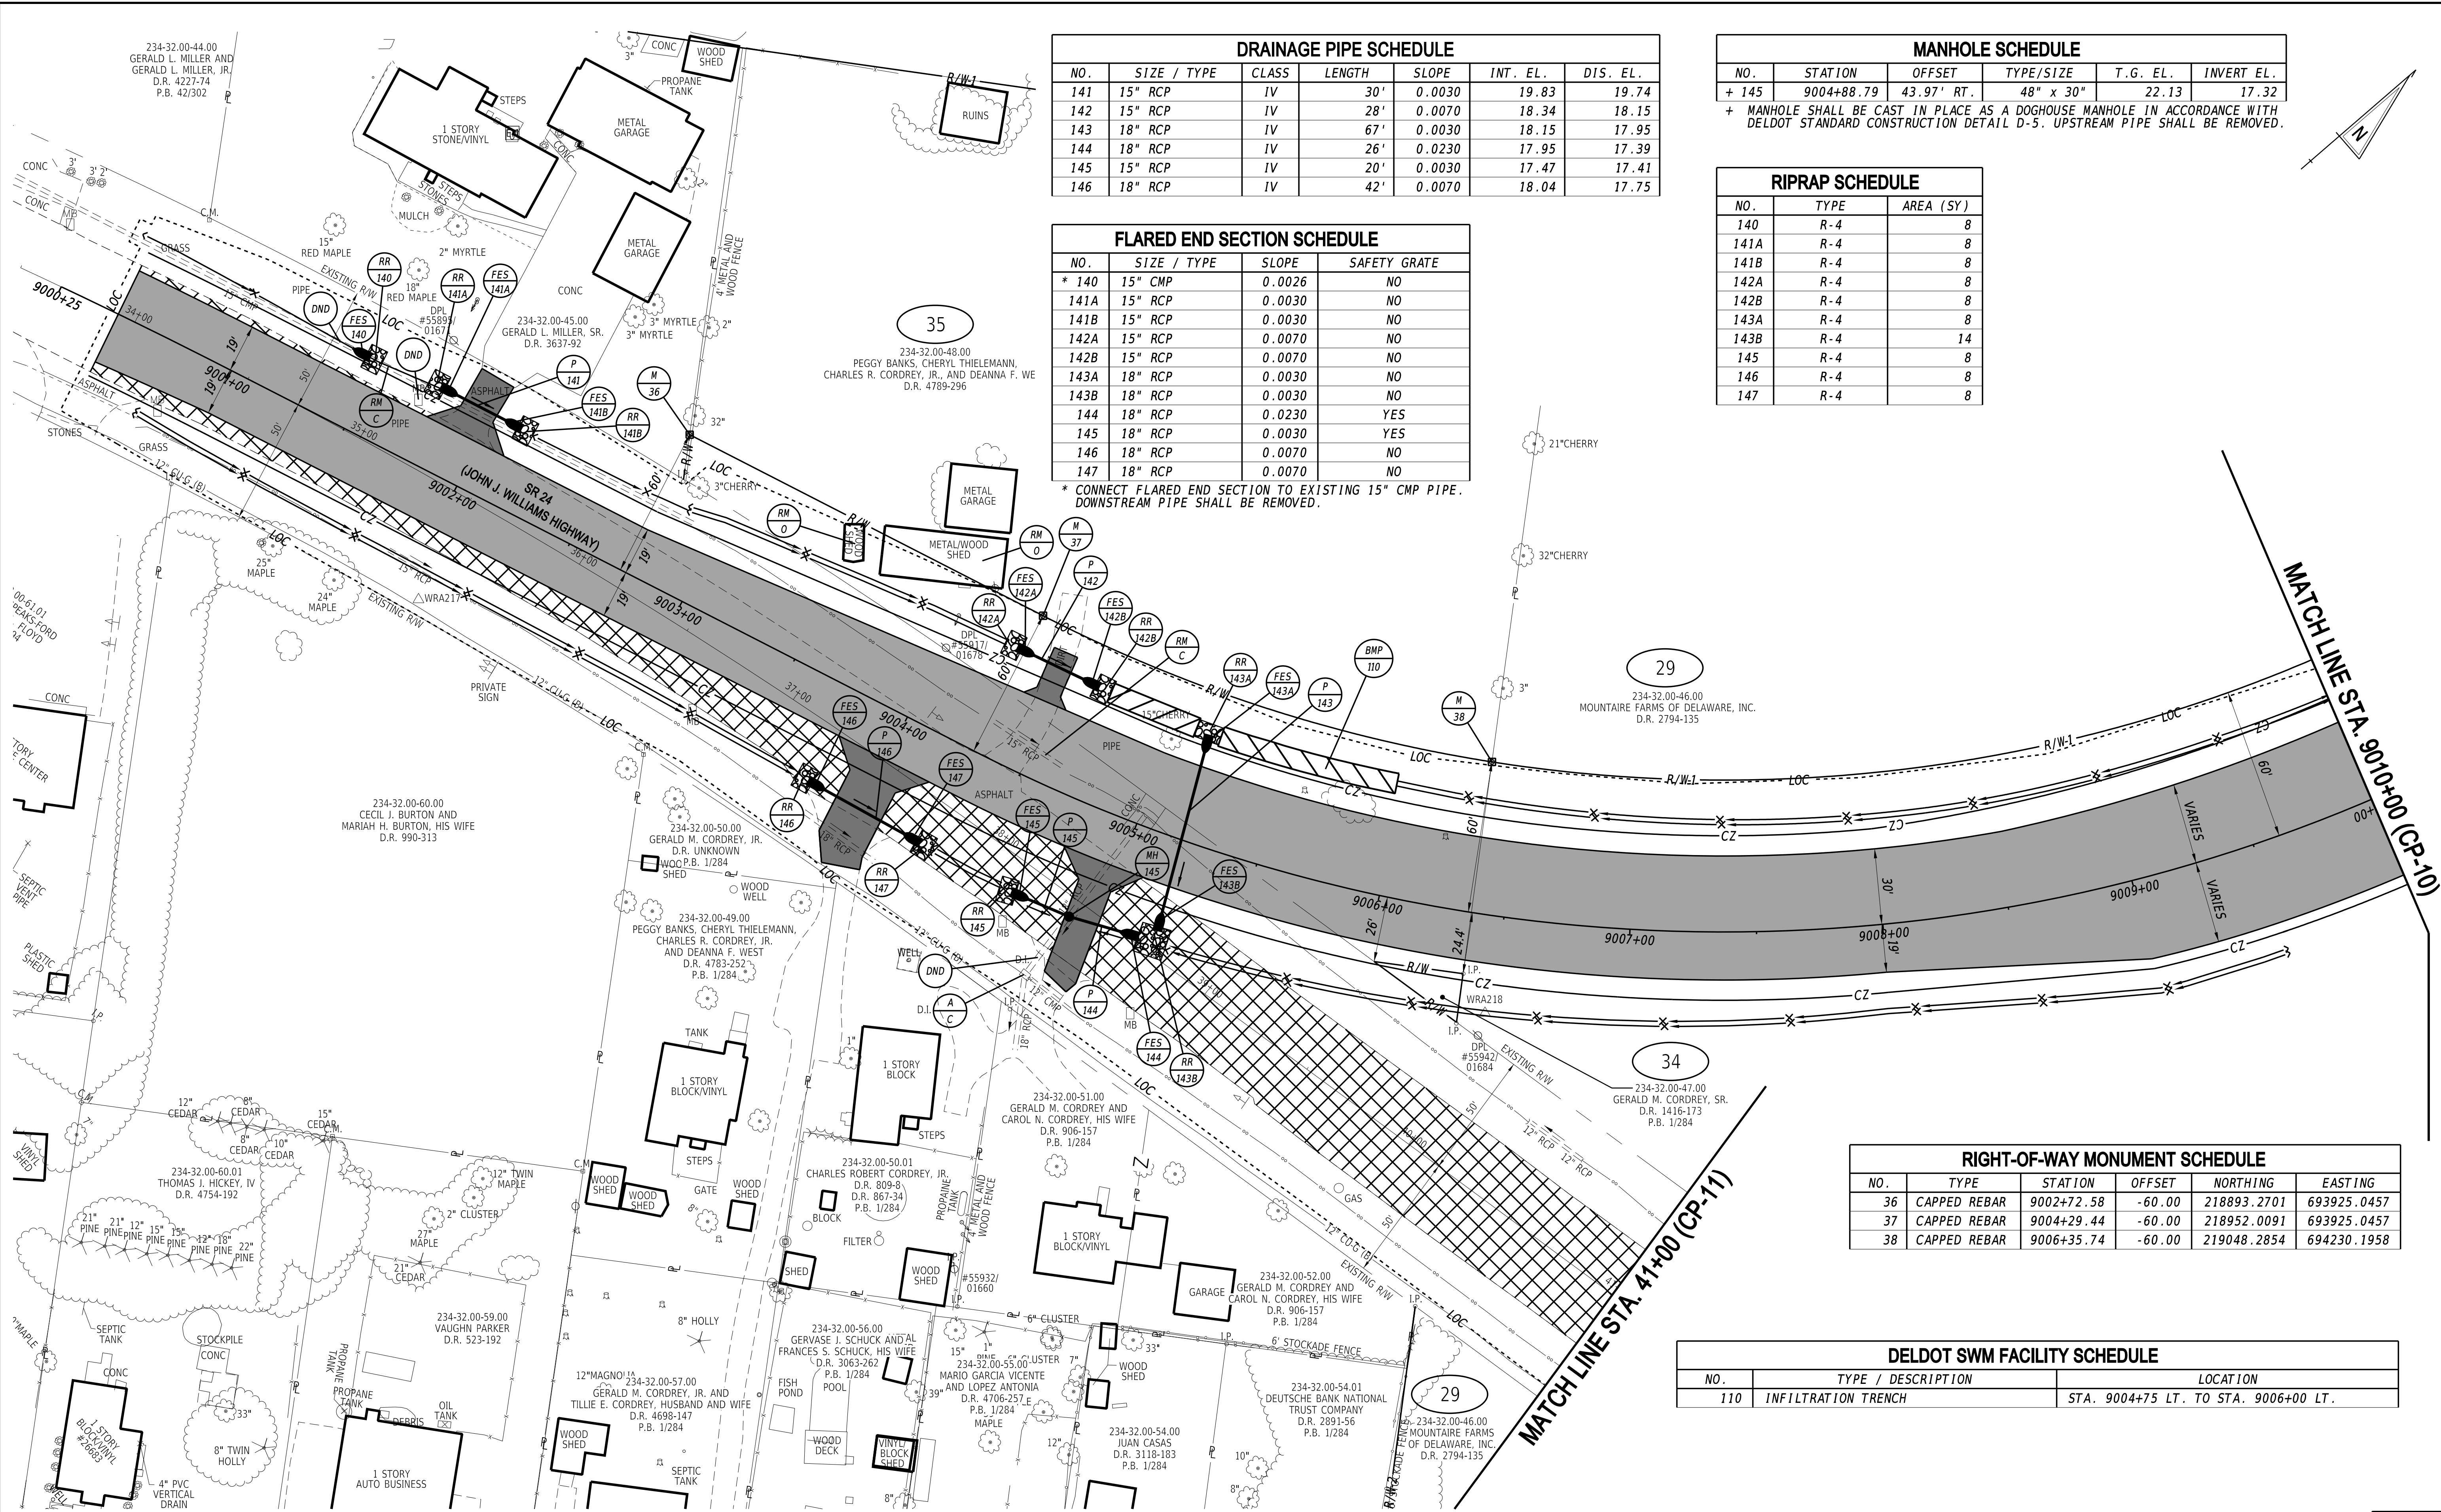

DRAINAGE PIPE SCHEDULE						
NO.	SIZE / TYPE	CLASS	LENGTH	SLOPE	INT. EL.	DIS. EL.
141	15" RCP	IV	30'	0.0030	19.83	19.74
142	15" RCP	IV	28'	0.0070	18.34	18.15
143	18" RCP	IV	67'	0.0030	18.15	17.95
144	18" RCP	IV	26'	0.0230	17.95	17.39
145	15" RCP	IV	20'	0.0030	17.47	17.41
146	18" RCP	IV	42'	0.0070	18.04	17.75

MANHOLE SCHEDULE					
NO.	STATION	OFFSET	TYPE/SIZE	T.G. EL.	INVERT EL.
+ 145	9004+88.79	43.97' RT.	48" x 30"	22.13	17.32
+ MANHOLE SHALL BE CAST IN PLACE AS A DOGHOUSE MANHOLE IN ACCORDANCE WITH DELDOT STANDARD CONSTRUCTION DETAIL D-5. UPSTREAM PIPE SHALL BE REMOVED.					

RIPRAP SCHEDULE		
NO.	TYPE	AREA (SY)
140	R-4	8
141A	R-4	8
141B	R-4	8
142A	R-4	8
142B	R-4	8
143A	R-4	8
143B	R-4	14
145	R-4	8
146	R-4	8
147	R-4	8


FLARED END SECTION SCHEDULE			
NO.	SIZE / TYPE	SLOPE	SAFETY GRATE
* 140	15" CMP	0.0026	NO
141A	15" RCP	0.0030	NO
141B	15" RCP	0.0030	NO
142A	15" RCP	0.0070	NO
142B	15" RCP	0.0070	NO
143A	18" RCP	0.0030	NO
143B	18" RCP	0.0030	NO
144	18" RCP	0.0230	YES
145	18" RCP	0.0030	YES
146	18" RCP	0.0070	NO
147	18" RCP	0.0070	NO

* CONNECT FLARED END SECTION TO EXISTING 15" CMP PIPE. DOWNSTREAM PIPE SHALL BE REMOVED.

RIGHT-OF-WAY MONUMENT SCHEDULE					
NO.	TYPE	STATION	OFFSET	NORTHING	EASTING
36	CAPPED REBAR	9002+72.58	-60.00	218893.2701	693925.0457
37	CAPPED REBAR	9004+29.44	-60.00	218952.0091	693925.0457
38	CAPPED REBAR	9006+35.74	-60.00	219048.2854	694230.1958

DELDOT SWM FACILITY SCHEDULE		
NO.	TYPE / DESCRIPTION	LOCATION
110	INFILTRATION TRENCH	STA. 9004+75 LT. TO STA. 9006+00 LT.

ADDENDA / REVISIONS

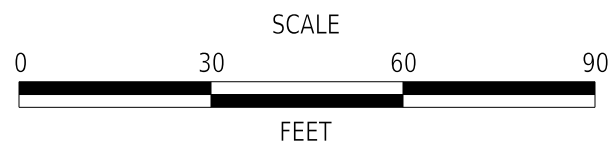

CM/GC,
NORTH MILLSBORO BYPASS,
US 113 TO SR 24

CONTRACT	BRIDGE NO.	N/A
T202112701	DESIGNED BY:	S. BEALL
COUNTY	CHECKED BY:	T. OLIVER
SUSSEX		

CONSTRUCTION PLAN


CP-13
SECTION
WRA
SHEET NO.
29

DRAINAGE PIPE SCHEDULE						
NO.	SIZE / TYPE	CLASS	LENGTH	SLOPE	INT. EL.	DIS. EL.
148	18" RCP	IV	85'	0.0031	23.26	23.00
150	15" RCP	IV	46'	0.0030	23.87	23.73

FLARED END SECTION SCHEDULE			
NO.	SIZE / TYPE	SLOPE	SAFETY GRATE
148	18" RCP	0.0031	NO
149	18" RCP	0.0031	NO
150	15" RCP	0.0030	NO
151	15" RCP	0.0030	NO

RIPRAP SCHEDULE		
NO.	TYPE	AREA (SY)
148	R-4	9
149	R-4	7
151	R-4	8

DELDOT SWM FACILITY SCHEDULE		
NO.	TYPE / DESCRIPTION	LOCATION
108	INFILTRATION TRENCH	STA. 9019+00 LT. TO STA. 9020+95 LT.
109	INFILTRATION TRENCH	STA. 9019+00 RT. TO STA. 9021+35 RT.


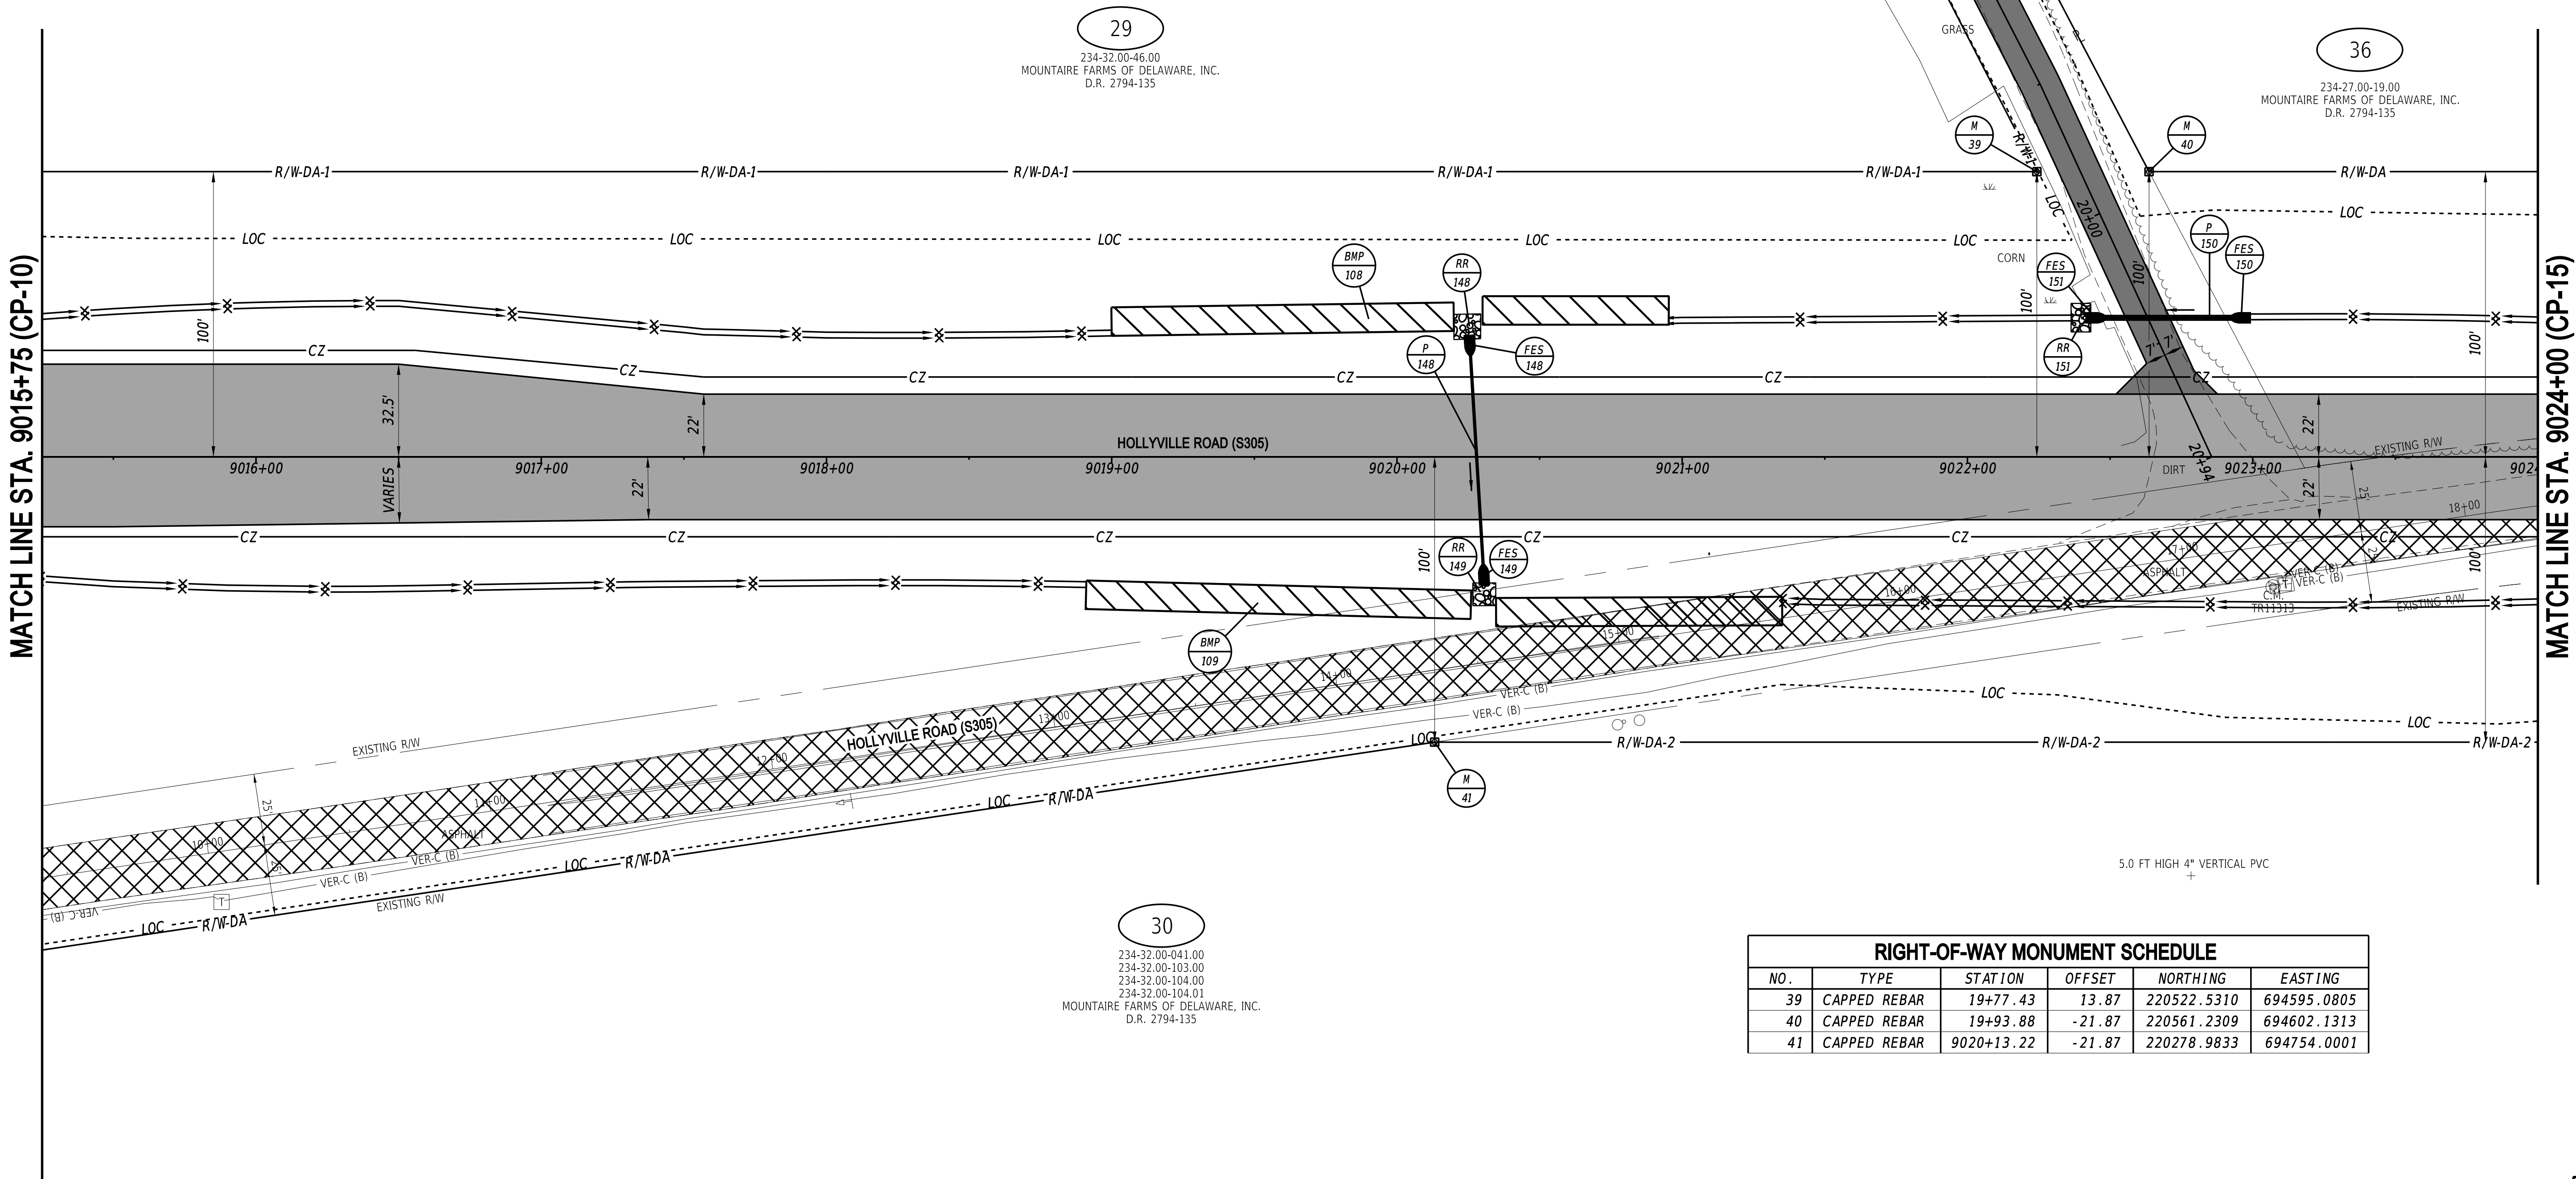


RIGHT-OF-WAY MONUMENT SCHEDULE					
NO.	TYPE	STATION	OFFSET	NORTHING	EASTING
39	CAPPED REBAR	19+77.43	13.87	220522.5310	694595.0805
40	CAPPED REBAR	19+93.88	-21.87	220561.2309	694602.1313
41	CAPPED REBAR	9020+13.22	-21.87	220278.9833	694754.0001

3/4/2022 6:13:42 PM N:\132149-002\CADD\US 113 NM Bypass\CP14_NMB.dgn


										CP-14		
ADDENDA / REVISIONS				SCALE 0306090 FEET		CONTRACT		BRIDGE NO.	N/A		CONSTRUCTION PLAN	SECTION
						T202112701		DESIGNED BY: S. BEALL		WRA		
						COUNTY		CHECKED BY: T. OLIVER		SHEET NO.		
						SUSSEX					30	

RIGHT-OF-WAY MONUMENT SCHEDULE					
NO.	TYPE	STATION	OFFSET	NORTHING	EASTING
42	CAPPED REBAR	9025+56.93	-100.00	220849.7391	694654.6955
43	CAPPED REBAR	9026+78.00	-100.00	220968.8461	694676.3959
44	CAPPED REBAR	9026+78.00	-15.45	220953.6909	694759.5779
45	CAPPED REBAR	9026+74.00	34.43	220940.8147	694807.9352
46	CAPPED REBAR	9026+74.00	100.00	220940.8147	694872.4400

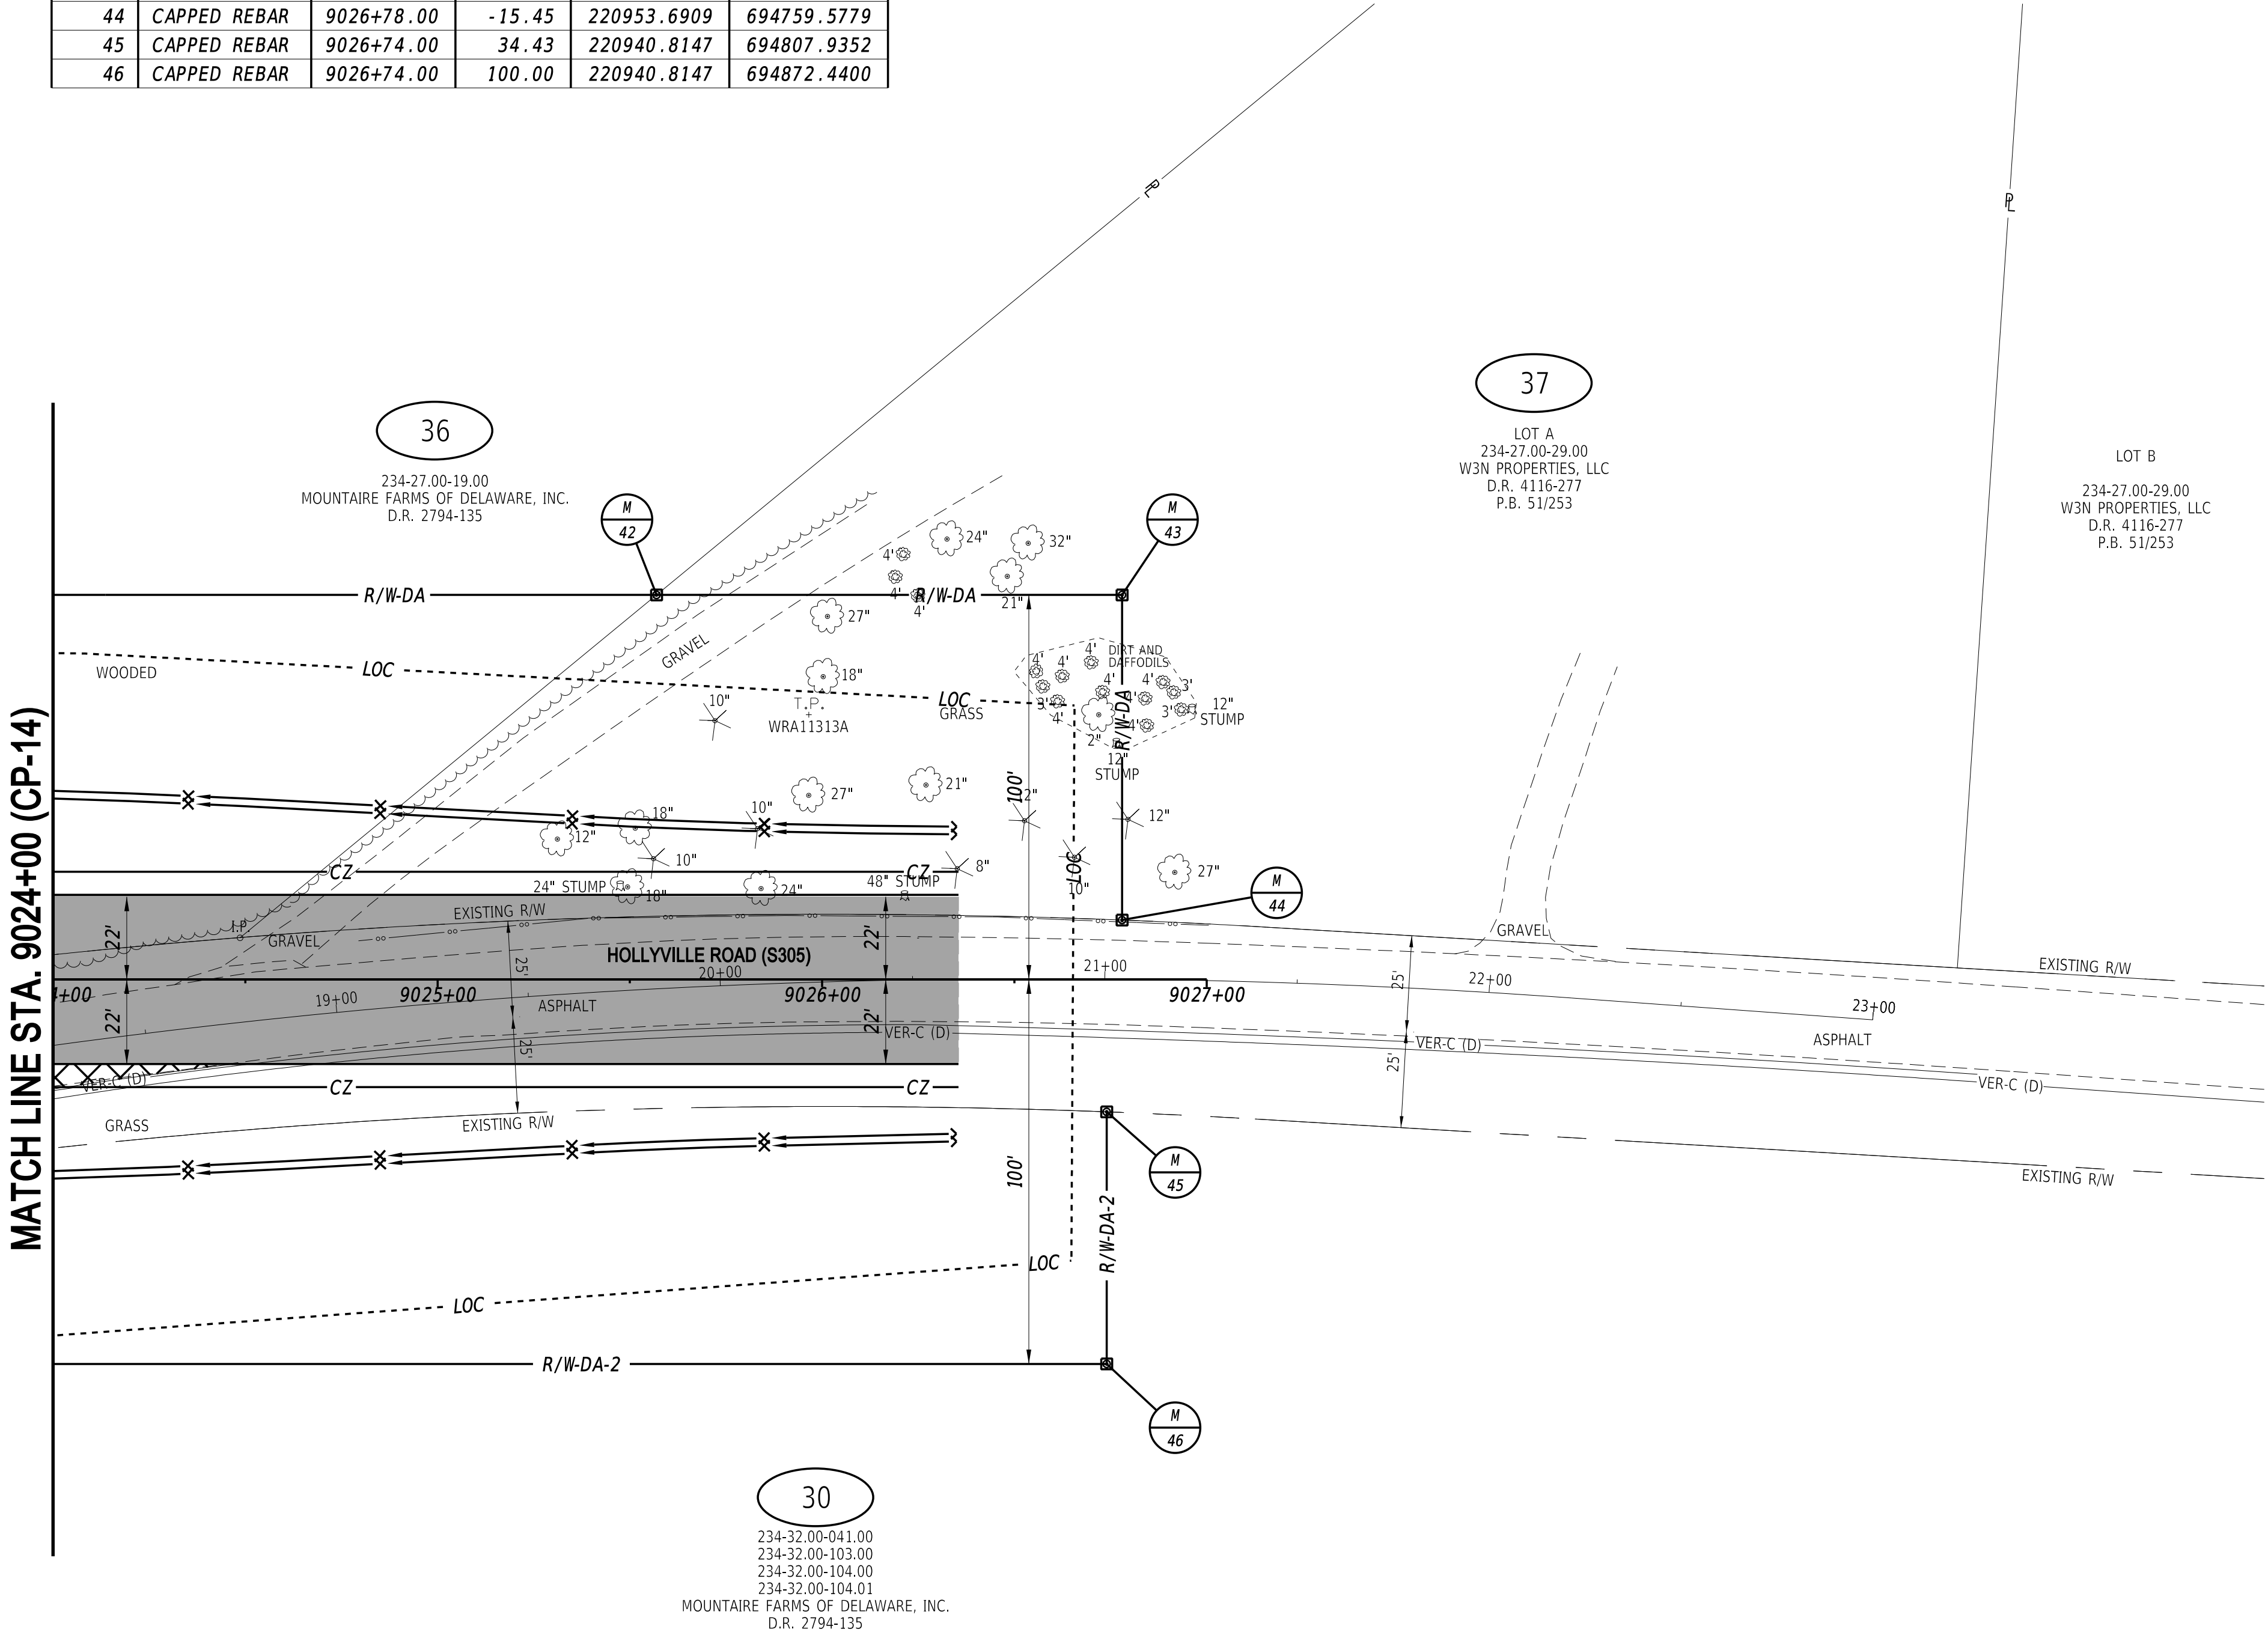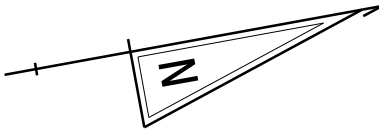

MATCH LINE STA. 9024+00 (CP-14)

ADDENDA / REVISIONS	

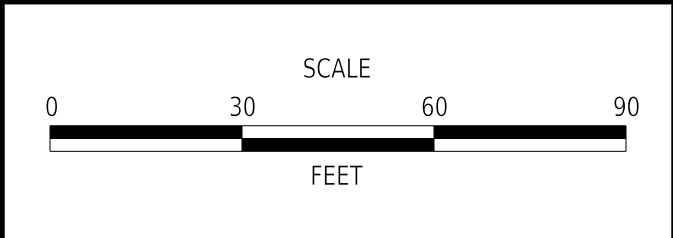


CM/GC,
NORTH MILLSBORO BYPASS,
US 113 TO SR 24

CONTRACT	BRIDGE NO.	N/A
T202112701	DESIGNED BY:	S. BEALL
COUNTY	CHECKED BY:	T. OLIVER
SUSSEX		

CONSTRUCTION PLAN	
SECTION	WRA
SHEET NO.	31

3/4/2022
6:13:44 PM
N:\132149-002\CADD\US 113 NM Bypass\CP16_NMBP.dgn

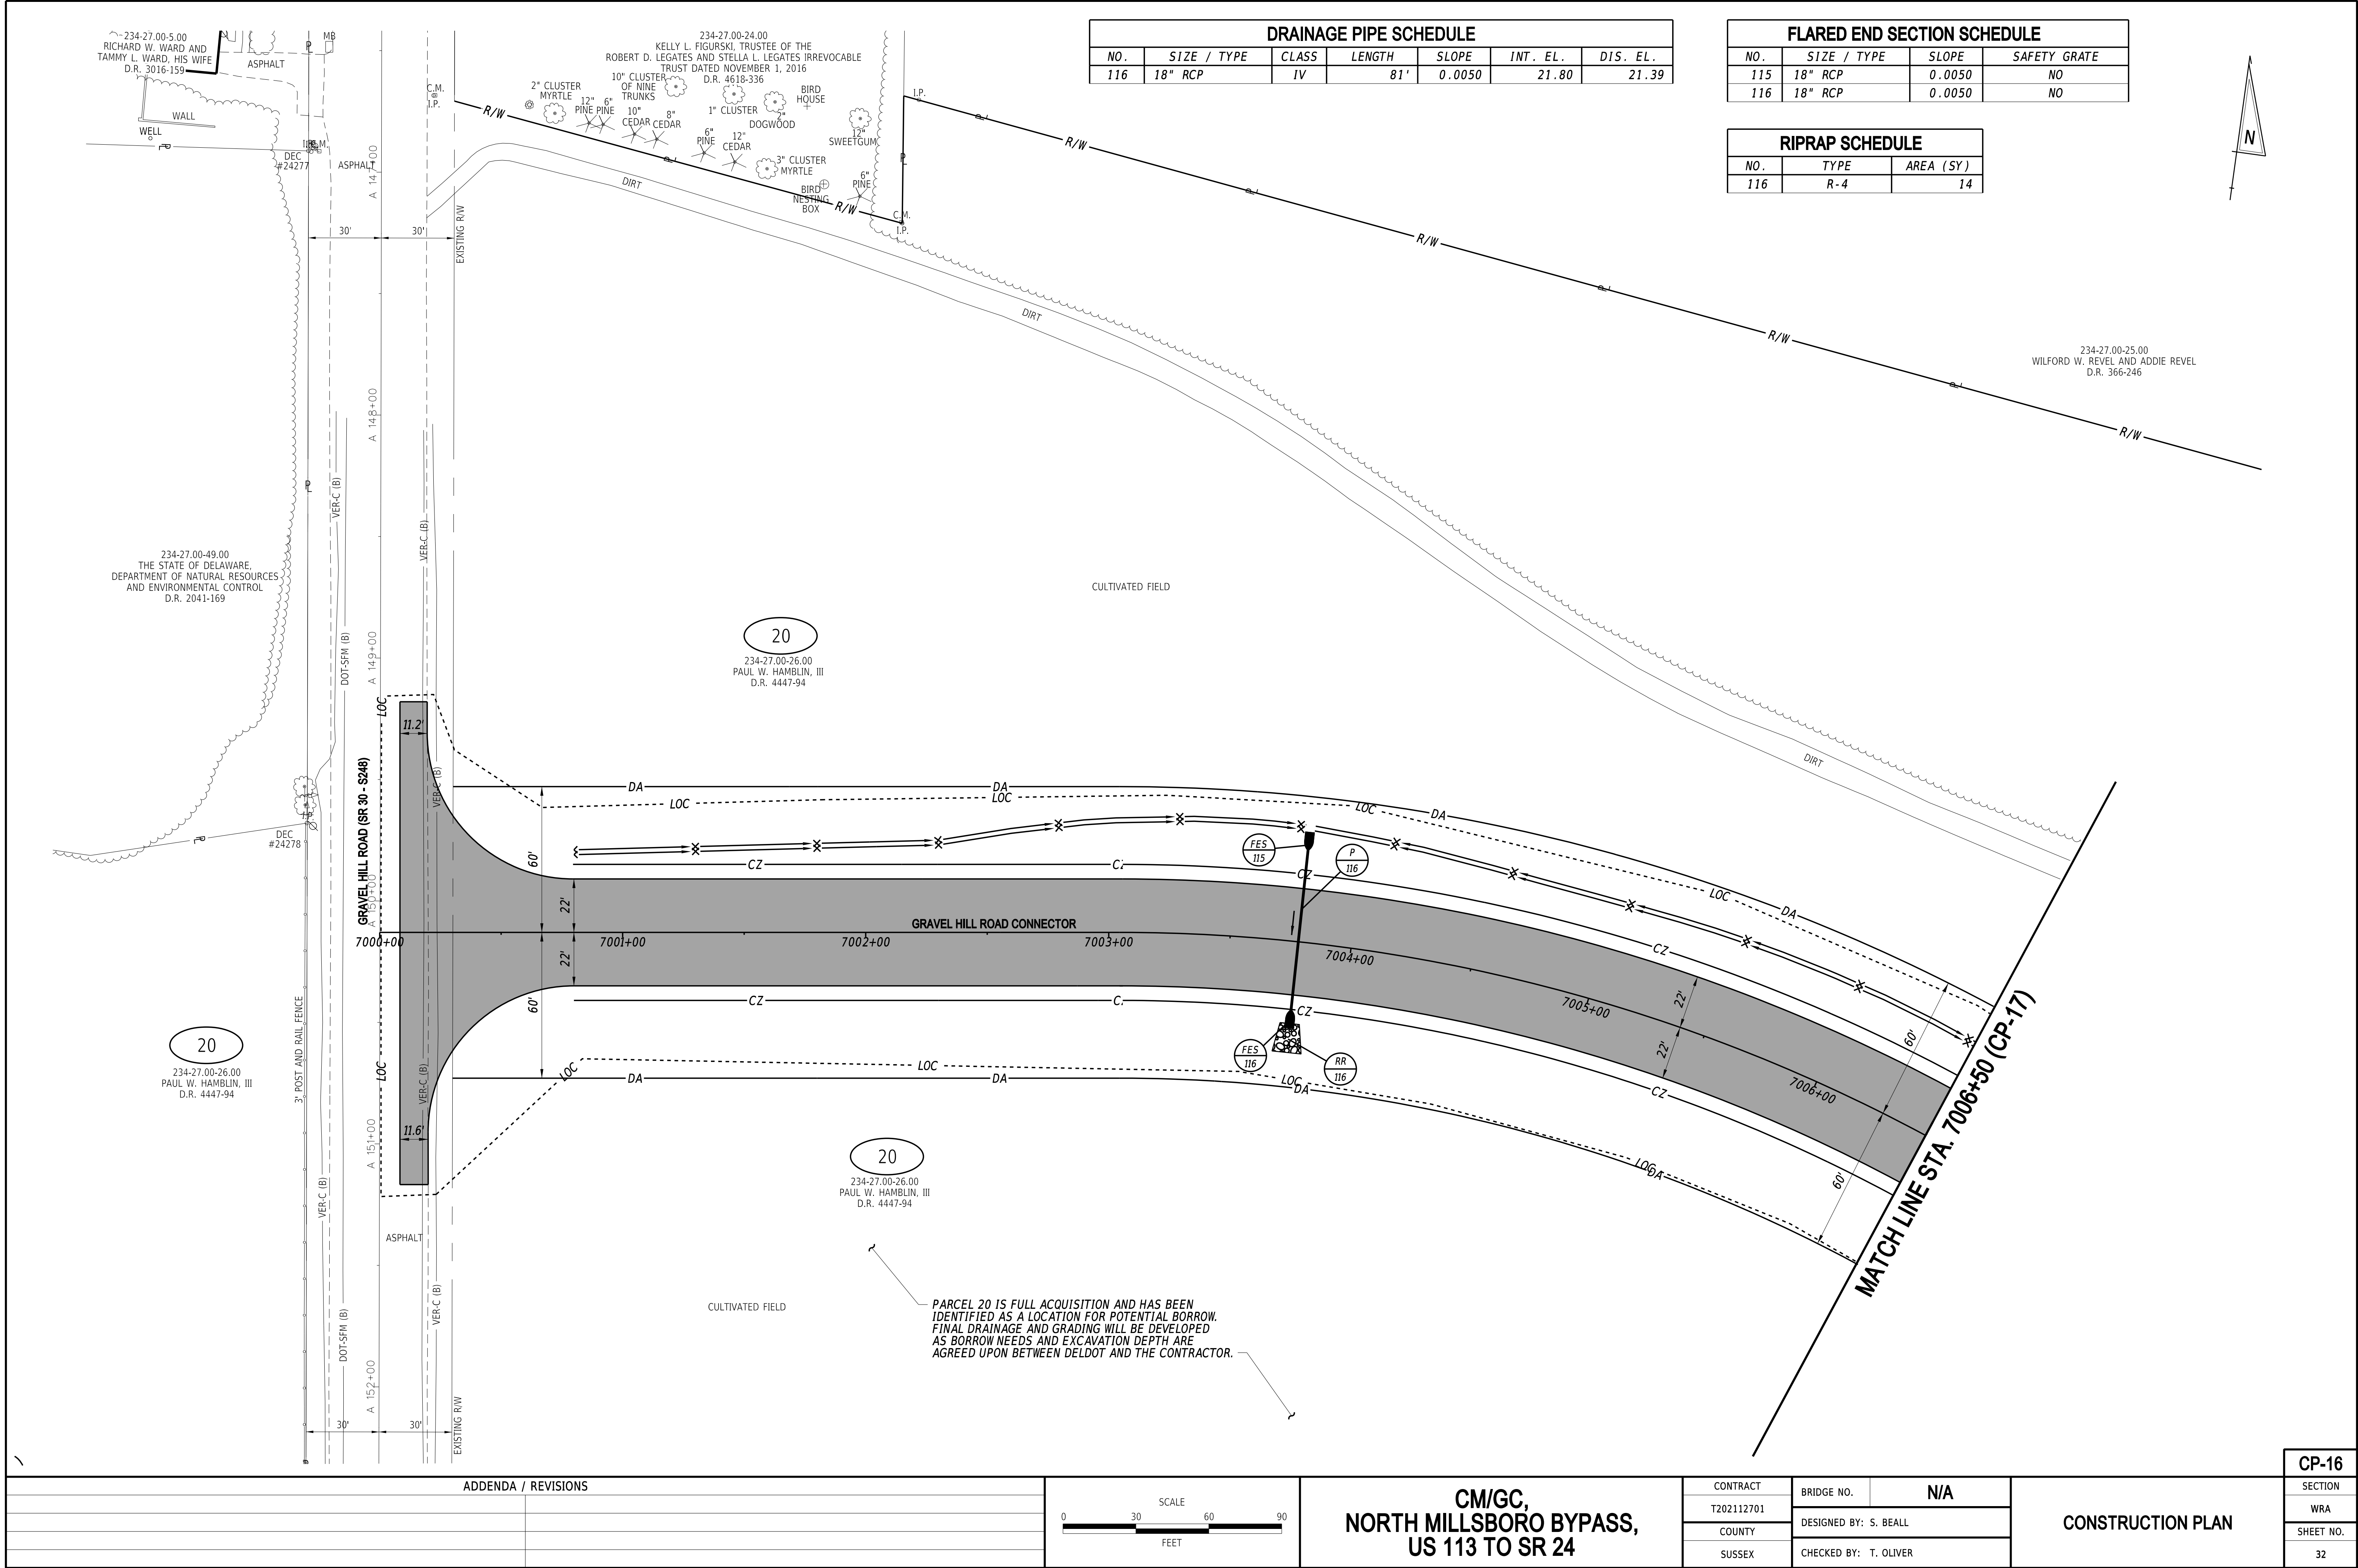


DRAINAGE PIPE SCHEDULE						
NO.	SIZE / TYPE	CLASS	LENGTH	SLOPE	INT. EL.	DIS. EL.
116	18" RCP	IV	81'	0.0050	21.80	21.39

FLARED END SECTION SCHEDULE			
NO.	SIZE / TYPE	SLOPE	SAFETY GRATE
115	18" RCP	0.0050	NO
116	18" RCP	0.0050	NO

RIPRAP SCHEDULE		
NO.	TYPE	AREA (SY)
116	R-4	14

ADDENDA / REVISIONS	

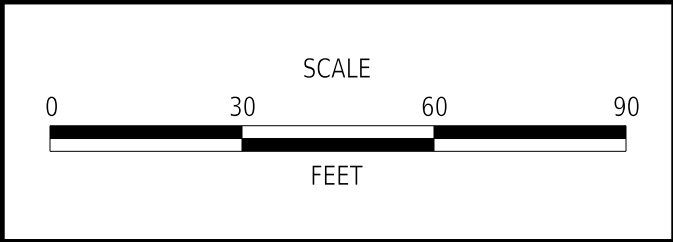


CM/GC,
NORTH MILLSBORO BYPASS,
US 113 TO SR 24

CONTRACT	BRIDGE NO.	N/A
T202112701	DESIGNED BY:	S. BEALL
COUNTY	CHECKED BY:	T. OLIVER
SUSSEX		


CONSTRUCTION PLAN	

CP-16
SECTION
WRA
SHEET NO.
32

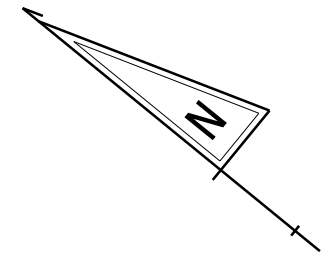

20
234-27.00-26.00
PAUL W. HAMBLIN, III
D.R. 4447-94

CULTIVATED FIELD

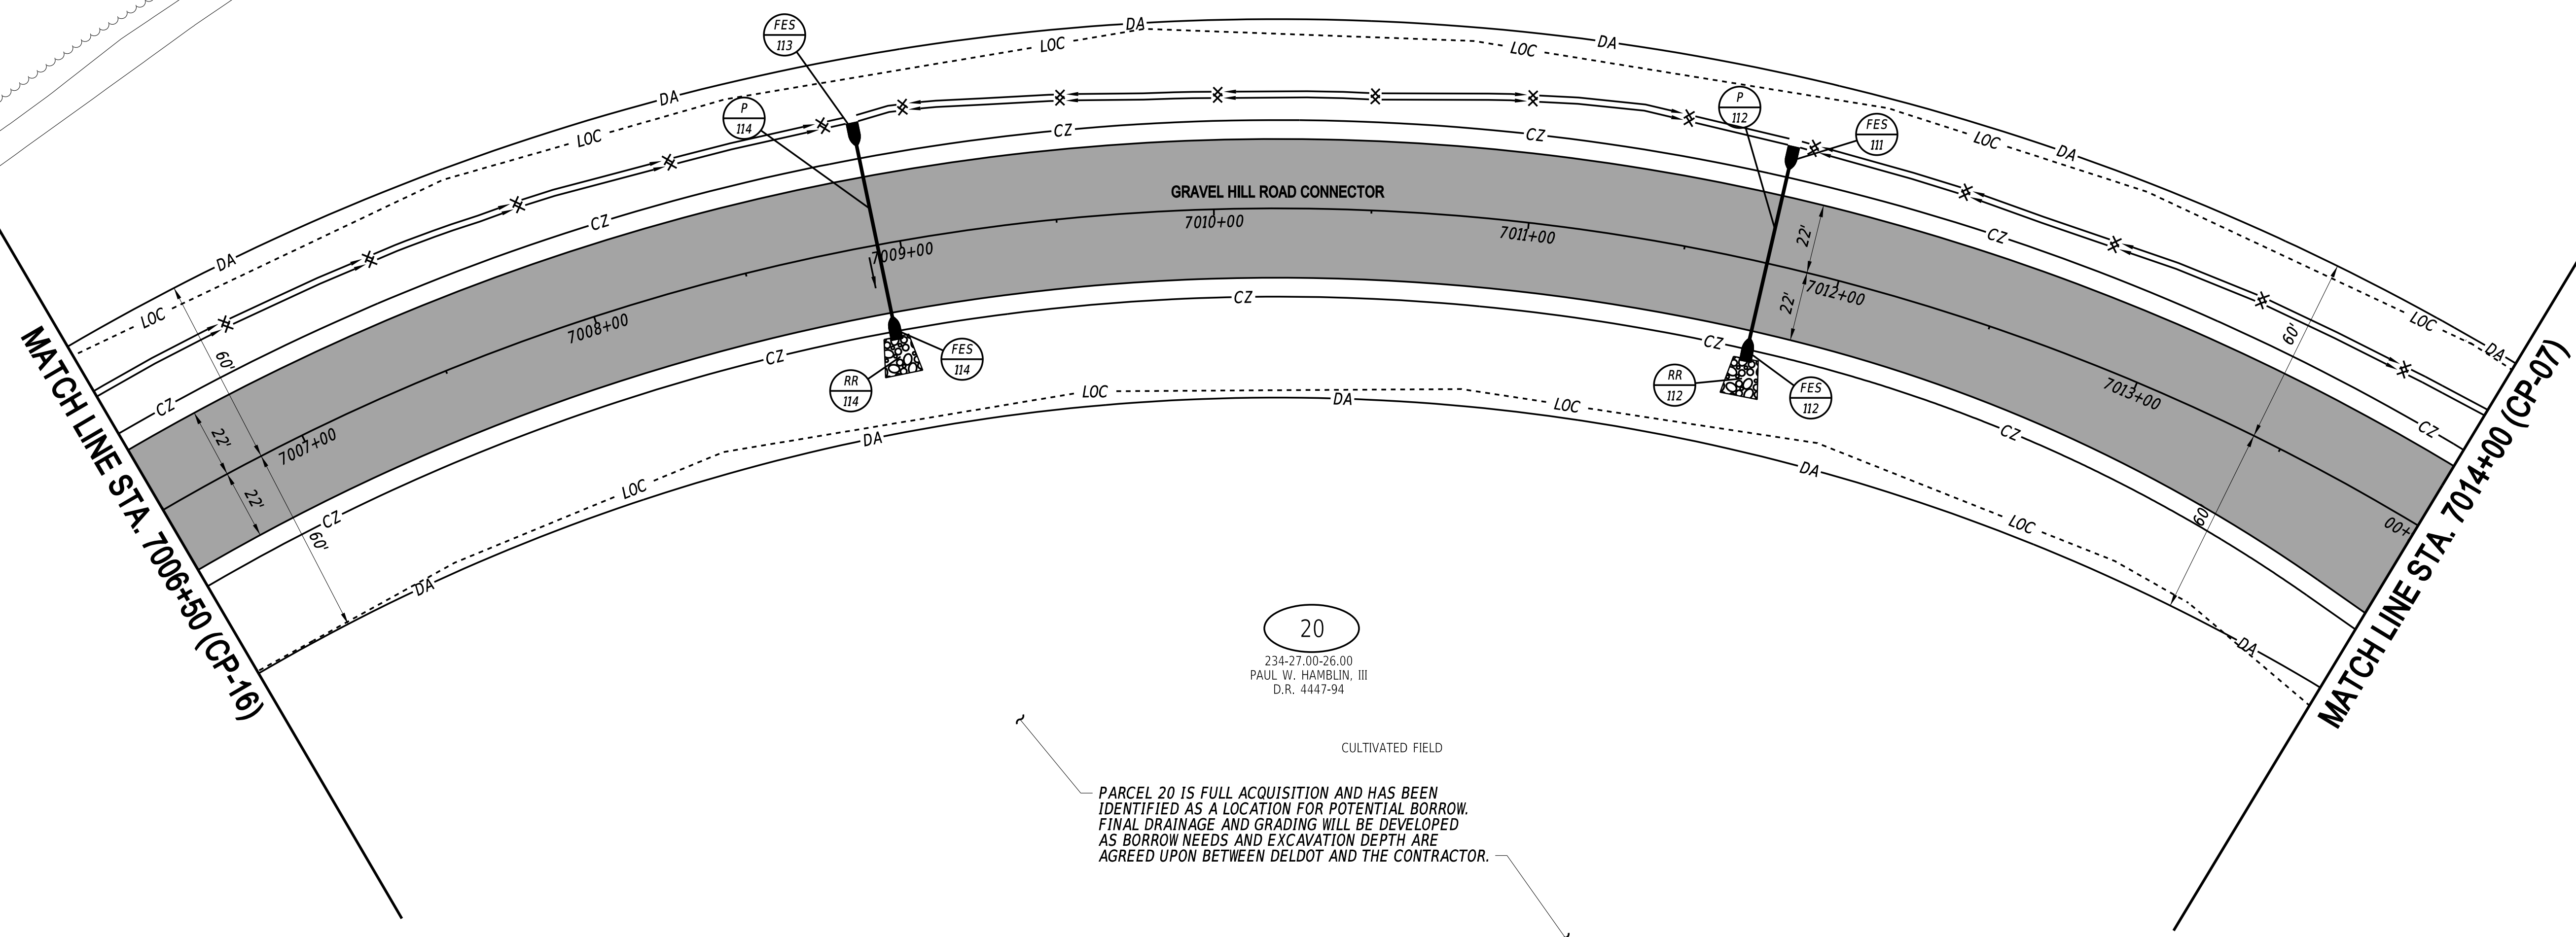

20
234-27.00-26.00
PAUL W. HAMBLIN, III
D.R. 4447-94

CULTIVATED FIELD


PARCEL 20 IS FULL ACQUISITION AND HAS BEEN IDENTIFIED AS A LOCATION FOR POTENTIAL BORROW. FINAL DRAINAGE AND GRADING WILL BE DEVELOPED AS BORROW NEEDS AND EXCAVATION DEPTH ARE AGREED UPON BETWEEN DELDOT AND THE CONTRACTOR.

DRAINAGE PIPE SCHEDULE						
NO.	SIZE / TYPE	CLASS	LENGTH	SLOPE	INT. EL.	DIS. EL.
112	18" RCP	IV	70'	0.0050	20.41	20.06
114	18" RCP	IV	70'	0.0050	20.72	20.37

FLARED END SECTION SCHEDULE			
NO.	SIZE / TYPE	SLOPE	SAFETY GRATE
111	18" RCP	0.0050	NO
112	18" RCP	0.0050	NO
113	18" RCP	0.0050	NO
114	18" RCP	0.0050	NO

RIPRAP SCHEDULE		
NO.	TYPE	AREA (SY)
112	R-4	14
114	R-4	14

ADDENDA / REVISIONS	

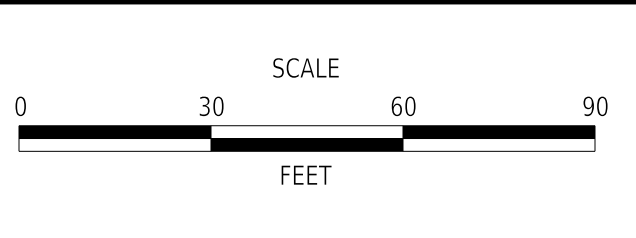

CM/GC,
NORTH MILLSBORO BYPASS,
US 113 TO SR 24


CONTRACT	BRIDGE NO.	N/A
T202112701	DESIGNED BY:	S. BEALL
COUNTY	CHECKED BY:	T. OLIVER
SUSSEX		

CONSTRUCTION PLAN

CP-17
SECTION
WRA
SHEET NO.
33

3/4/2022 6:13:45 PM N:\322149-002\CADD\US 113 NM Bypass\CP17_NMBP.dgn

3/4/2022
6:13:46 PM
N:\132149-002\CADD\US 113 NM Bypass\CP18_NMB.dgn

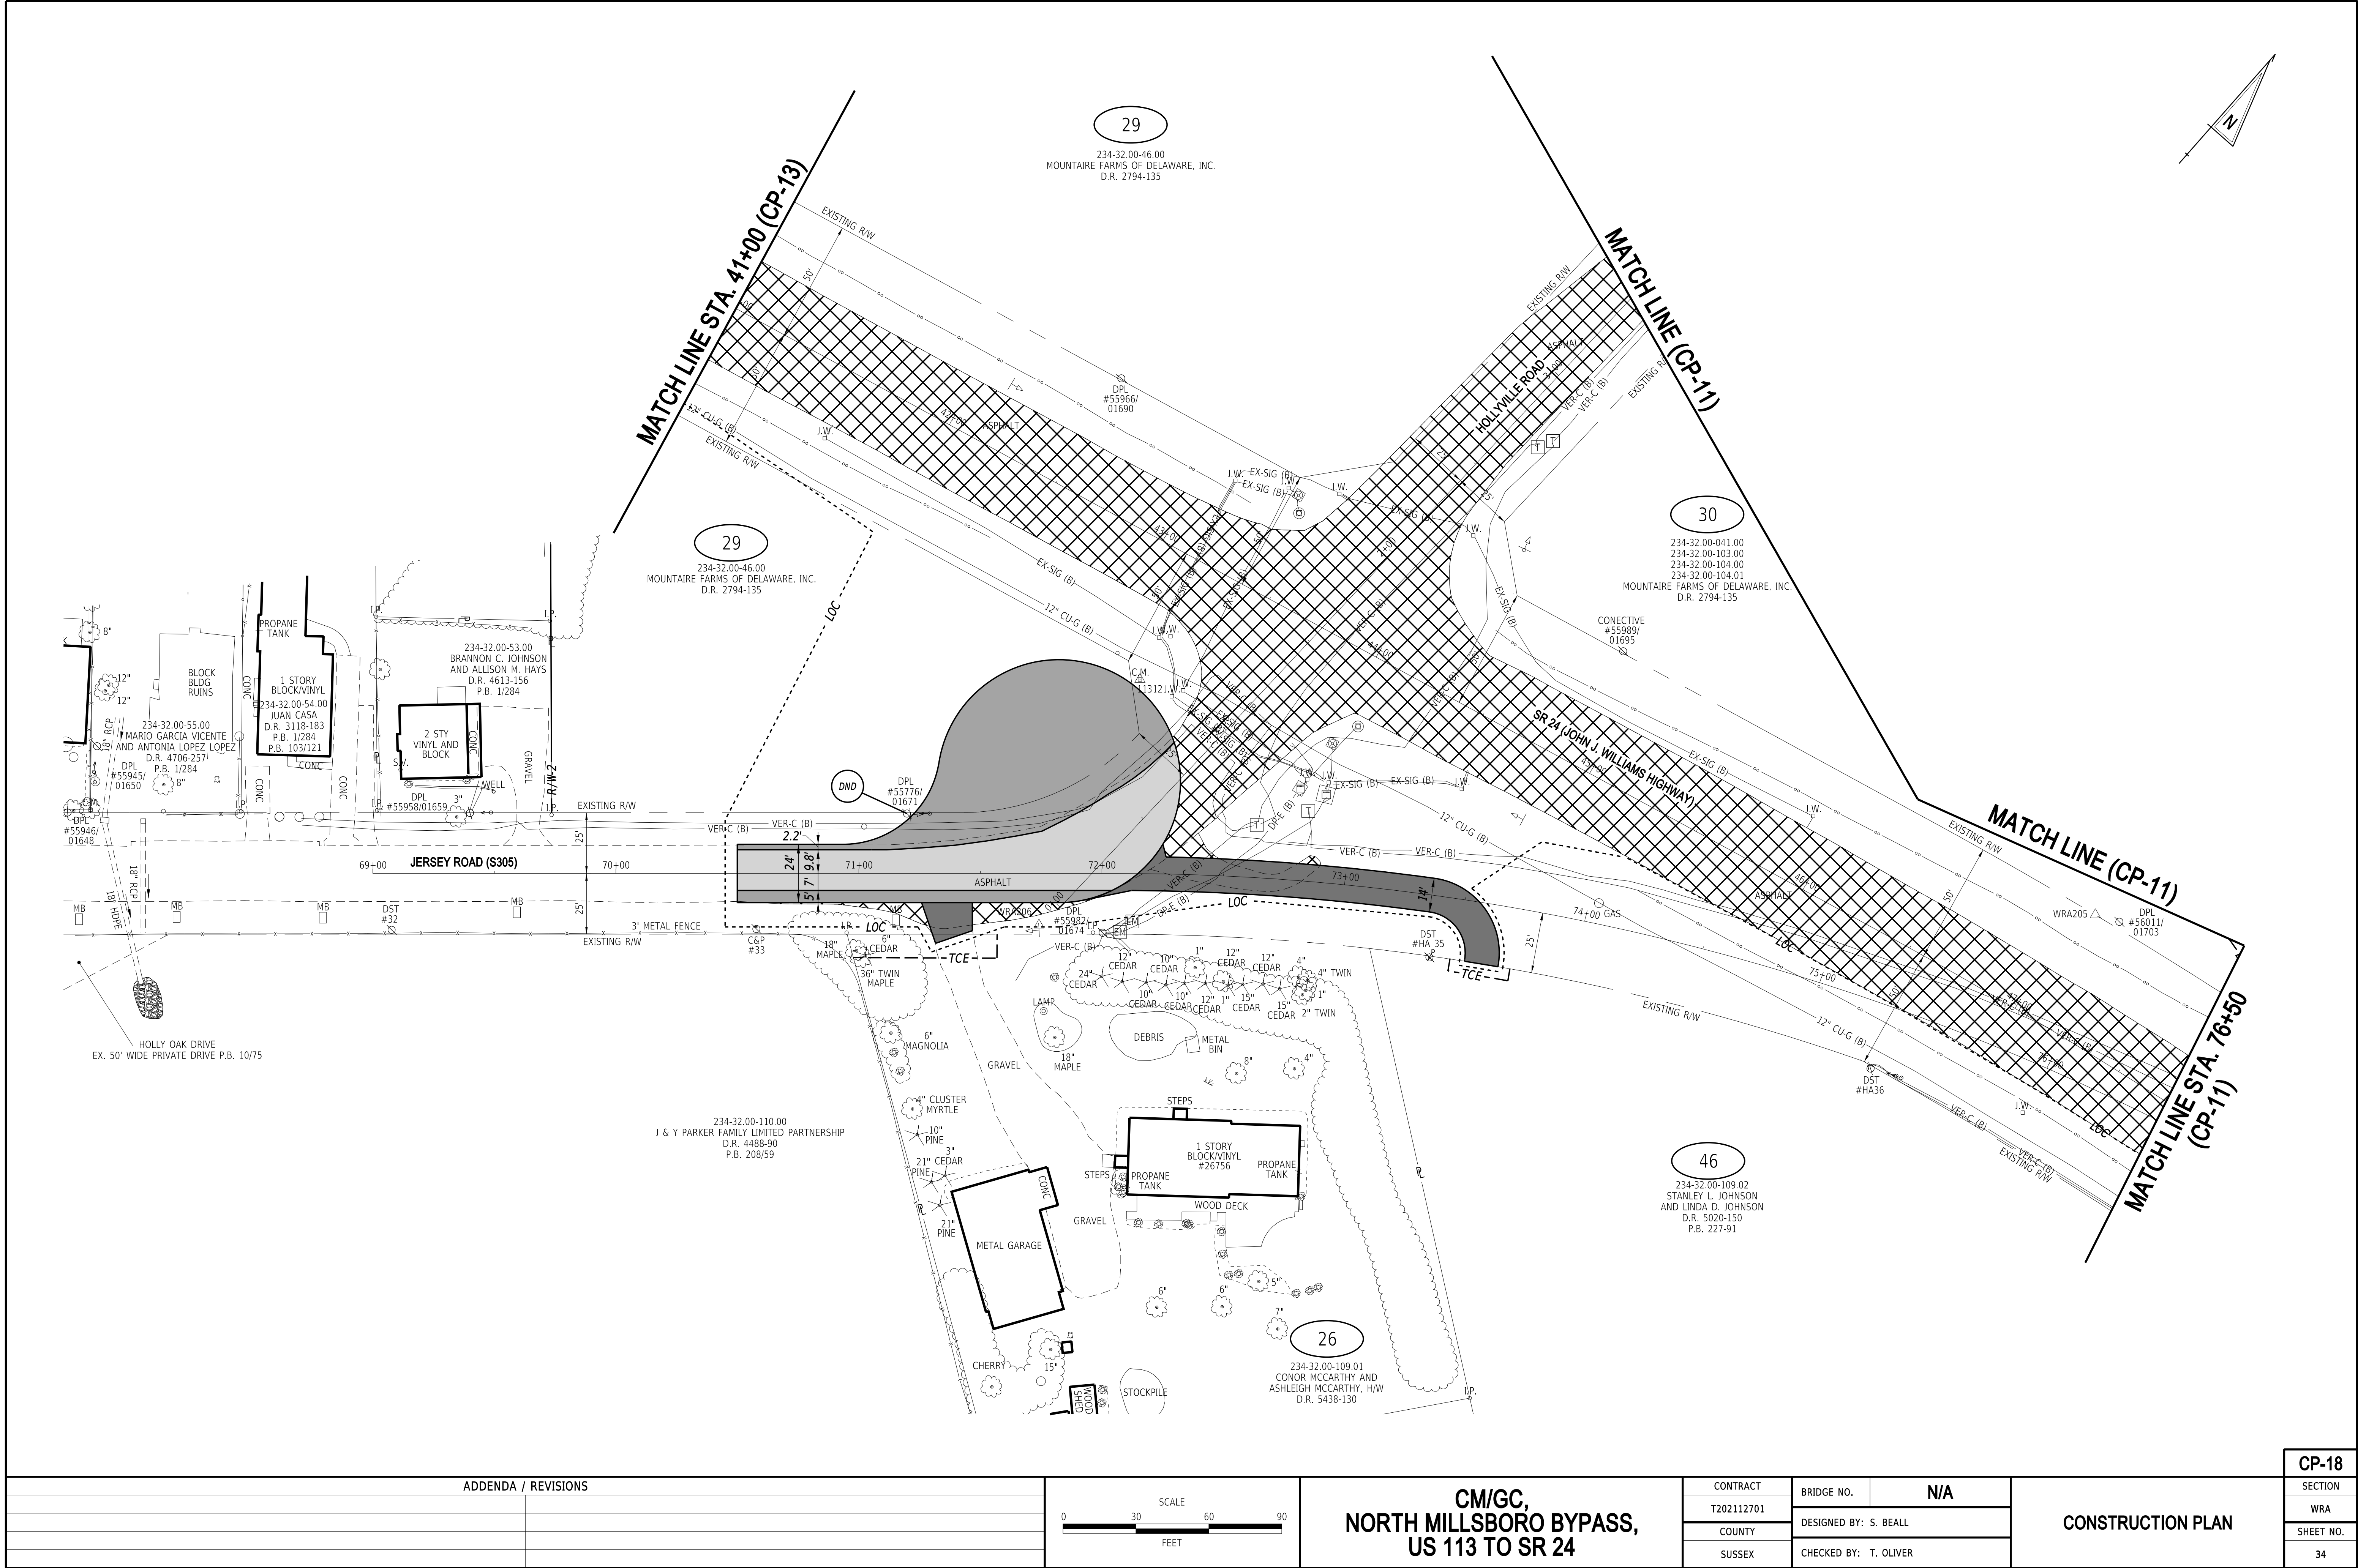

ADDENDA / REVISIONS										SCALE 0306090 FEET		CM/GC, NORTH MILLSBORO BYPASS, US 113 TO SR 24		CONTRACT	BRIDGE NO.	N/A	CONSTRUCTION PLAN		CP-18
														T202112701	DESIGNED BY: S. BEALL				SECTION
														COUNTY	CHECKED BY: T. OLIVER				WRA
														SUSSEX					SHEET NO.
																34			

RIGHT-OF-WAY MONUMENT SCHEDULE					
NO.	TYPE	STATION	OFFSET	NORTHING	EASTING
47	CAPPED REBAR	9+57.30	15.00	220222.6378	693620.8363
48	CAPPED REBAR	11+18.44	15.00	220270.7740	693774.6198
49	CAPPED REBAR	14+67.70	15.00	220375.0619	694107.7945

234-27.00-28.02
KATHERINE P. DUKES
AND BILLY L. WEBB
D.R. 1913-189
P.B. 43/54

36
234-27.00-19.00
MOUNTAIRE FARMS OF DELAWARE, INC.
D.R. 2794-135

MATCH LINE STA. 8+75 (CP-09)

MATCH LINE STA. 17+90 (CP-14)


MATCH LINE (CP-09)

38
LOT 'N'
234-32.00-40.17
LORI SHOWARD AND MYRIAH CARMEAN
D.R. 4470-67
P.B. 250-40

25
234-32.00-40.09
SHIRLEY R. DAVIS, ROY R. ROGERS,
BARRY T. ROGERS, RALPH W. ROGERS,
LINDA M. NEAL, DAVID ALLEN ROGERS,
LORI SHOWARD AND MYRIAH CARMEAN
D.R. 4470-67
P.B. 250/40

29
234-32.00-46.00
MOUNTAIRE FARMS OF DELAWARE, INC.
D.R. 2794-135

ADDENDA / REVISIONS

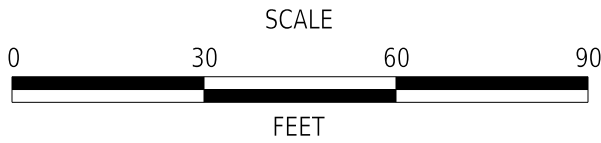

CM/GC,
NORTH MILLSBORO BYPASS,
US 113 TO SR 24

CONTRACT	BRIDGE NO.	N/A
T202112701	DESIGNED BY:	S. BEALL
COUNTY	CHECKED BY:	T. OLIVER
SUSSEX		

CONSTRUCTION PLAN

CP-19

SECTION

WRA

SHEET NO.

35

RIGHT-OF-WAY MONUMENT SCHEDULE					
NO.	TYPE	STATION	OFFSET	NORTHING	EASTING
50	CAPPED REBAR	6125+44.89	-31.91	218252.4047	687179.8708
51	CAPPED REBAR	6125+52.94	-74.49	218270.4262	687218.9703
52	CAPPED REBAR	6118+35.35	-141.07	218889.3678	687460.3121

DRAINAGE PIPE SCHEDULE						
NO.	SIZE / TYPE	CLASS	LENGTH	SLOPE	INT. EL.	DIS. EL.
160	18" RCP	IV	80'	0.0650	25.75	20.50
162	18" RCP	IV	89'	0.0225	22.00	20.01
164	24" RCP	IV	146'	0.0030	17.44	17.00
165	18" RCP	IV	65'	0.0030	16.55	16.35

DRAINAGE INLET SCHEDULE						
NO.	STATION	OFFSET	BOX SIZE	GRATE	T.G. EL.	INV. EL.
165*	6124+38.38	30.91'	34" x 24"	2	22.25	16.55

* DRAINAGE INLET SHALL BE CAST IN PLACE AS A DOGHOUSE INLET IN ACCORDANCE WITH DELDOT STANDARD CONSTRUCTION DETAIL D-5.


FLARED END SECTION SCHEDULE			
NO.	SIZE / TYPE	SLOPE	SAFETY GRATE
160	18" RCP	0.0650	NO
161	18" RCP	0.0650	NO
162	18" RCP	0.0225	NO
163	18" RCP	0.0225	NO
164	24" RCP	0.0030	YES
165	18" RCP	0.0030	YES

RIPRAP SCHEDULE		
NO.	TYPE	AREA (SY)
160	R-4	8
161	R-4	14
162	R-4	8
163	R-4	14
166	R-4	59

DELDOT SWM FACILITY SCHEDULE		
NO.	TYPE / DESCRIPTION	LOCATION
100	INFILTRATION BASIN	STA. 6121+83 RT. TO STA. 6123+33 RT.


NOTES:

- SEE SHEETS 93-95 FOR SWM RISER STRUCTURE AND SWM BASIN DETAILS.
- CONTRACTOR TO USE CLASS A BEDDING, SEE SHEETS 93-95 FOR SWM DETAILS.

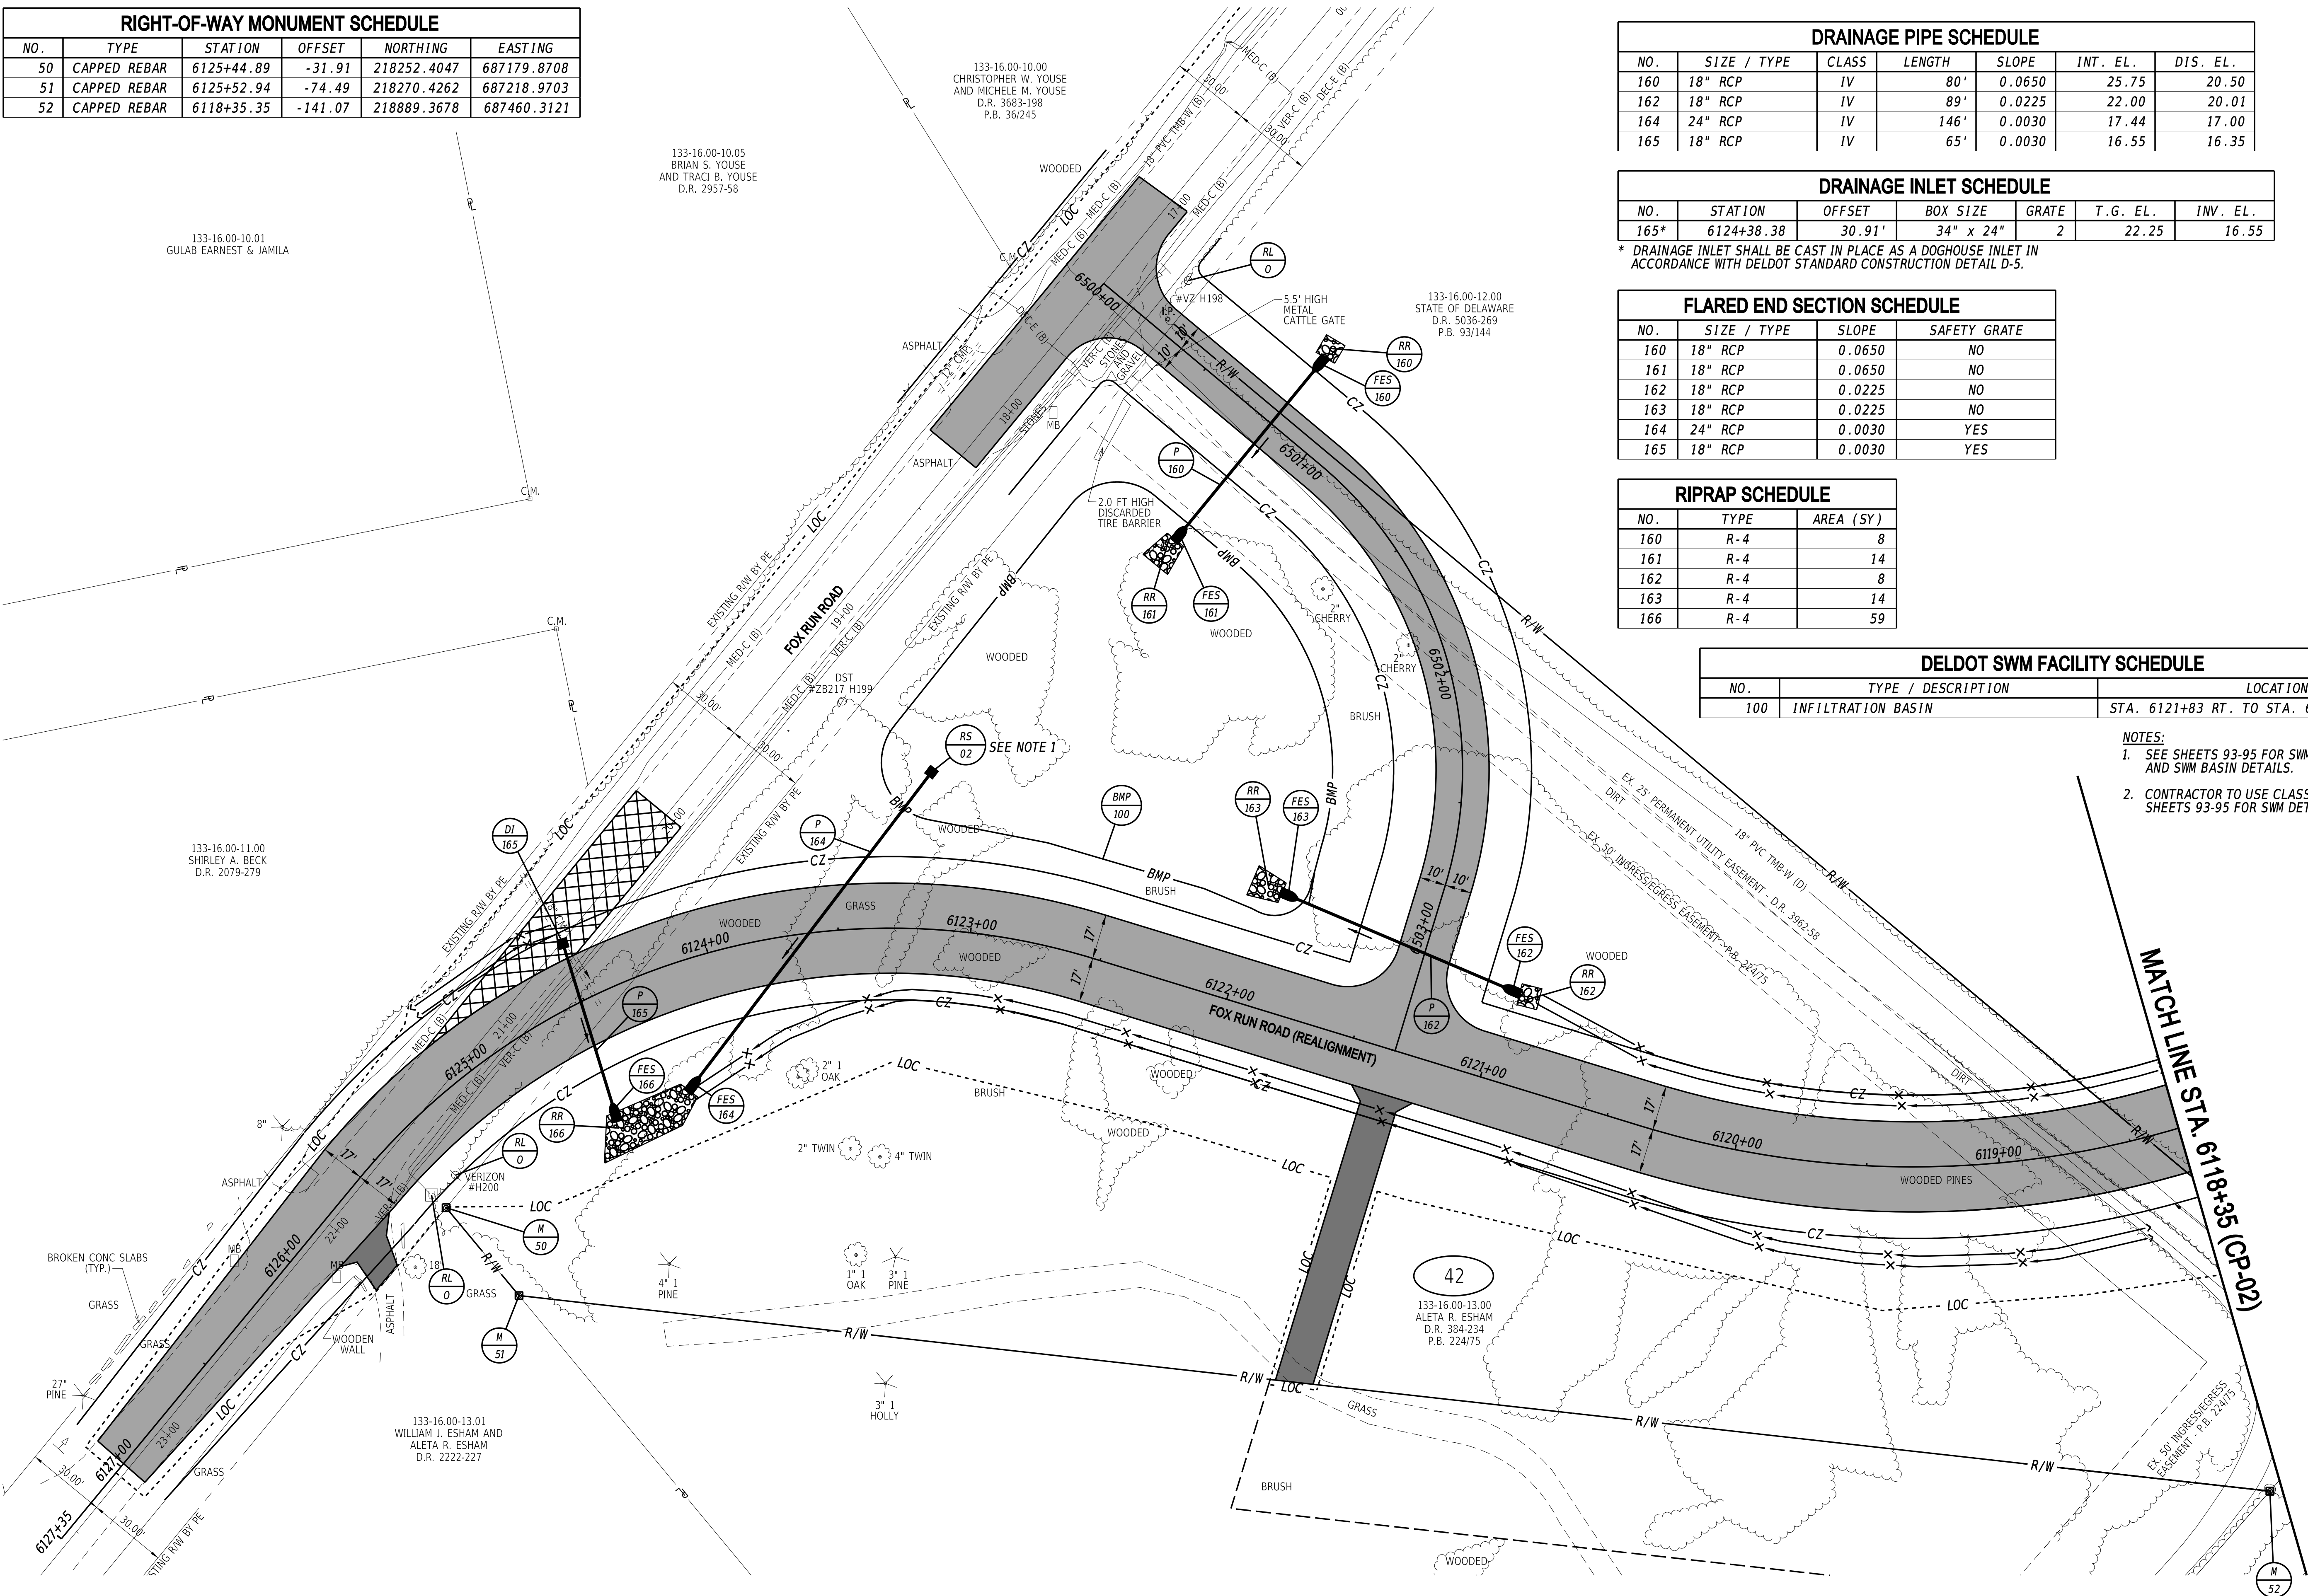

3/4/2022 6:13:49 PM N:\132149-002\CADD\US 113 NM Bypass\CP21_NMBP.dgn

ADDENDA / REVISIONS	

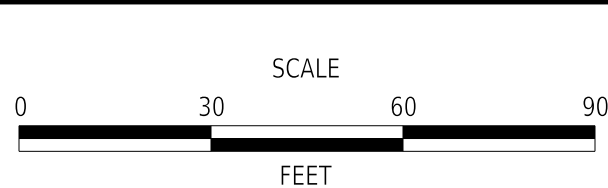


CM/GC,
NORTH MILLSBORO BYPASS,
US 113 TO SR 24

CONTRACT	BRIDGE NO.	N/A
T202112701	DESIGNED BY:	S. BEALL
COUNTY	CHECKED BY:	T. OLIVER
SUSSEX		

CONSTRUCTION PLAN


CP-21
SECTION
WRA
SHEET NO.
37

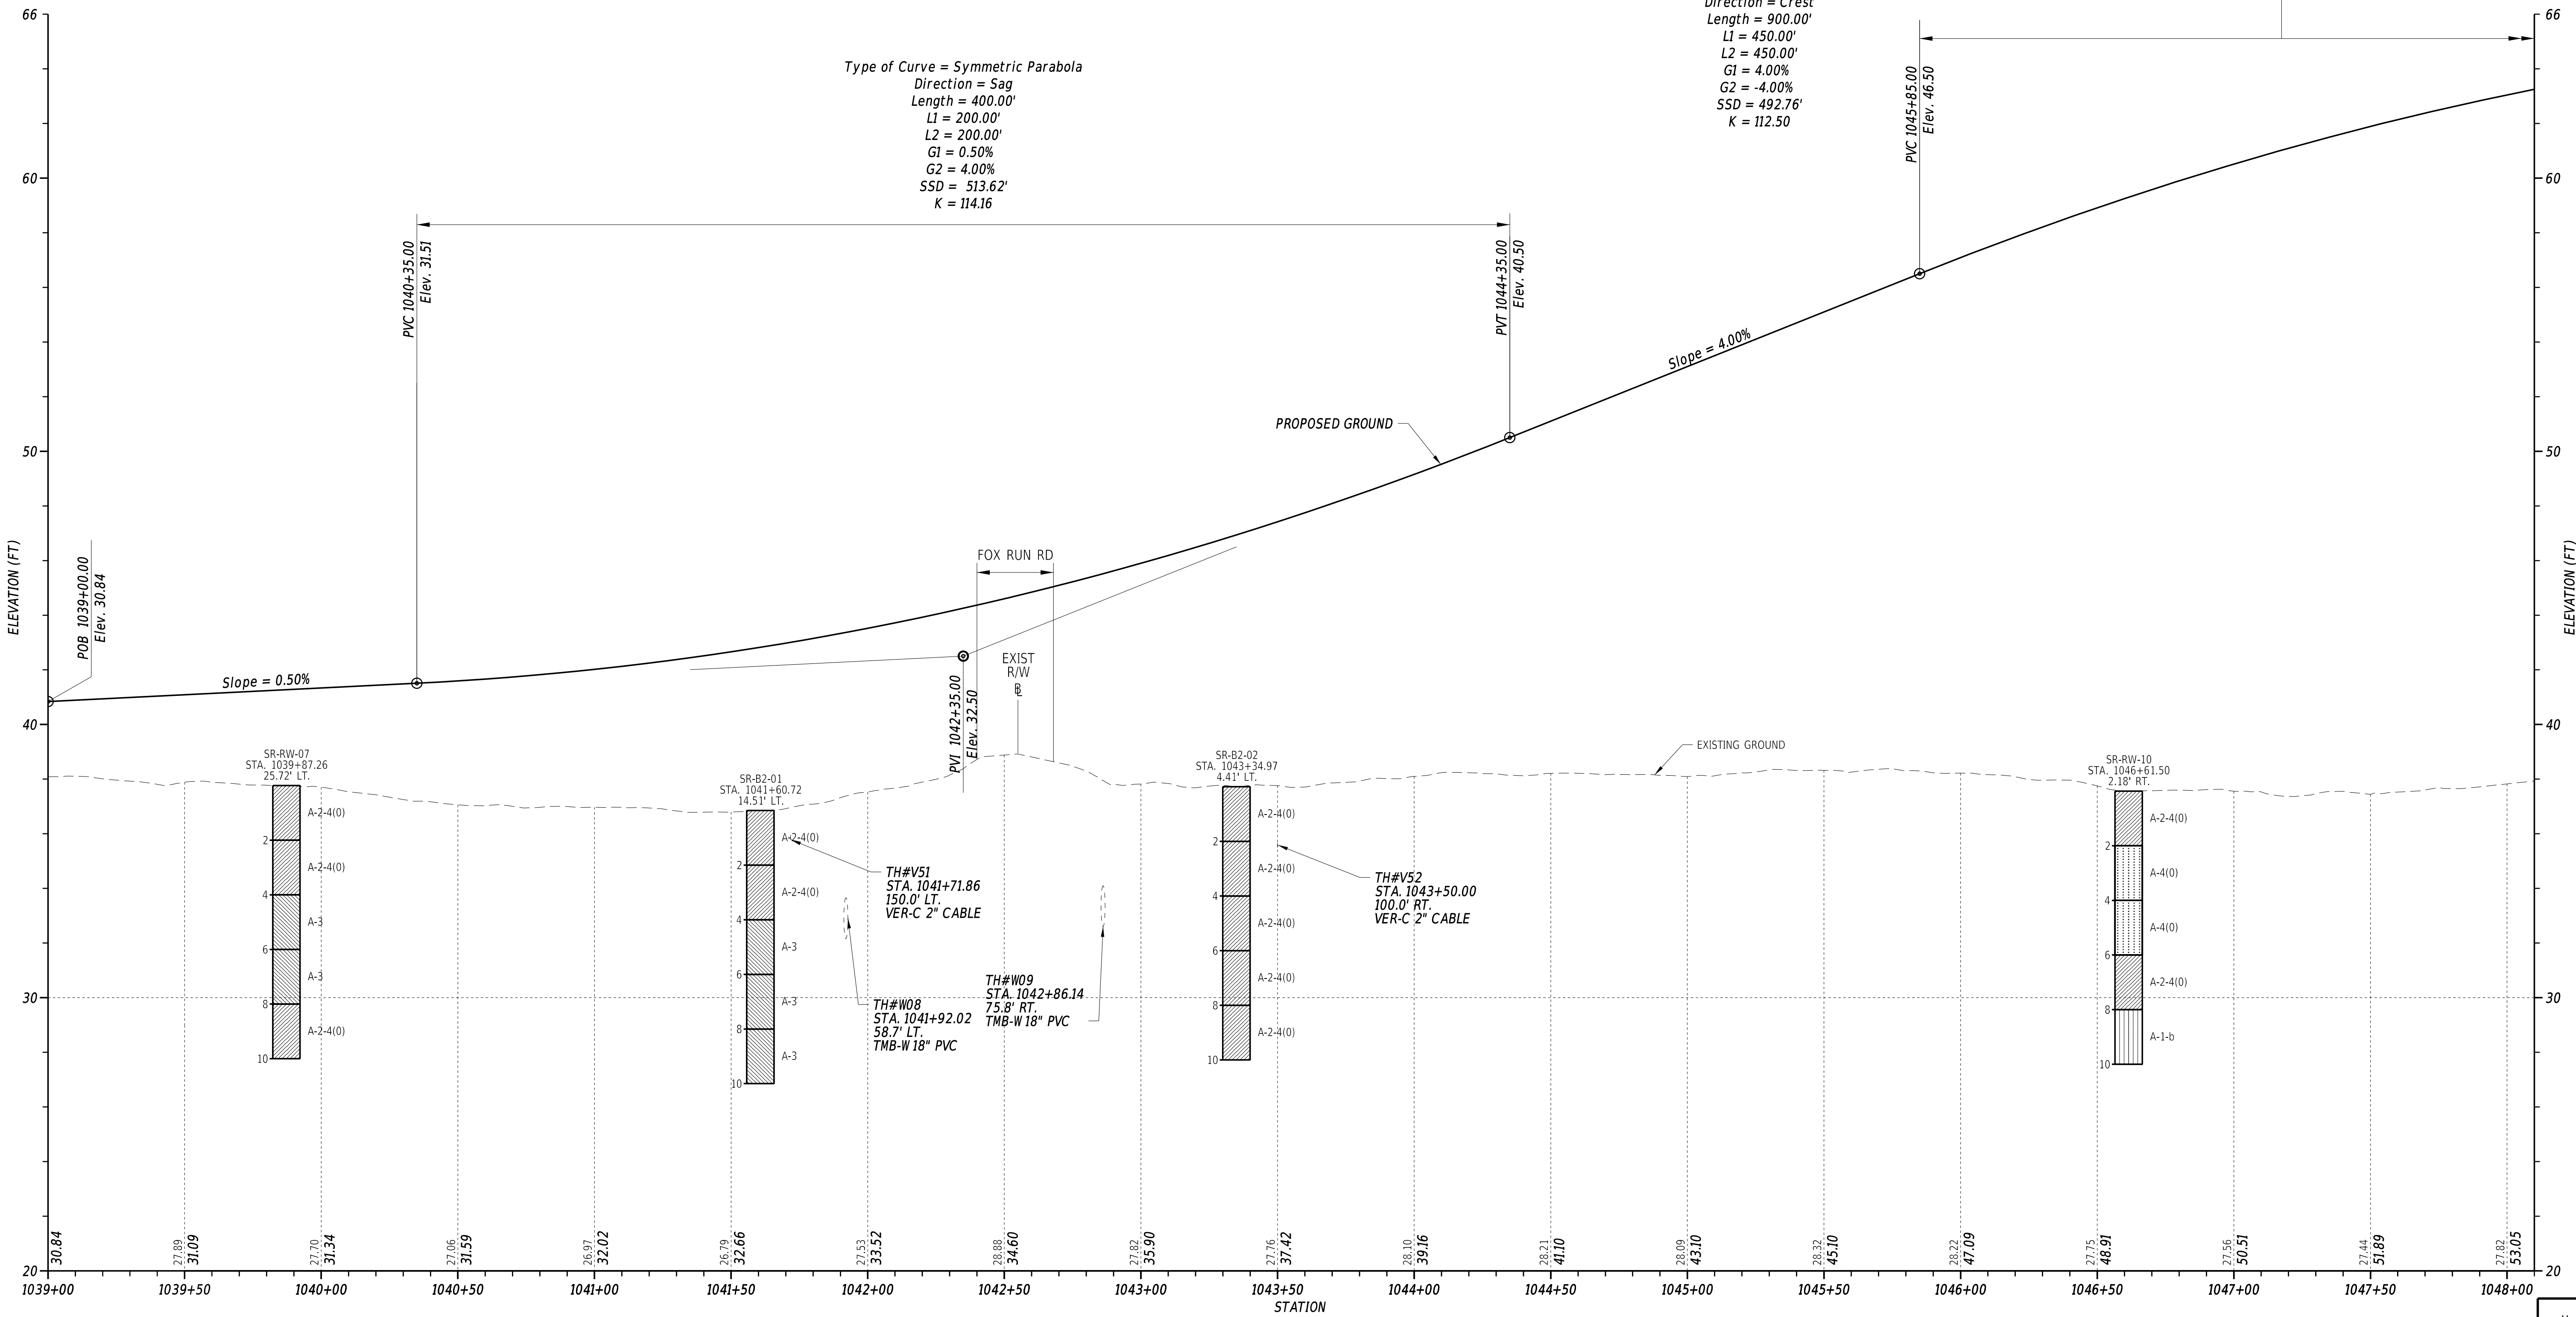

Type of Curve = Symmetric Parabola
Direction = Sag
Length = 400.00'
L1 = 200.00'
L2 = 200.00'
G1 = 0.50%
G2 = 4.00%
SSD = 513.62'
K = 114.16

Type of Curve = Symmetric Parabola
Direction = Crest
Length = 900.00'
L1 = 450.00'
L2 = 450.00'
G1 = 4.00%
G2 = -4.00%
SSD = 492.76'
K = 112.50

NORTH MILLSBORO BYPASS

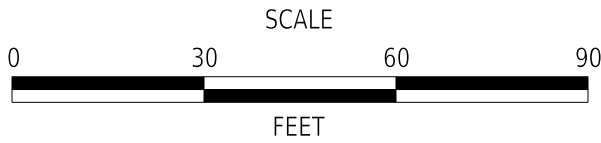

CM/GC,
NORTH MILLSBORO BYPASS,
US 113 TO SR 24

CONTRACT	BRIDGE NO.	N/A
T202112701	DESIGNED BY:	M. FOX
COUNTY	CHECKED BY:	T. OLIVER
SUSSEX		


PROFILE

VERTICAL
SCALE
FEET
0 3 6 9

ADDENDA / REVISIONS


SECTION
WRA
SHEET NO.
38

3/4/2022
6:13:51 PM
N:\32149-002\CADD\US 113 NM Bypass\PF02_NMBP.dgn

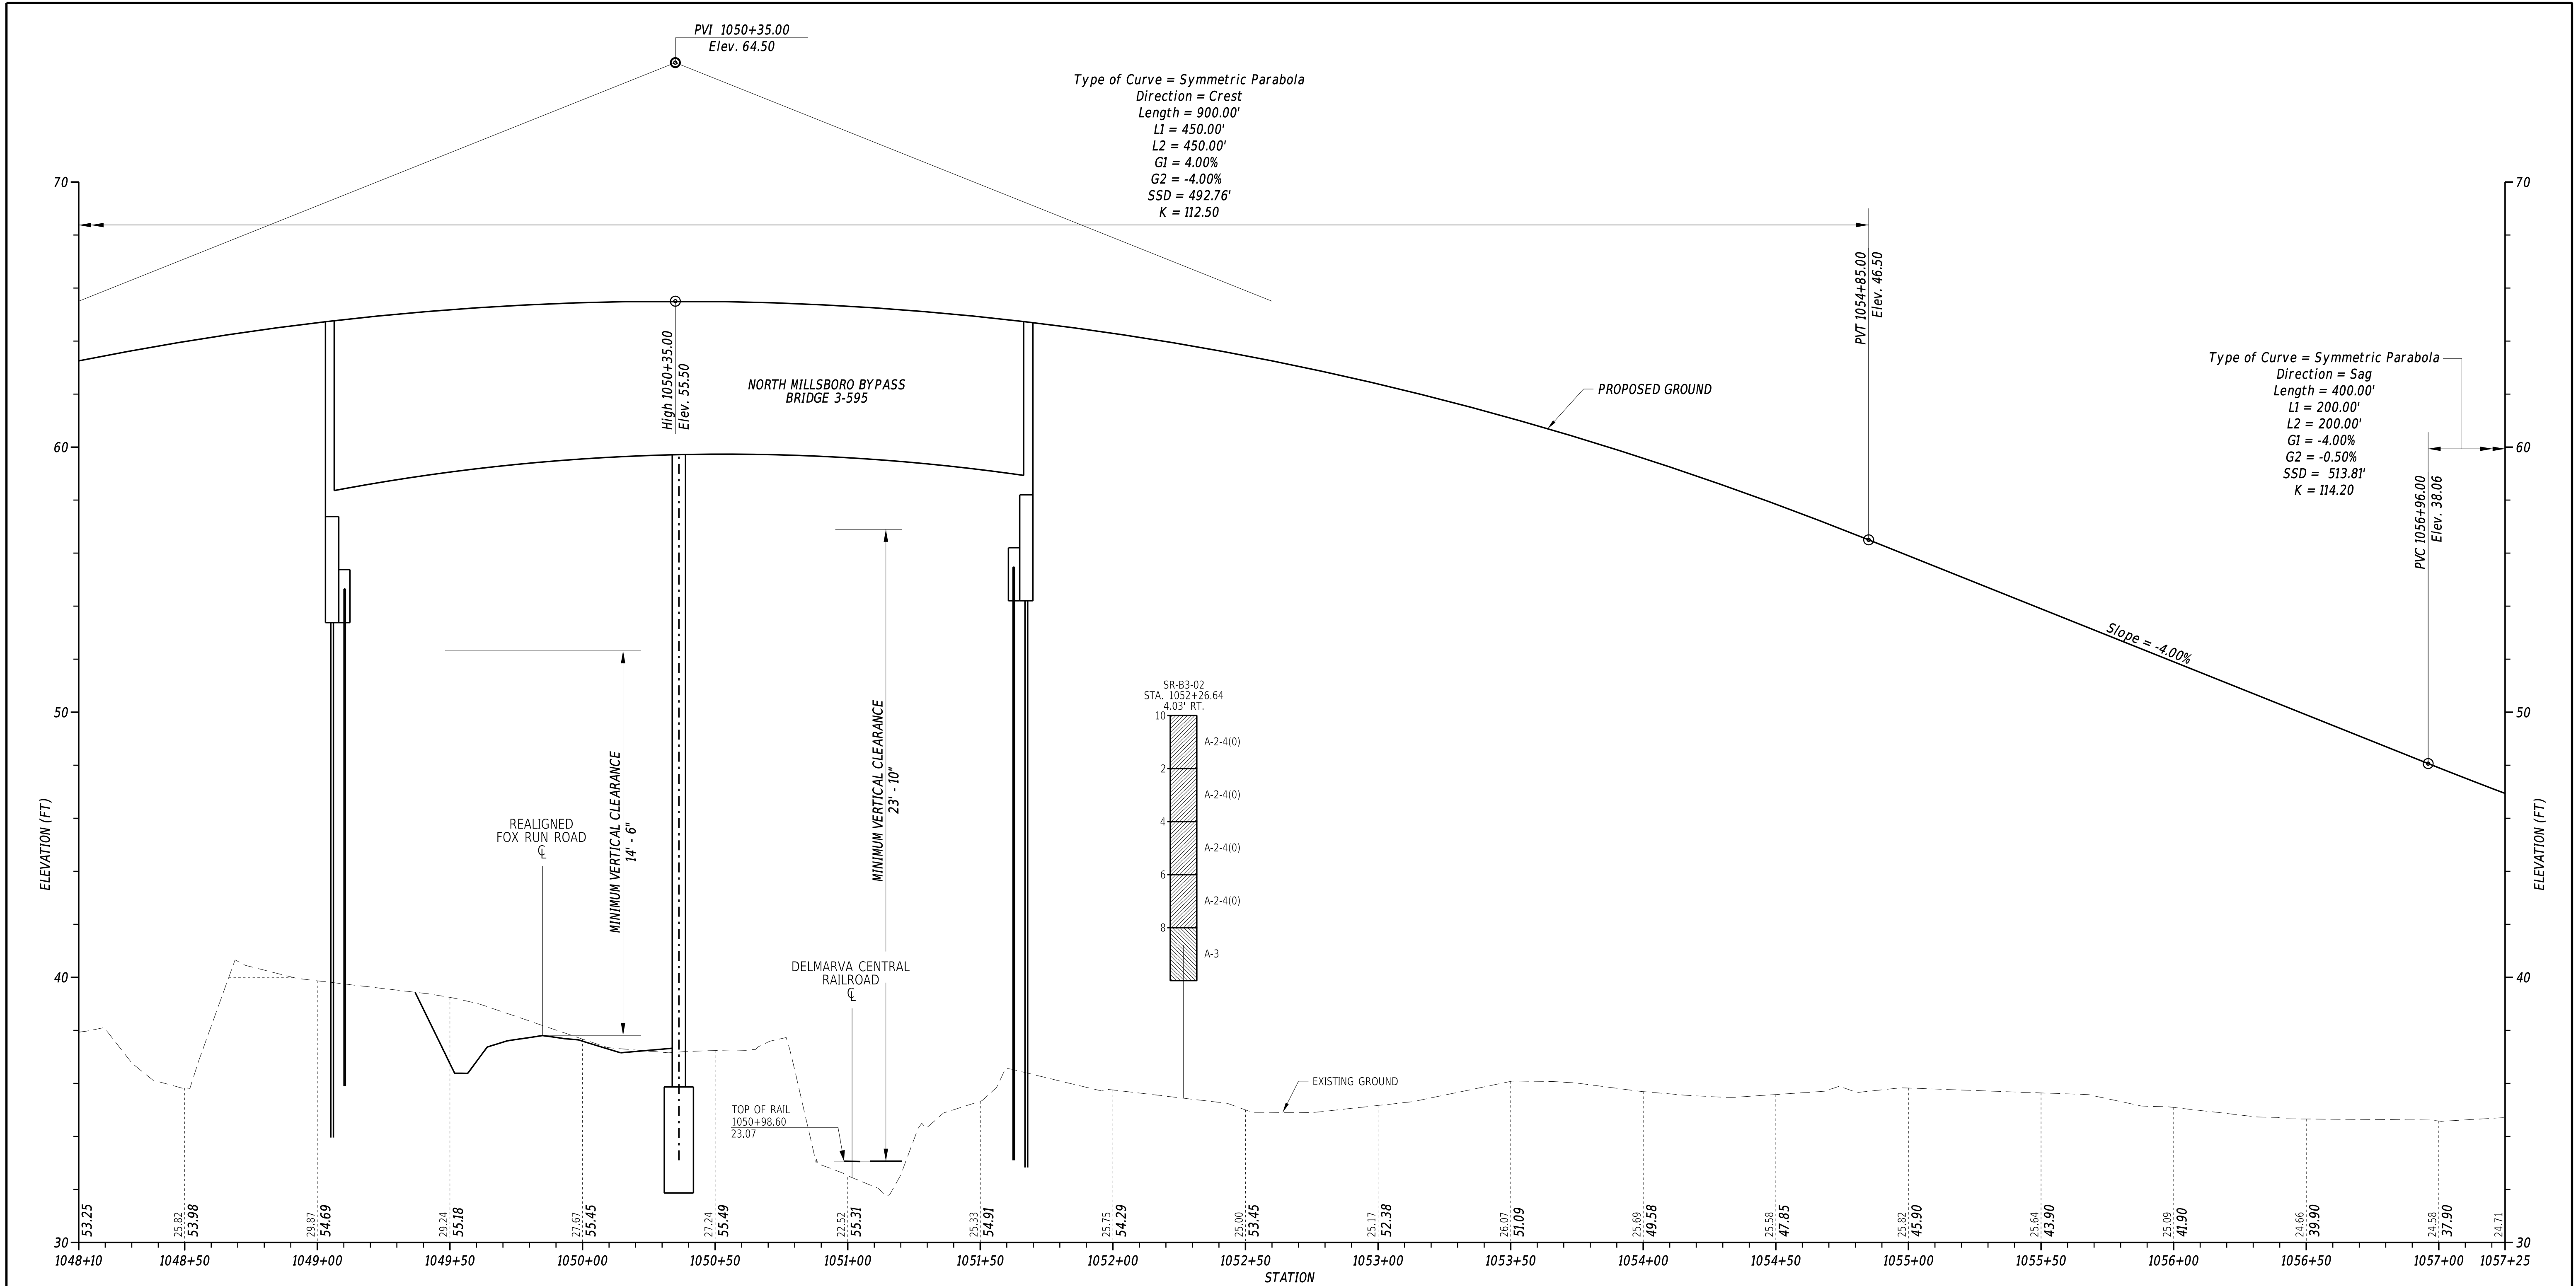

NORTH MILLSBORO BYPASS


ADDENDA / REVISIONS	

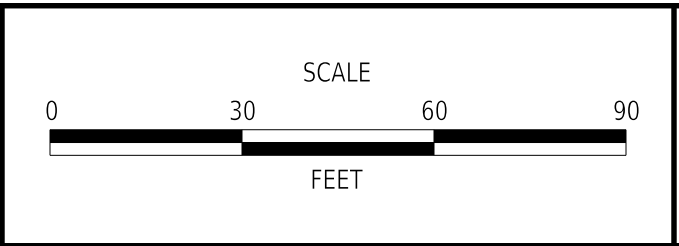


CM/GC,
NORTH MILLSBORO BYPASS,
US 113 TO SR 24

CONTRACT	BRIDGE NO.	3-595
T202112701	DESIGNED BY:	M. FOX
COUNTY	CHECKED BY:	T. OLIVER
SUSSEX		


SECTION
WRA
SHEET NO.
39

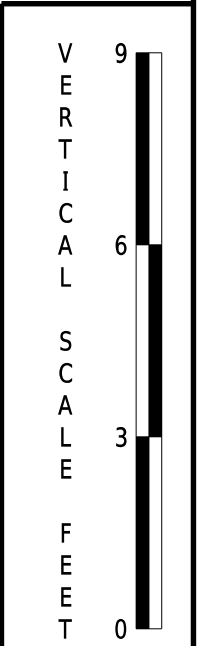


Type of Curve = Symmetric Parabola
Direction = Sag
Length = 400.00'
L1 = 200.00'
L2 = 200.00'
G1 = -4.00%
G2 = -0.50%
SSD = 513.81'
K = 114.20

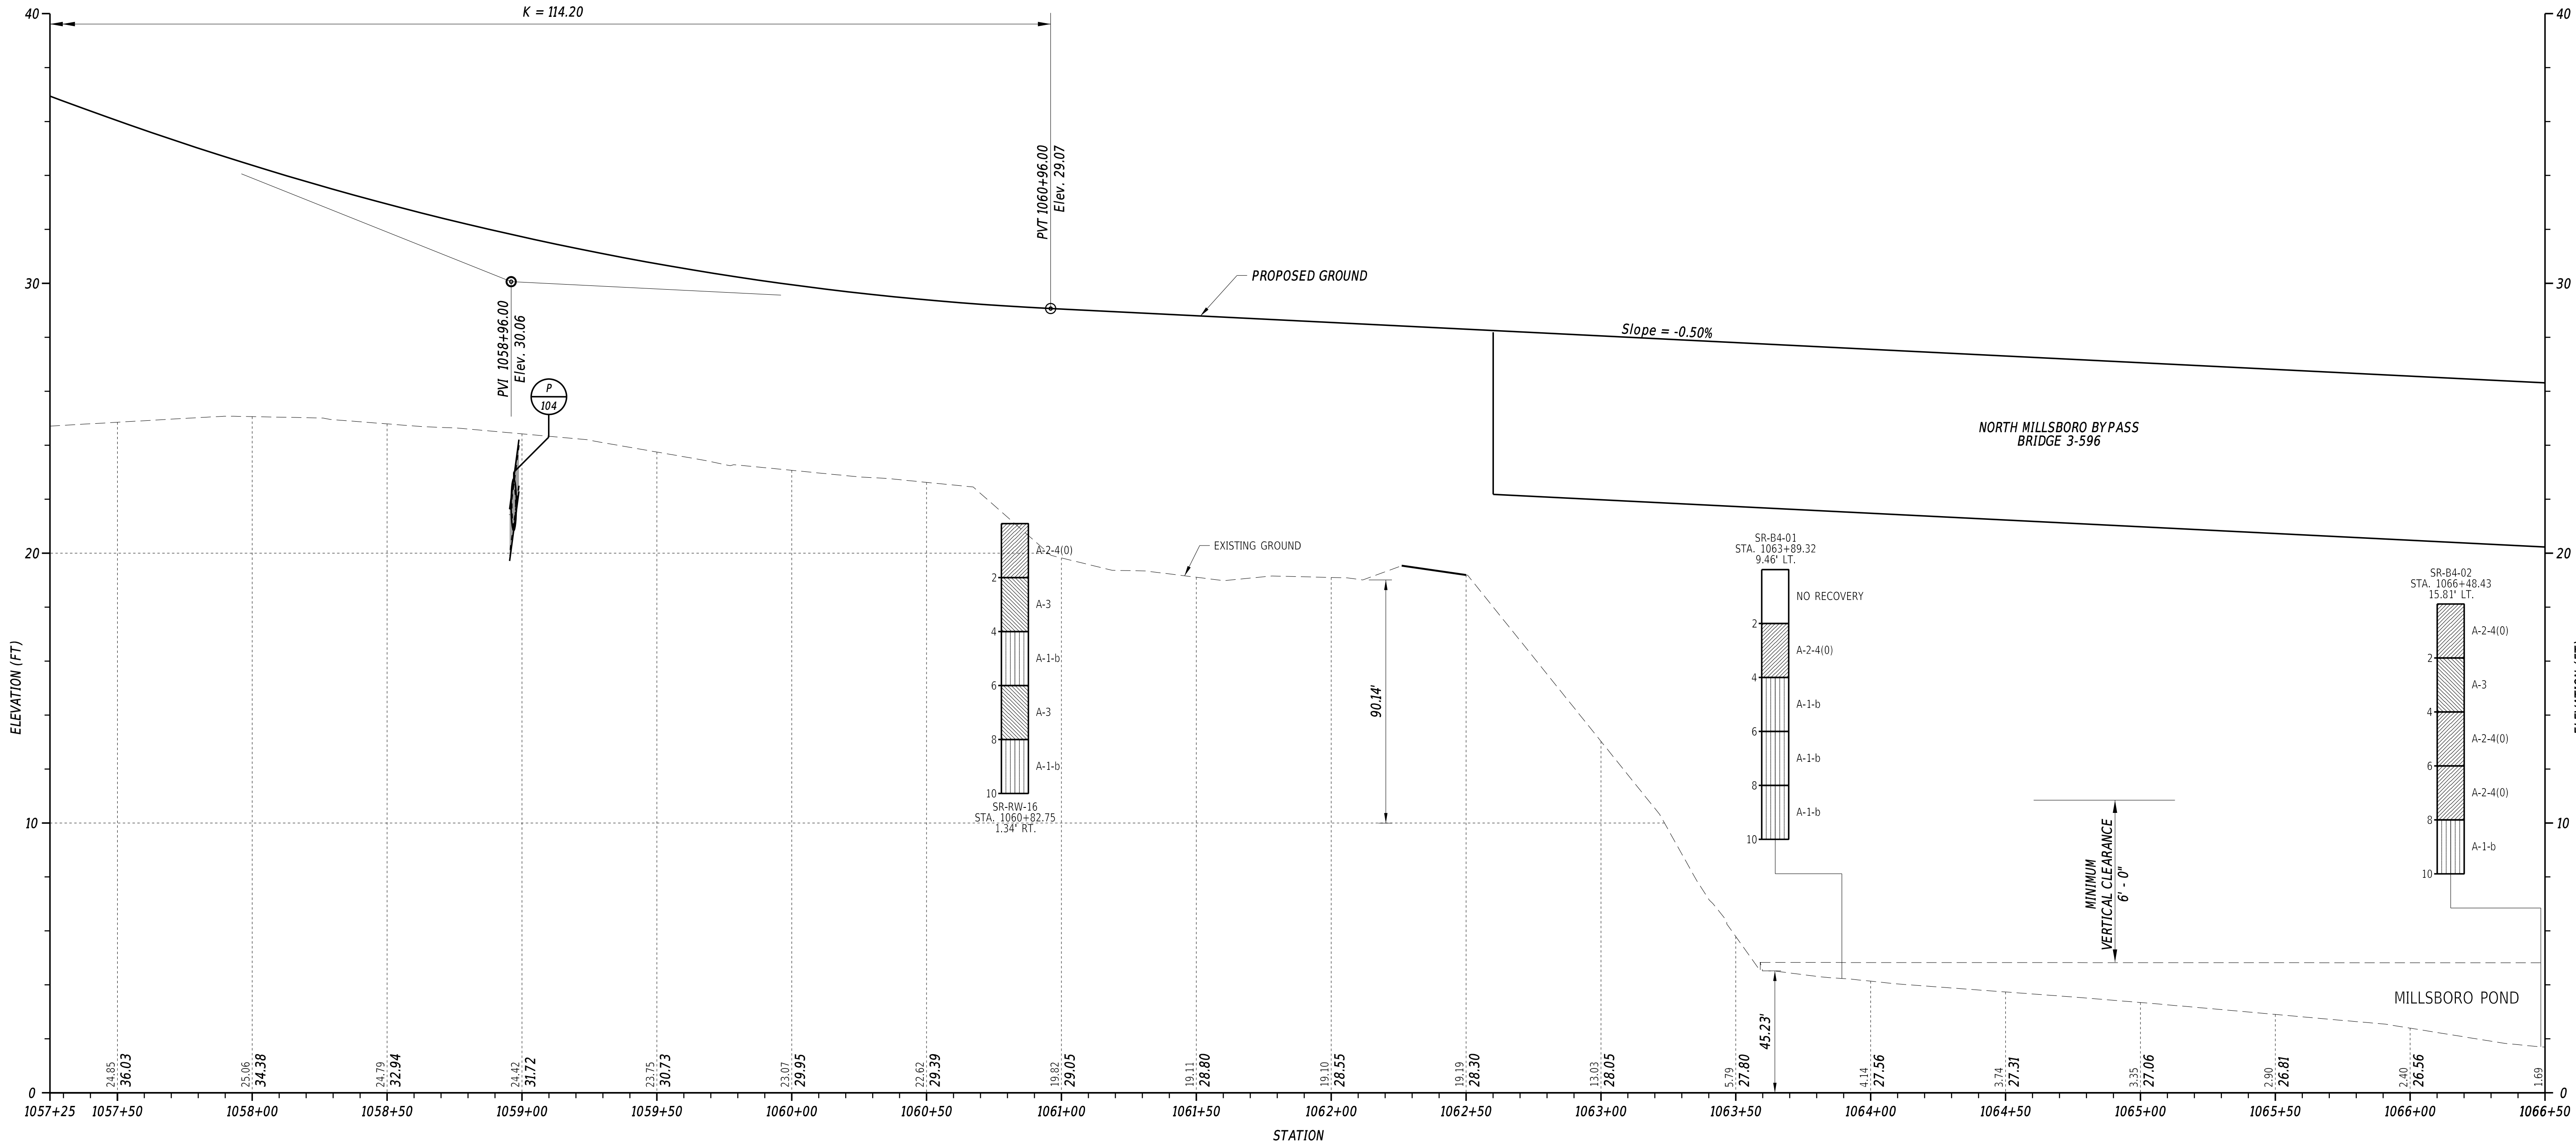

NORTH MILLSBORO BYPASS

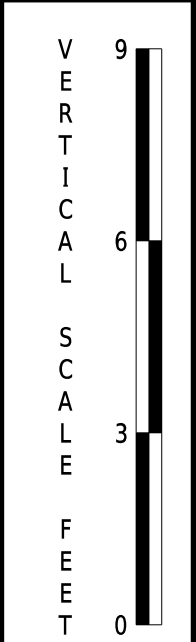

ADDENDA / REVISIONS

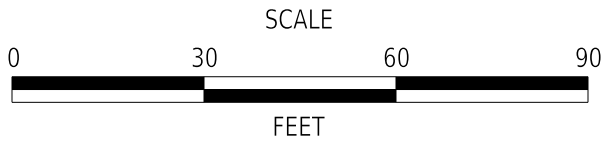


CM/GC,
NORTH MILLSBORO BYPASS,
US 113 TO SR 24

CONTRACT	BRIDGE NO.	3-596
T202112701	DESIGNED BY:	M. FOX
COUNTY	CHECKED BY:	T. OLIVER
SUSSEX		

PROFILE


SECTION
WRA
SHEET NO.
40

3/4/2022
6:13:53 PM
N:\32149-002\CADD\US 113 NM Bypass\PE04_NMBP.dgn

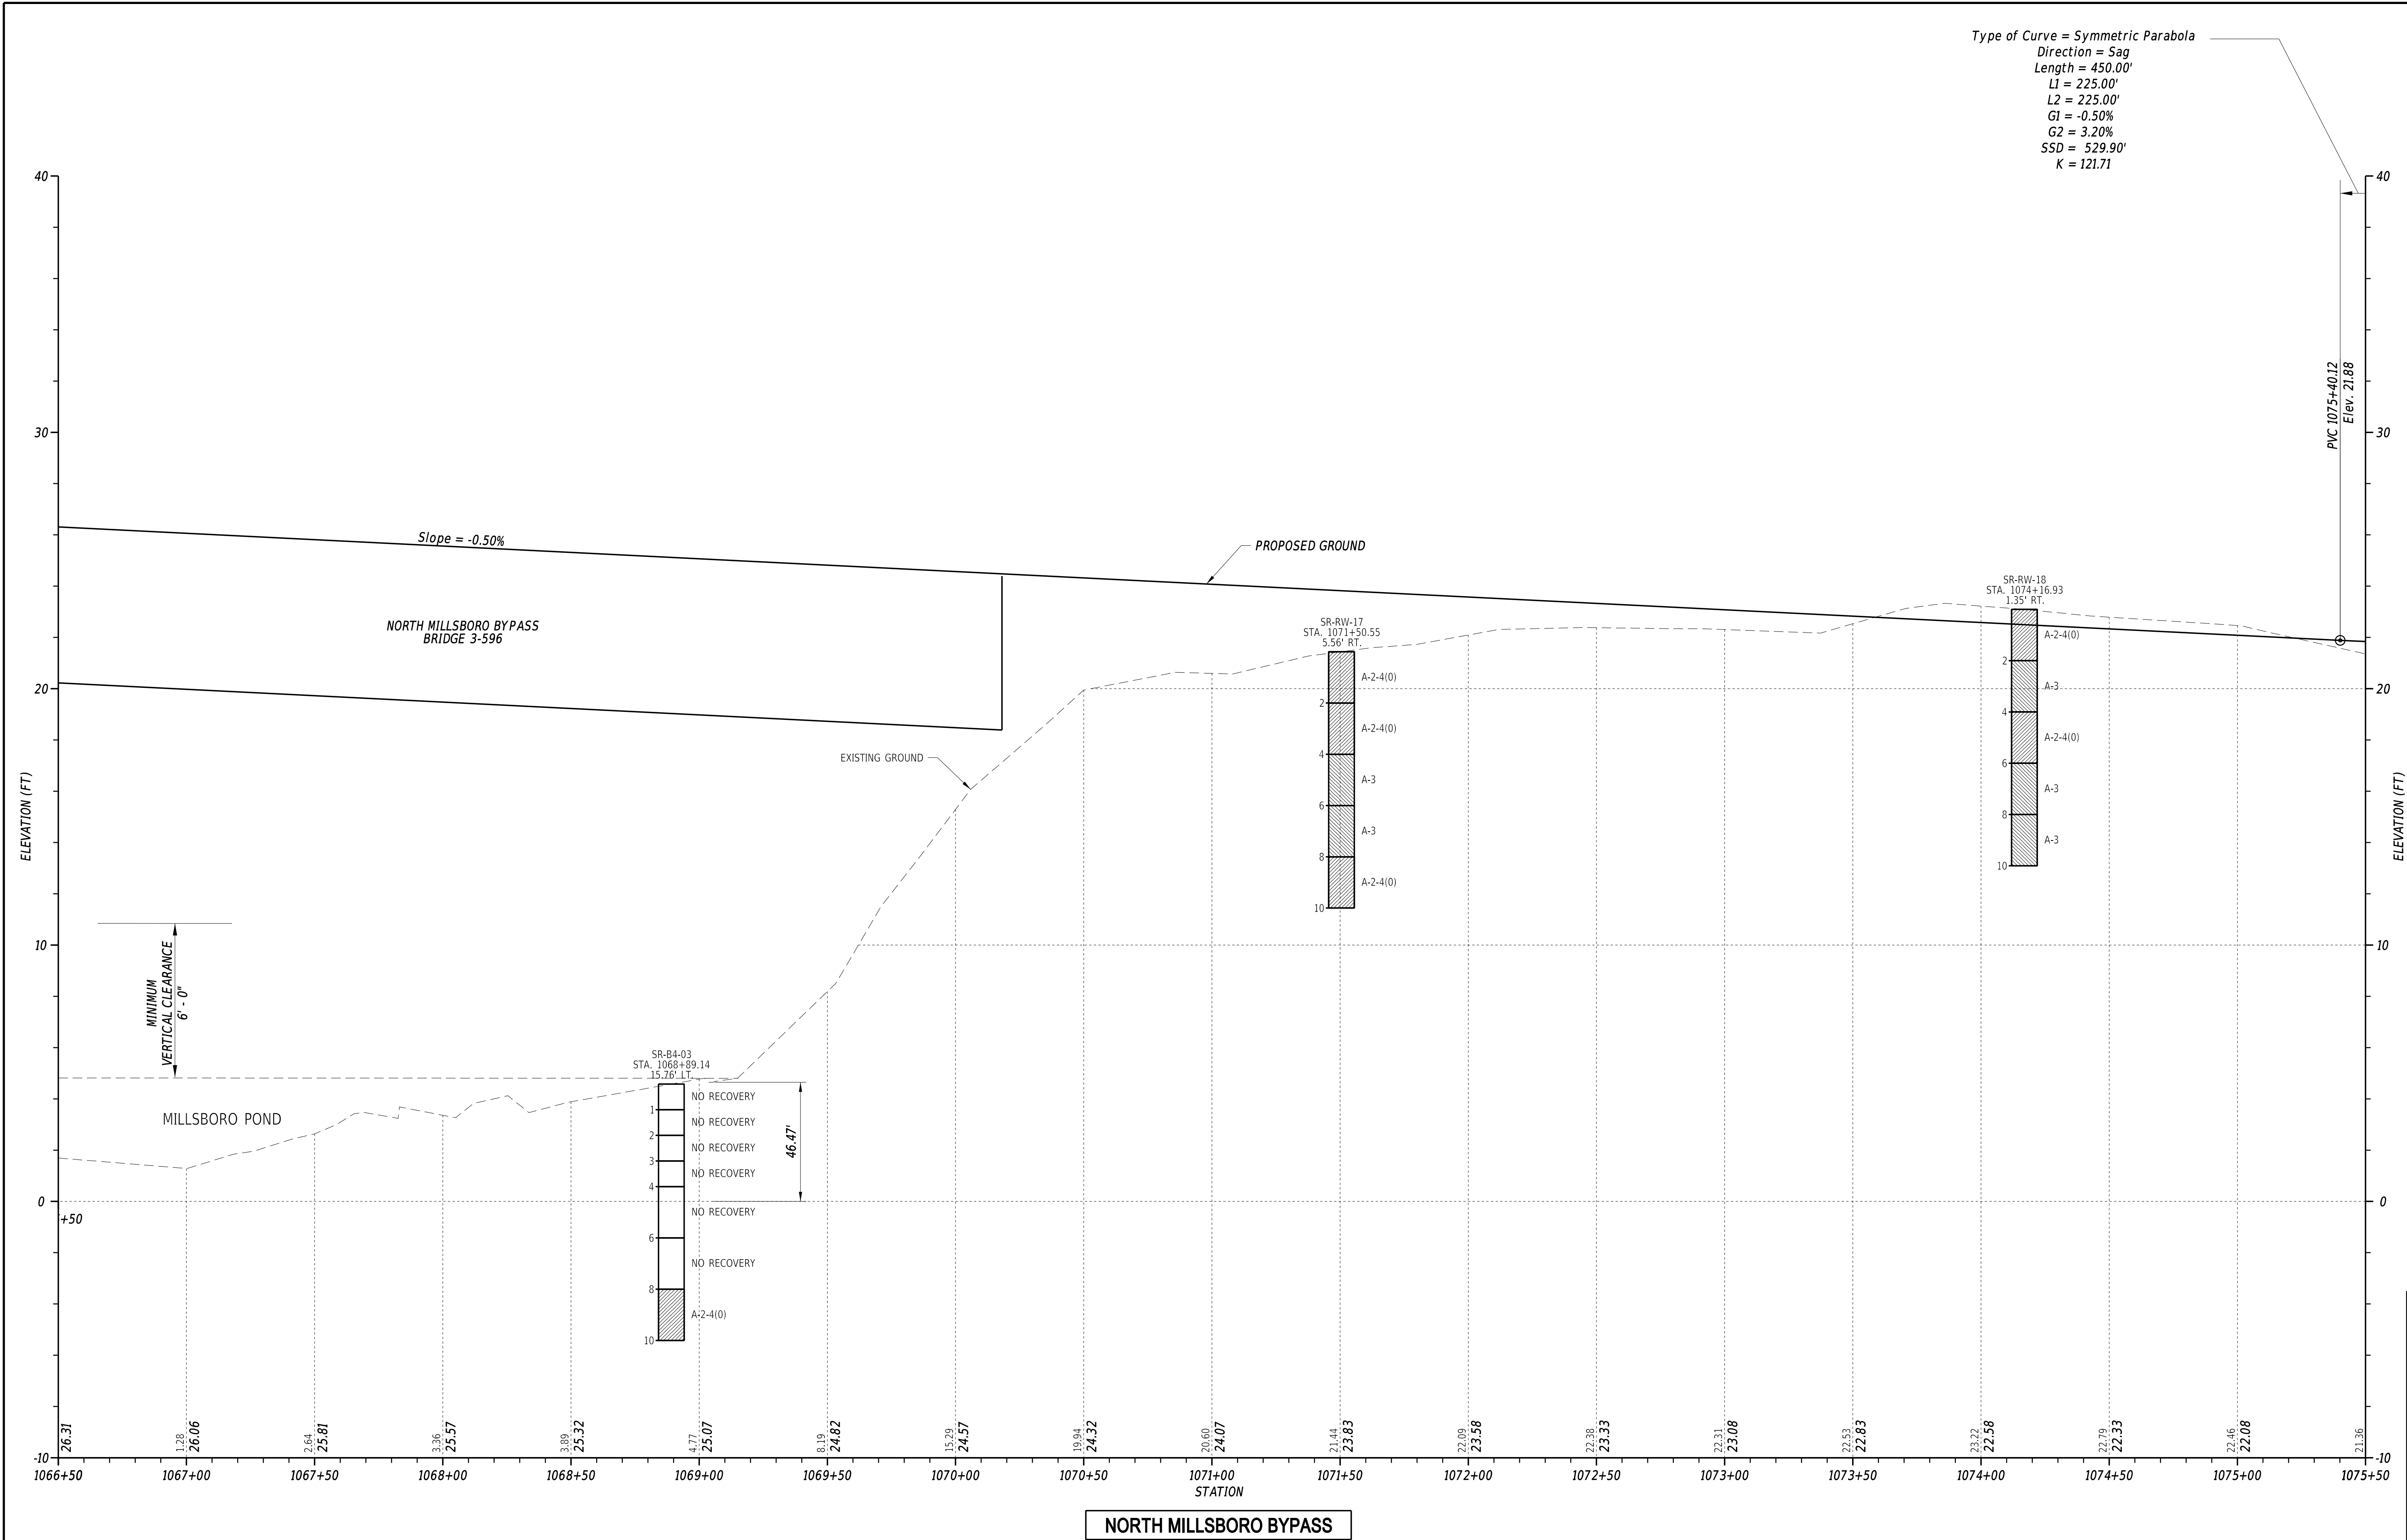

Type of Curve = Symmetric Parabola
Direction = Sag
Length = 450.00'
L1 = 225.00'
L2 = 225.00'
G1 = -0.50%
G2 = 3.20%
SSD = 529.90'
K = 121.71

ADDENDA / REVISIONS	

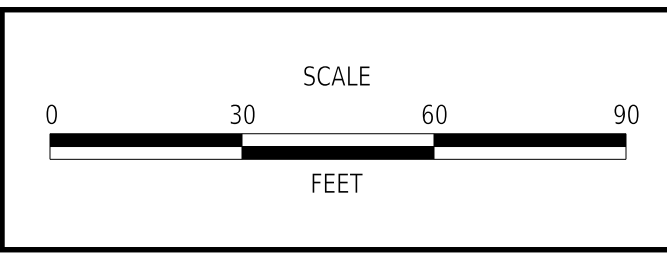


CM/GC,
NORTH MILLSBORO BYPASS,
US 113 TO SR 24


CONTRACT	BRIDGE NO.	3-596
T202112701	DESIGNED BY:	M. FOX
COUNTY	CHECKED BY:	T. OLIVER
SUSSEX		

SECTION
WRA
SHEET NO.
41

3/1/2022
6:13:54 PM
N:\32149-002\CADD\US 113 NM Bypass\PE05_NMBP.dgn

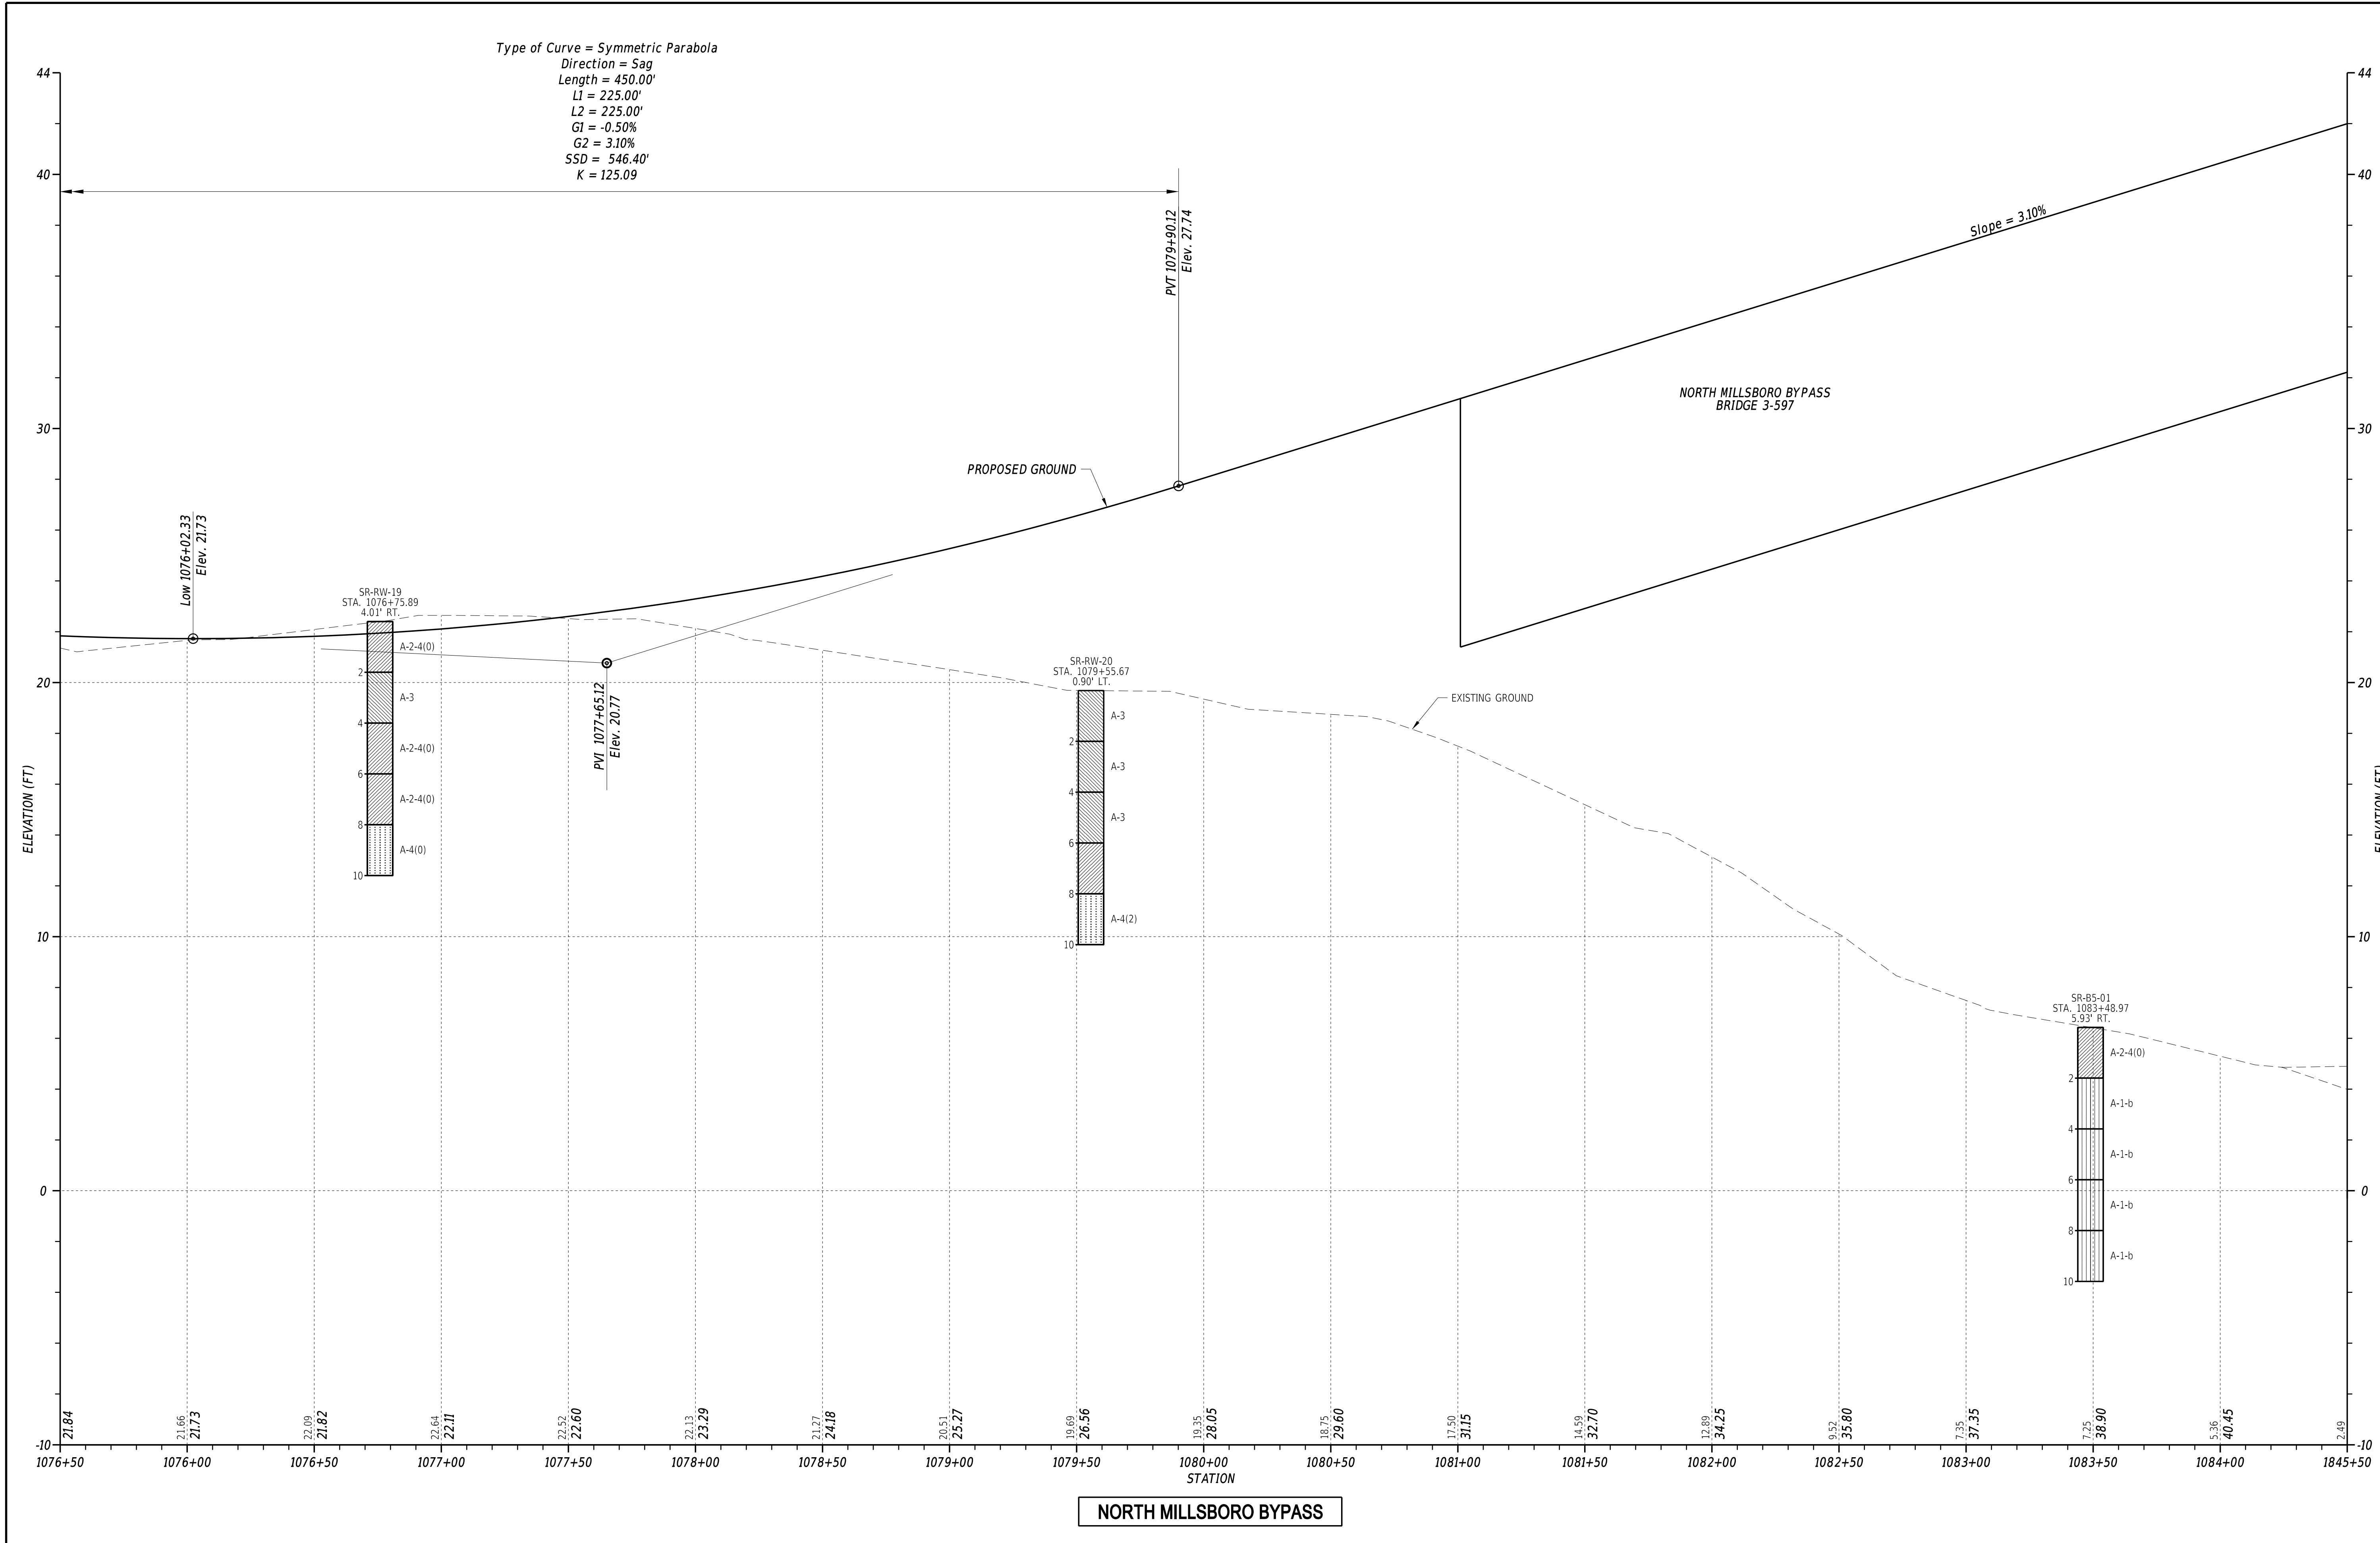


ADDENDA / REVISIONS	

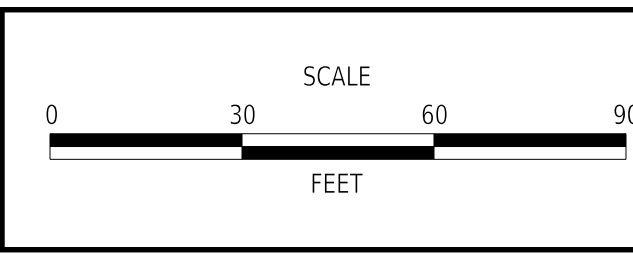


CM/GC,
NORTH MILLSBORO BYPASS,
US 113 TO SR 24

CONTRACT	BRIDGE NO.	3-597
T202112701	DESIGNED BY: M. FOX	
COUNTY	CHECKED BY: T. OLIVER	
SUSSEX		


PROFILE	SECTION
	WRA
	SHEET NO. 42

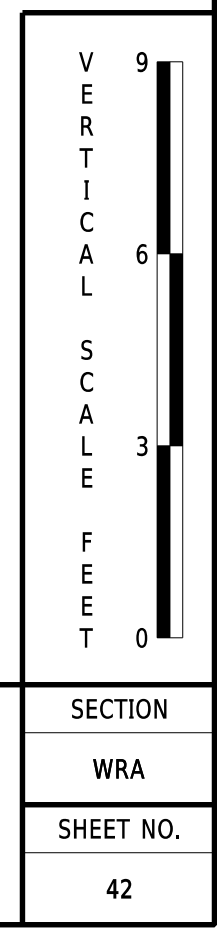

3/4/2022
6:13:54 PM
N:\32149-002\CADD\US 113 NM Bypass\PE06_NMBP.dgn

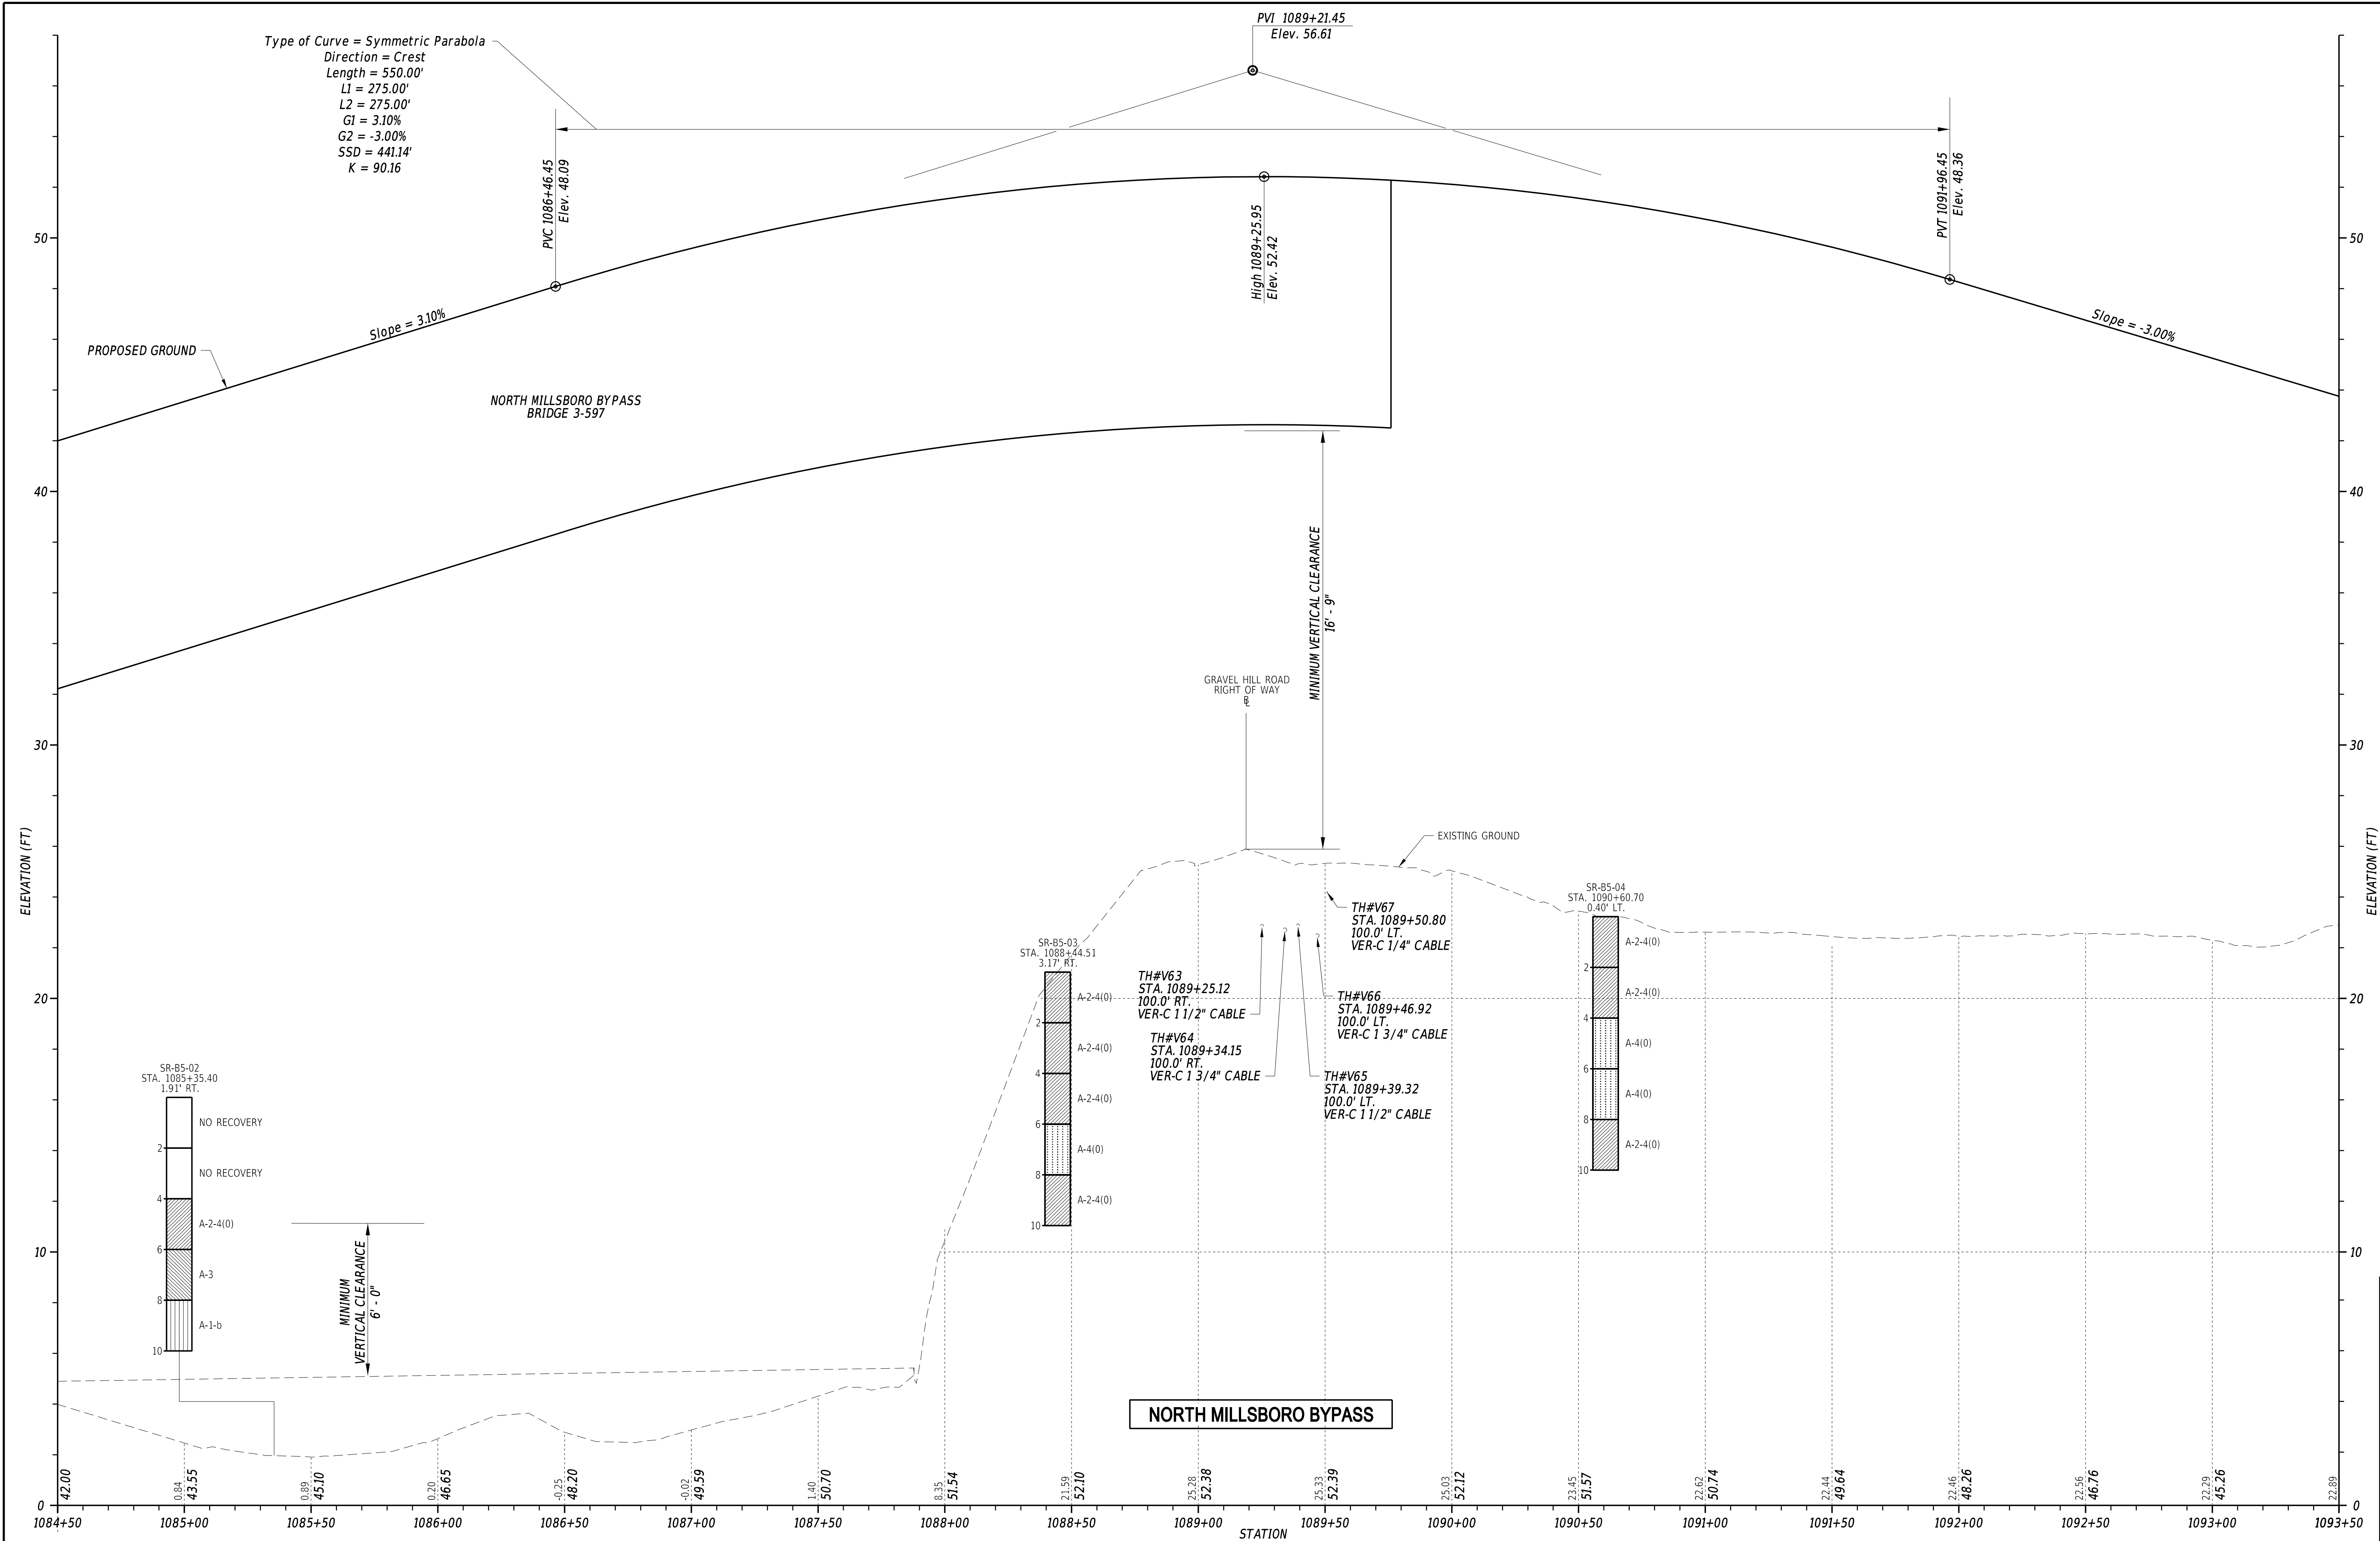


ADDENDA / REVISIONS	

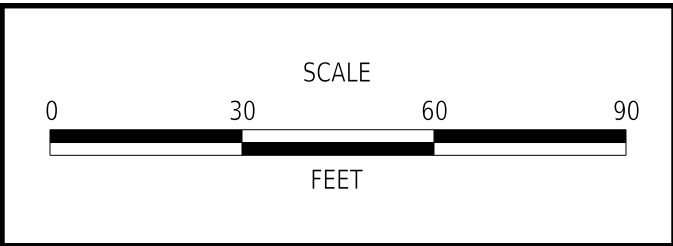


CM/GC,
NORTH MILLSBORO BYPASS,
US 113 TO SR 24

CONTRACT	BRIDGE NO.	3-597
T202112701	DESIGNED BY:	M. FOX
COUNTY	CHECKED BY:	T. OLIVER
SUSSEX		


PROFILE	
SECTION	WRA
SHEET NO.	43

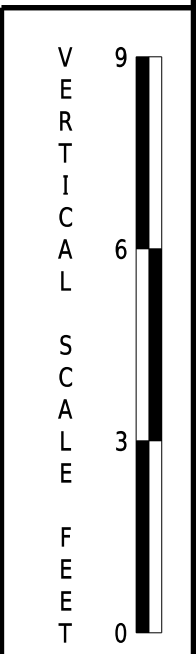

3/12/2022
6:13:55 PM
N:\32149-002\CADD\US 113 NM Bypass\PE07_NMBP.dgn

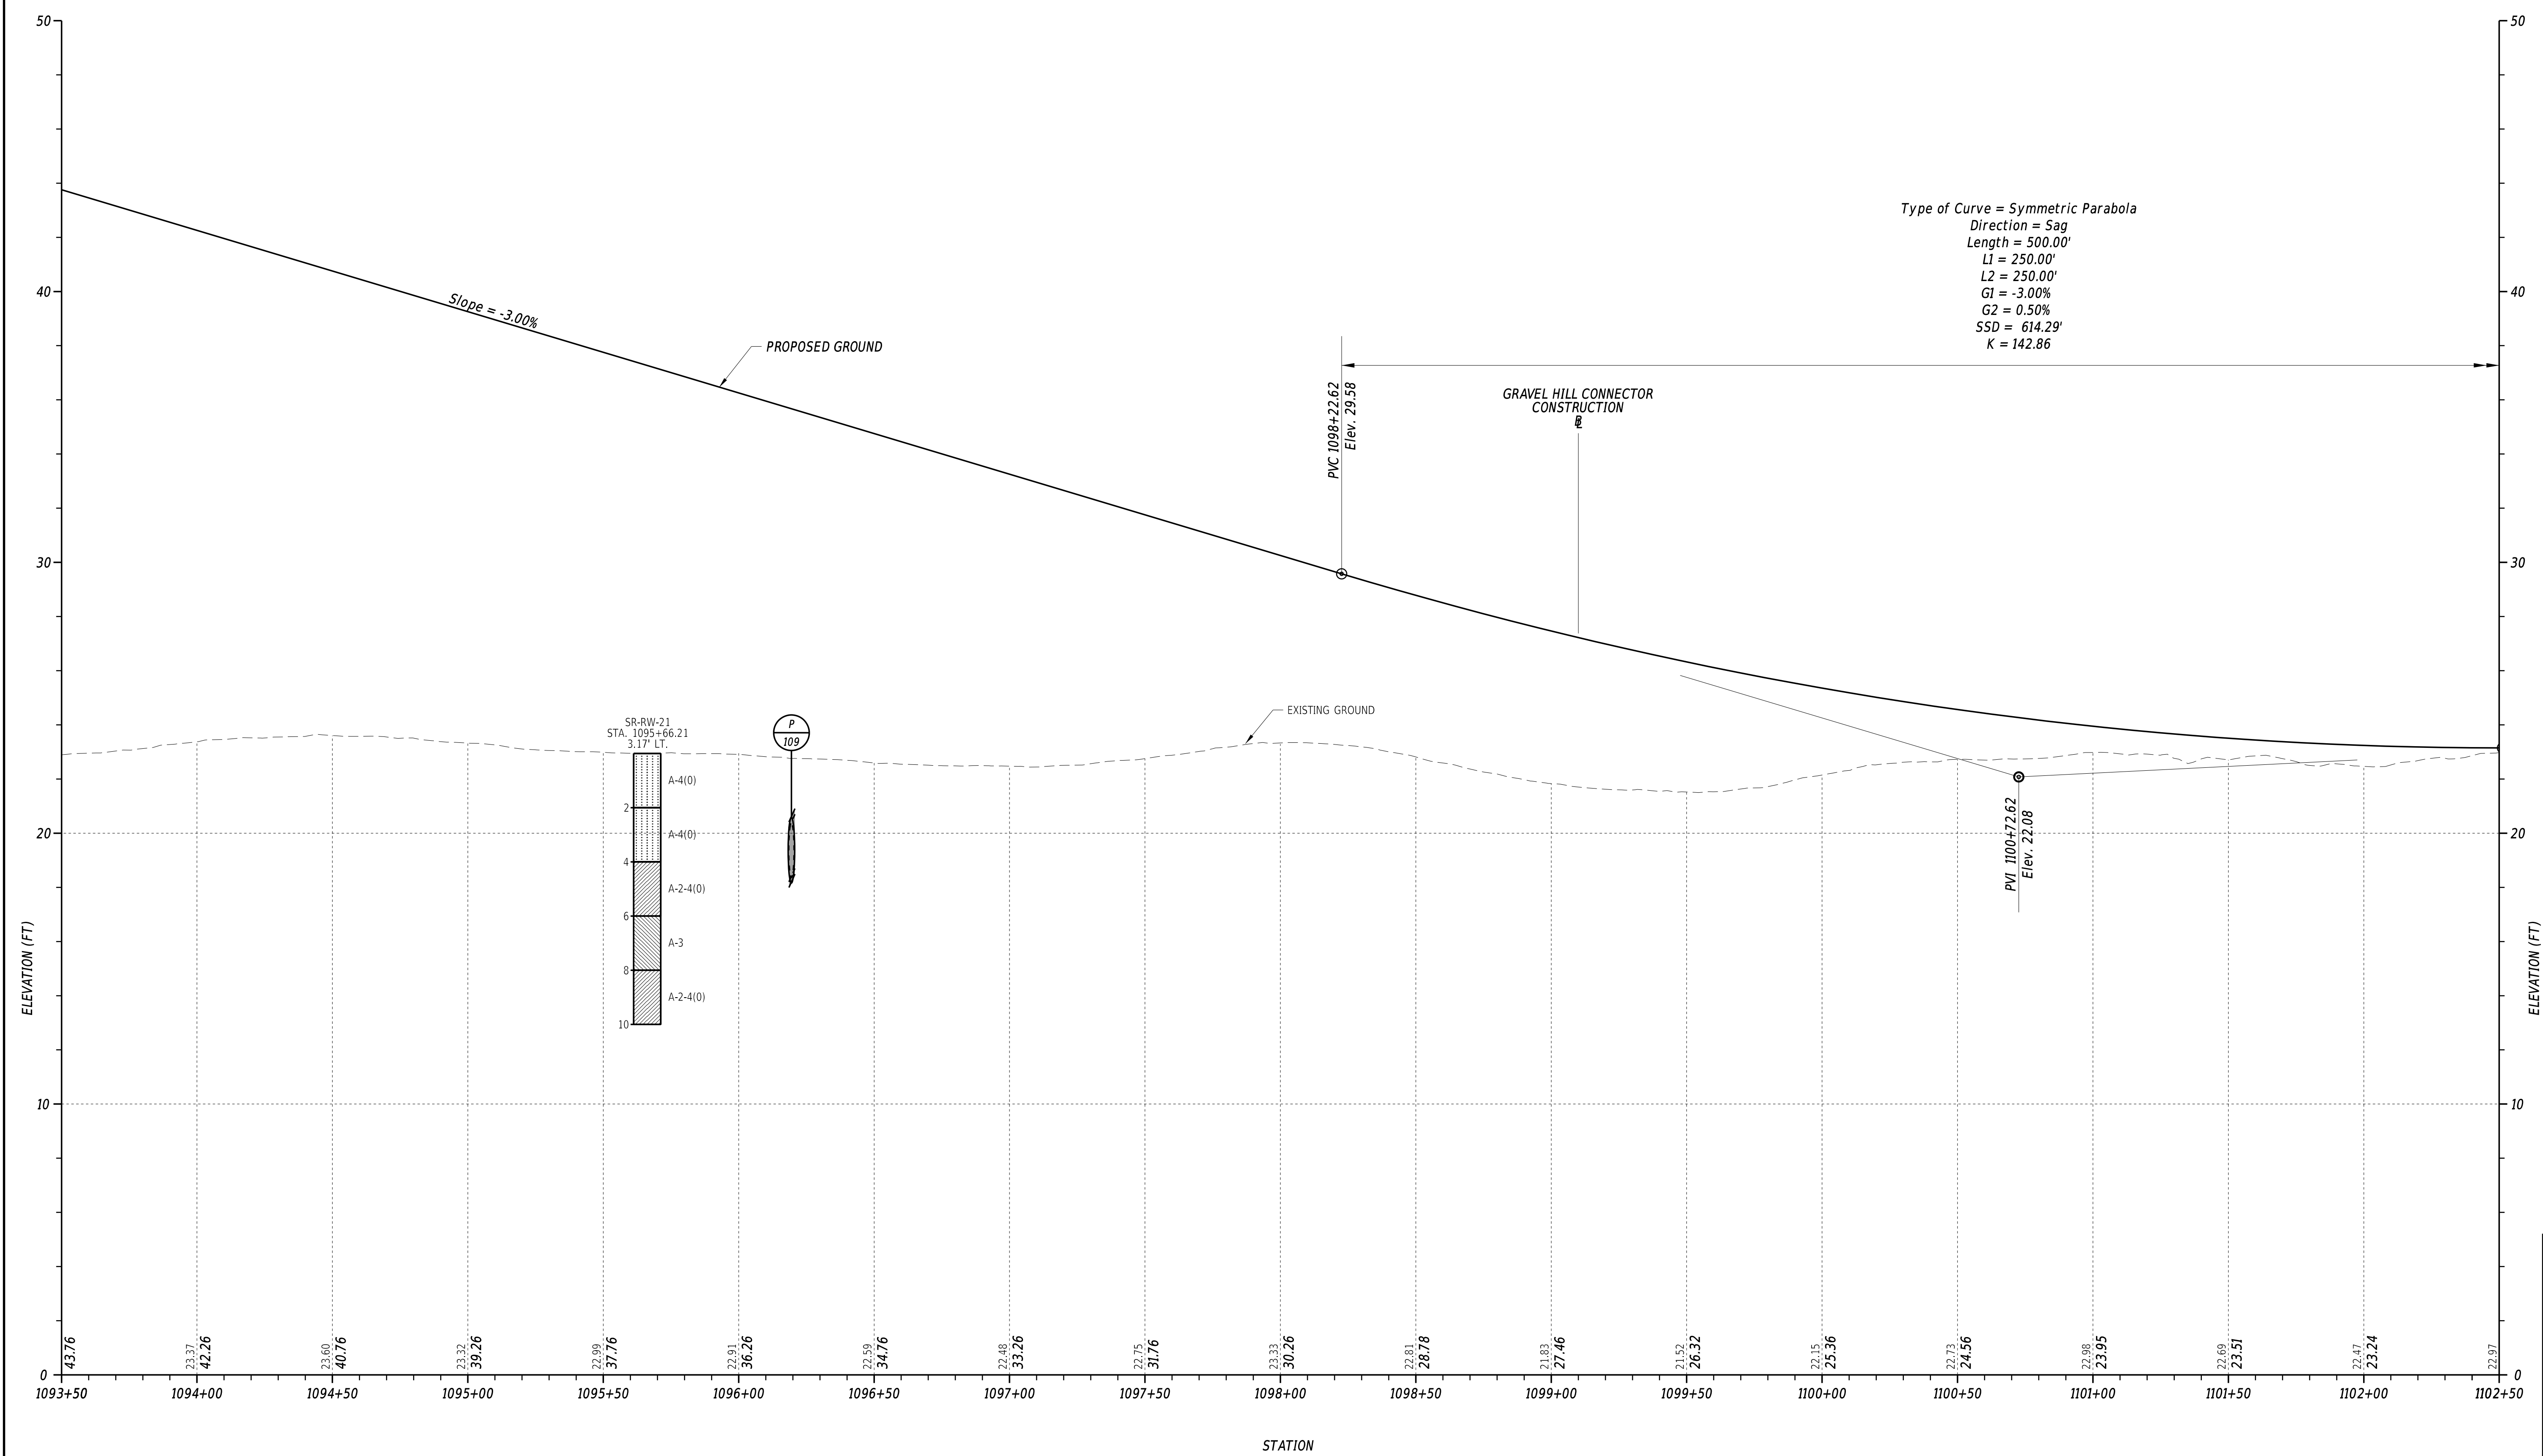


NORTH MILLSBORO BYPASS

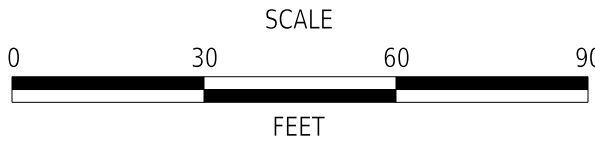

CM/GC,
NORTH MILLSBORO BYPASS,
US 113 TO SR 24

CONTRACT	BRIDGE NO.	N/A
T202112701	DESIGNED BY: M. FOX	
COUNTY	CHECKED BY: T. OLIVER	
SUSSEX		


PROFILE

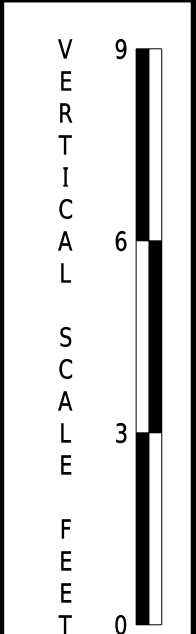


SECTION
WRA
SHEET NO.
44

Type of Curve = Symmetric Parabola
Direction = Sag
Length = 500.00'
L1 = 250.00'
L2 = 250.00'
G1 = -3.00%
G2 = 0.50%
SSD = 614.29'
K = 142.86


Type of Curve = Symmetric Parabola
Direction = Crest
Length = 400.00'
L1 = 200.00'
L2 = 200.00'
G1 = 0.50%
G2 = -0.50%
SSD = 1279.15'
K = 400.00

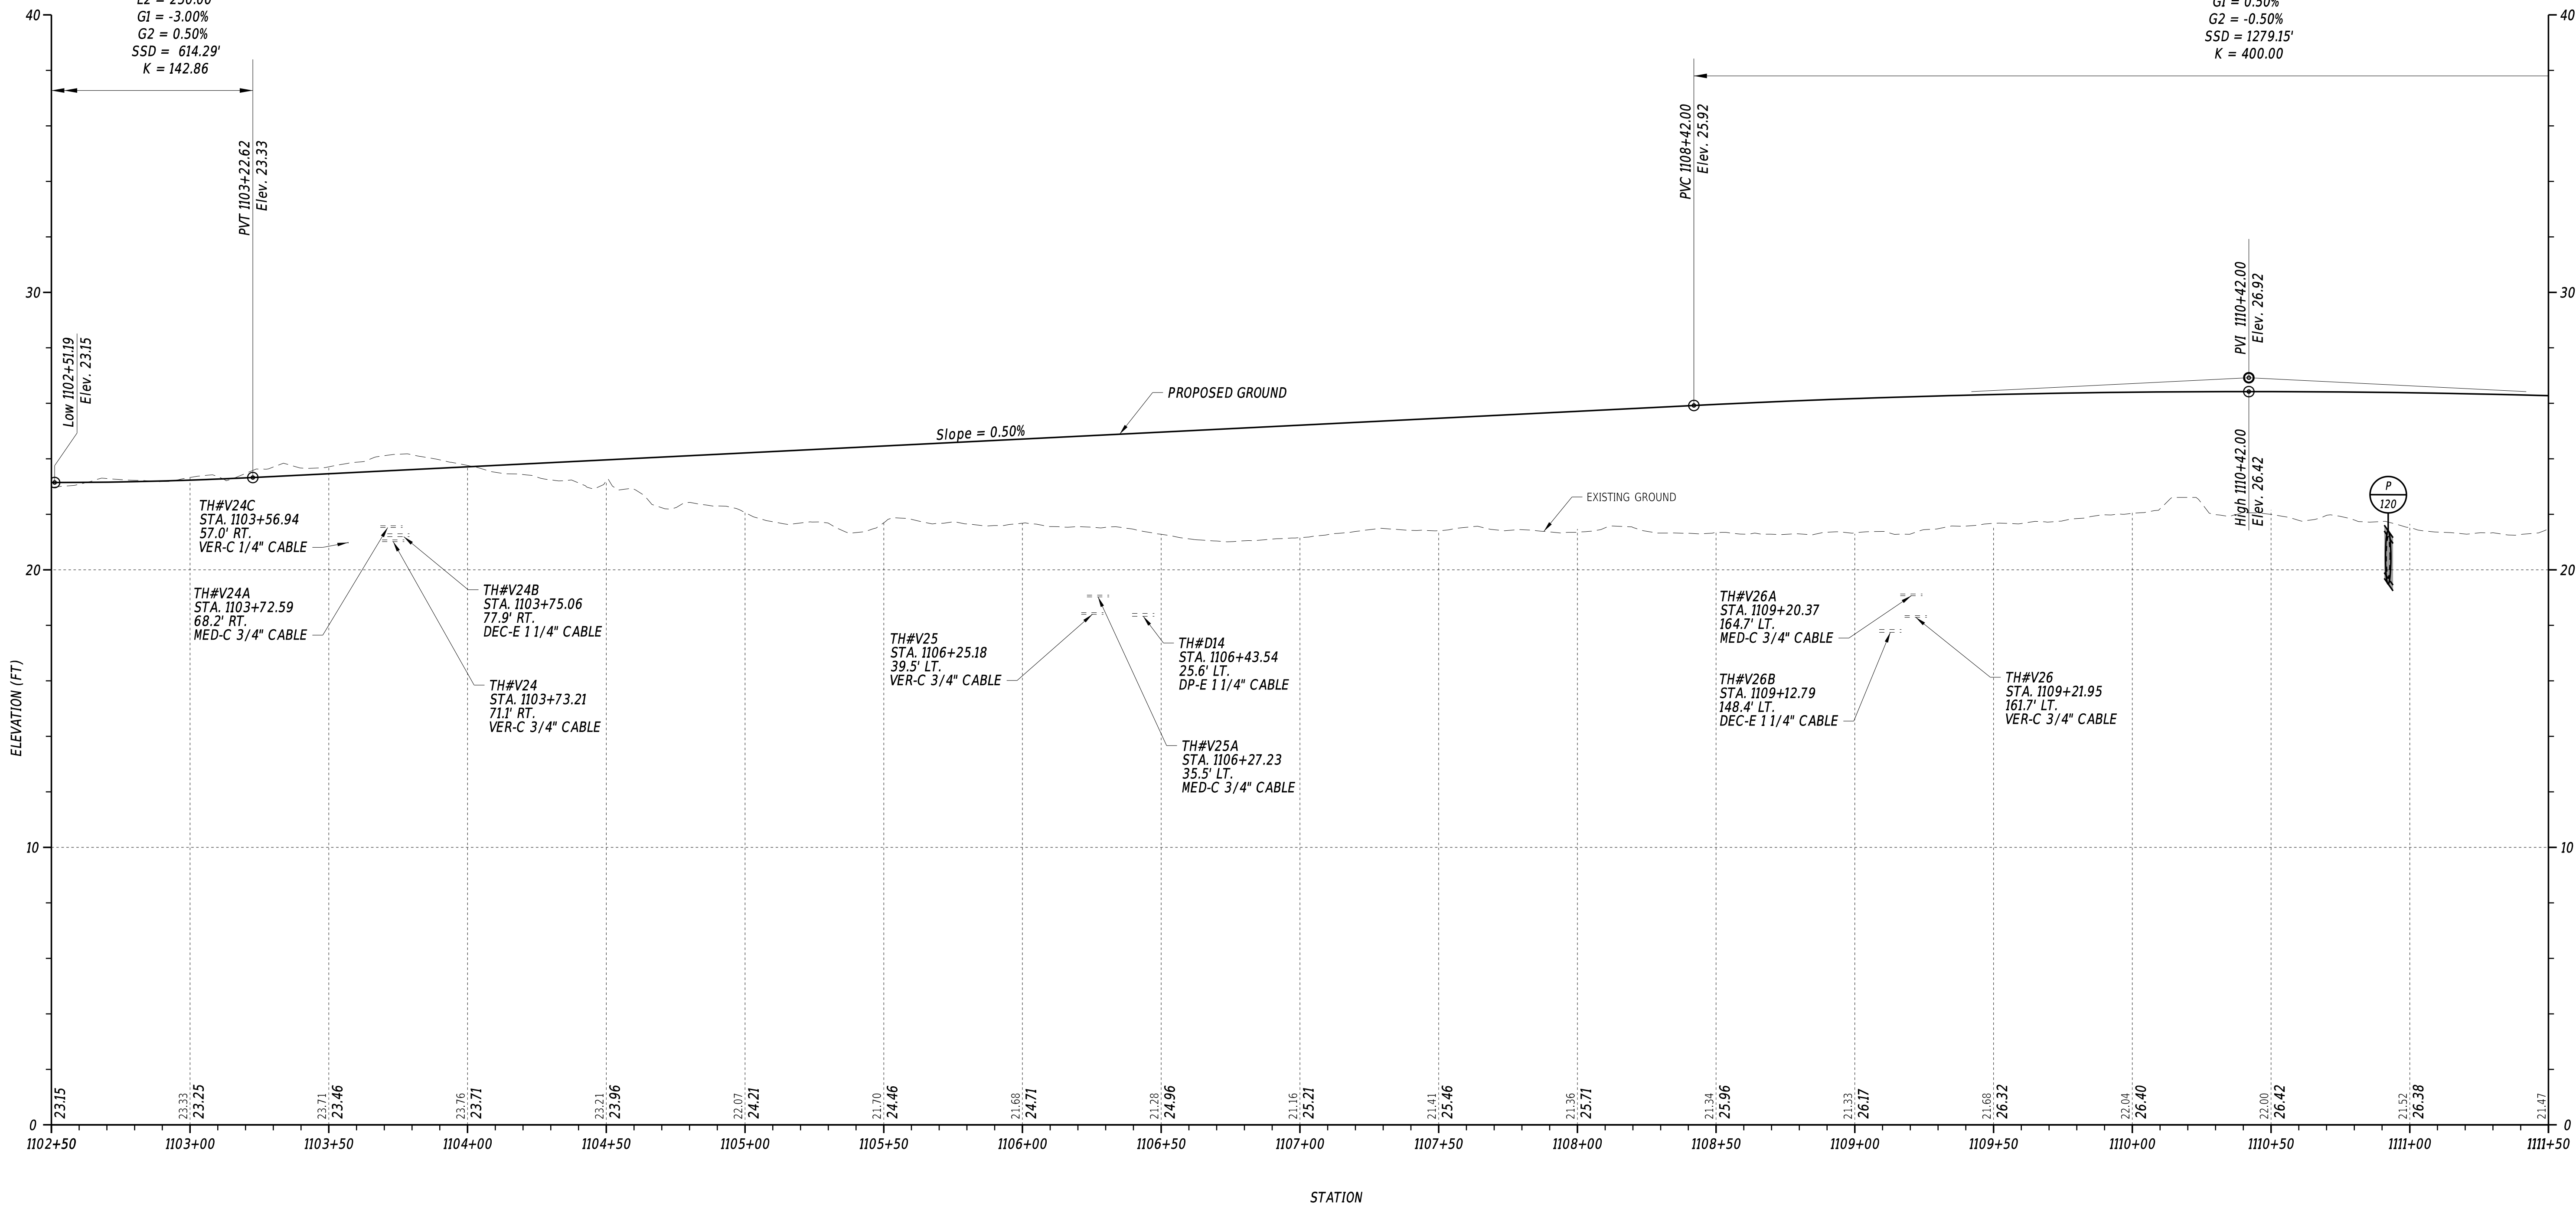

NORTH MILLSBORO BYPASS

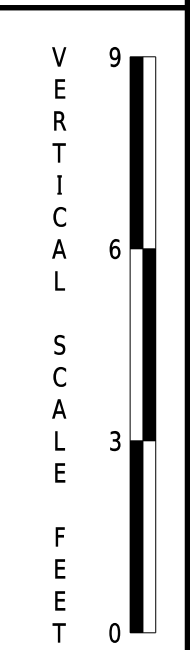

ADDENDA / REVISIONS

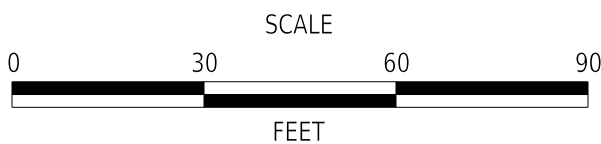


CM/GC,
NORTH MILLSBORO BYPASS,
US 113 TO SR 24

CONTRACT	BRIDGE NO.	N/A
T202112701	DESIGNED BY: M. FOX	
COUNTY	CHECKED BY: T. OLIVER	
SUSSEX		


PROFILE

SECTION
WRA
SHEET NO.
45

3/12/2022
6:13:57 PM
N:\132149-002\CADD\US 113 NM Bypass\FIG09_NMBP.dgn

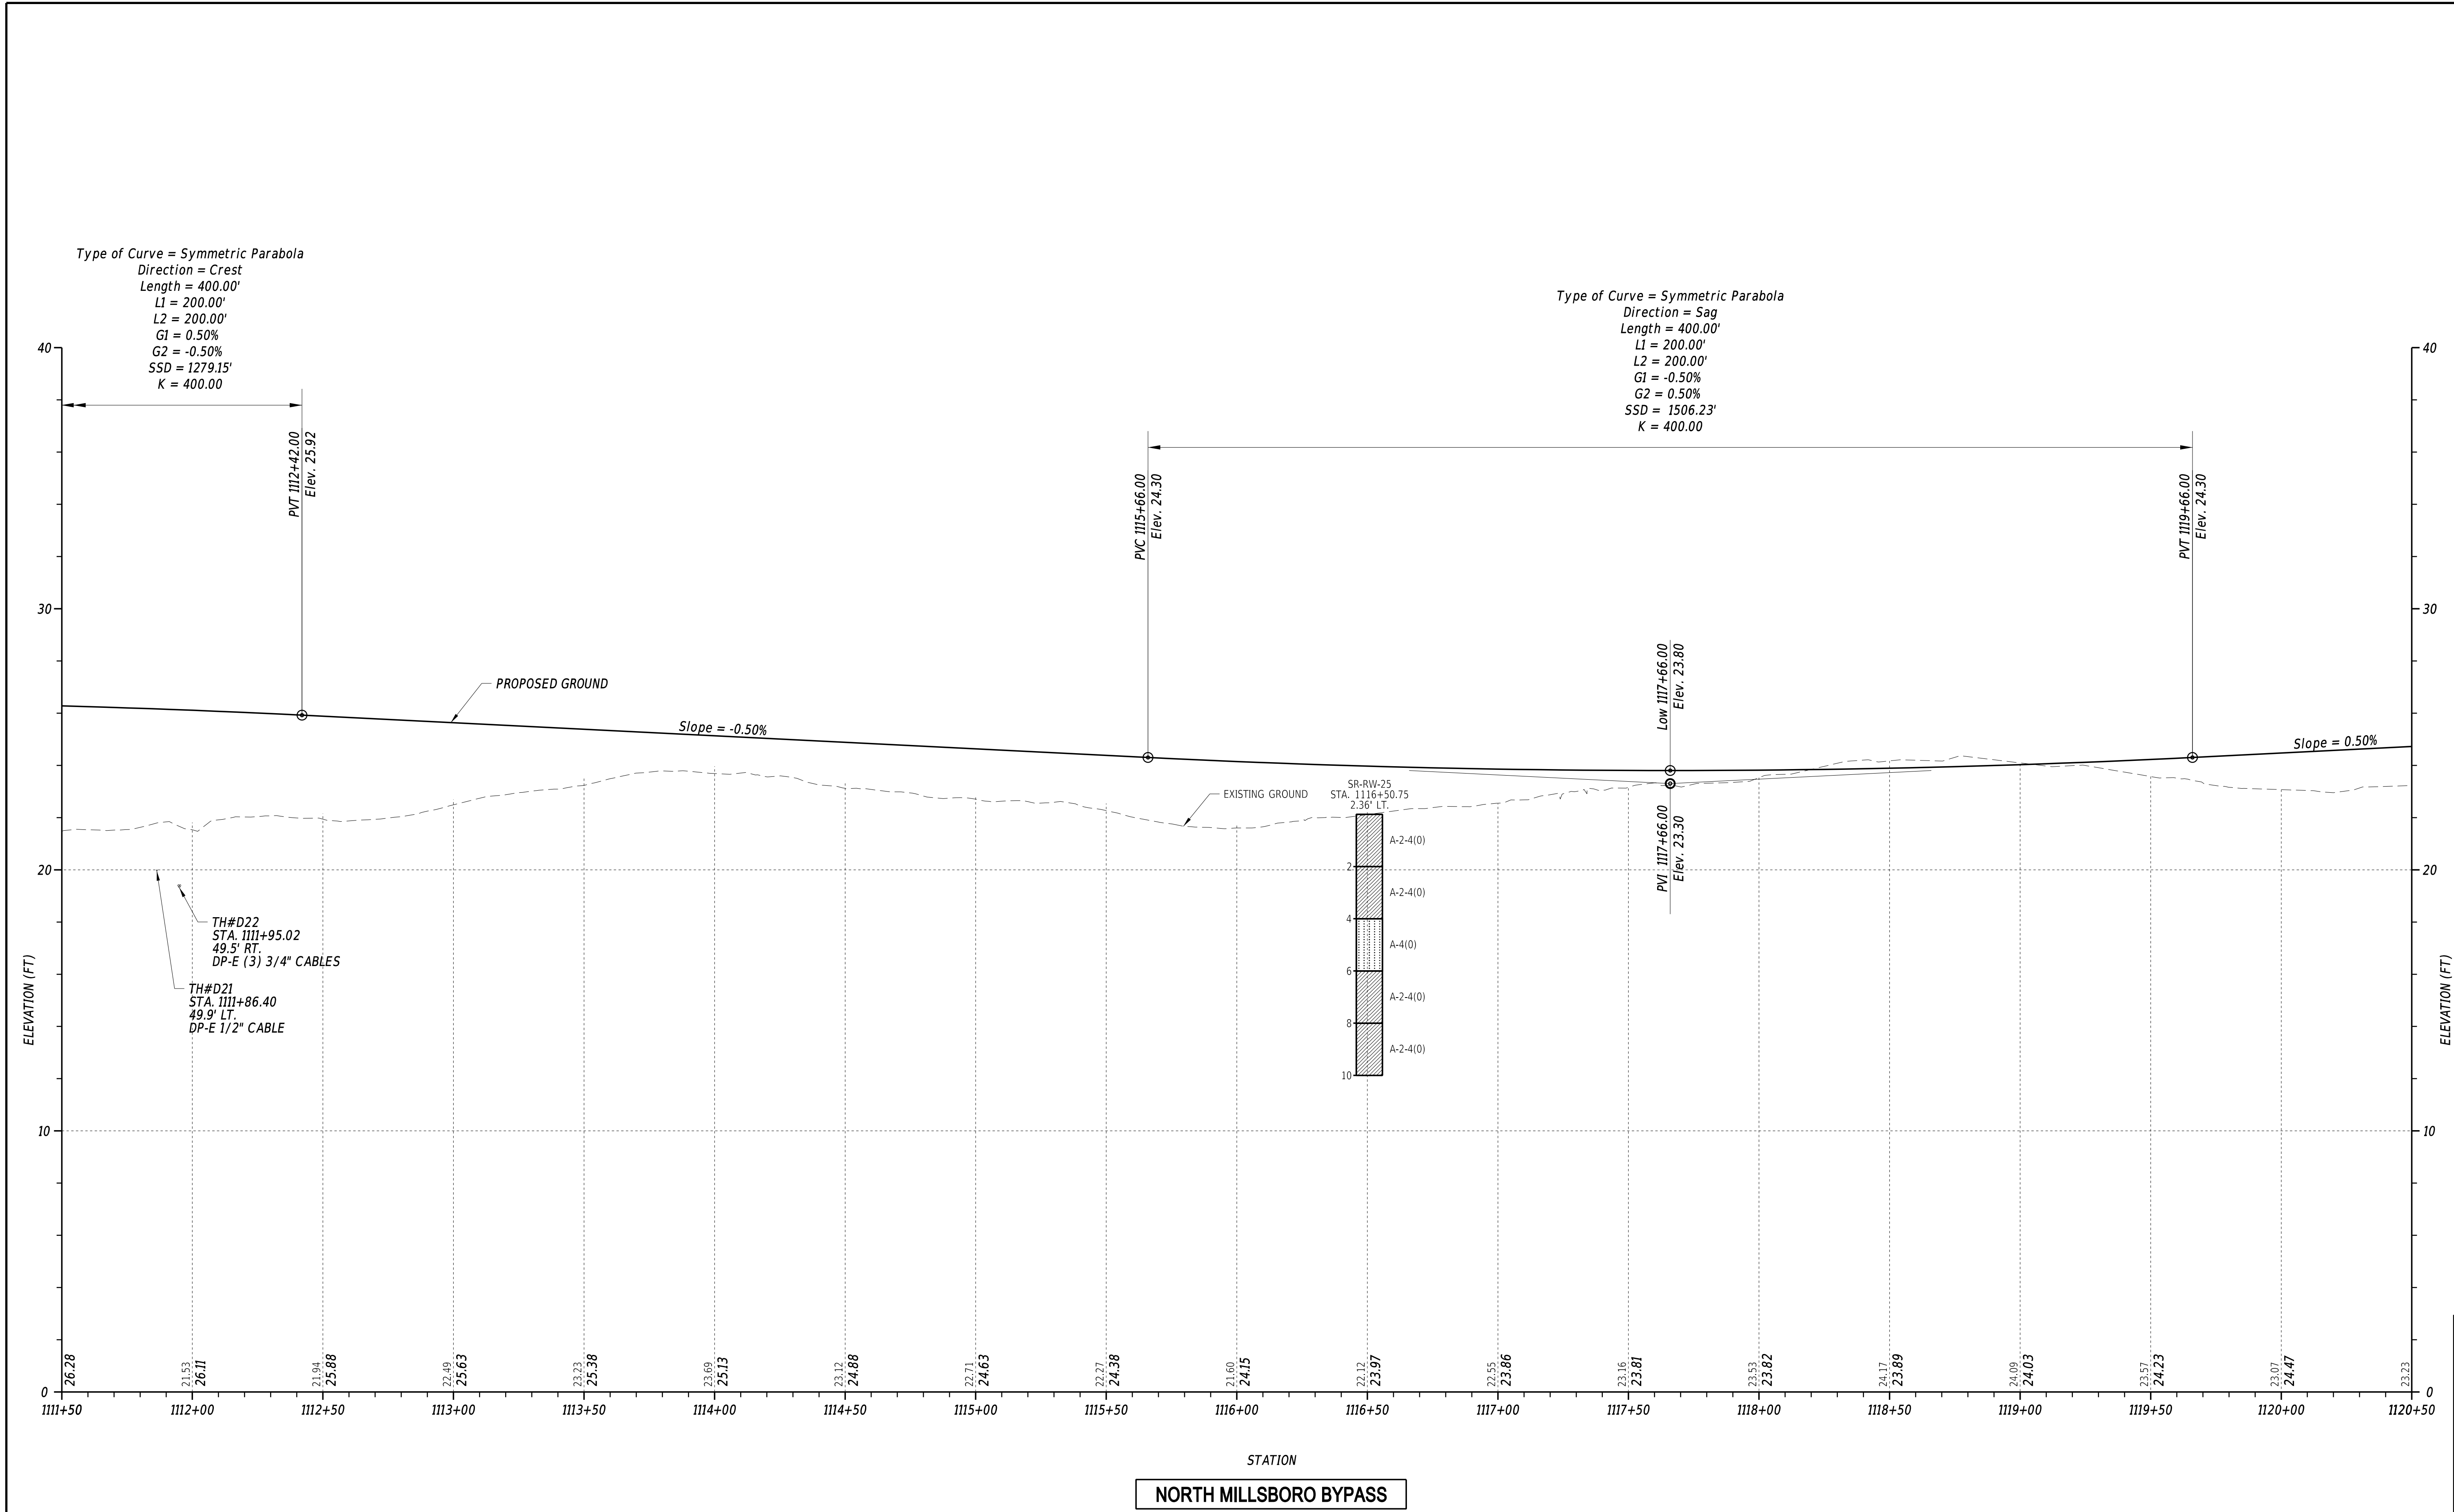


ADDENDA / REVISIONS	

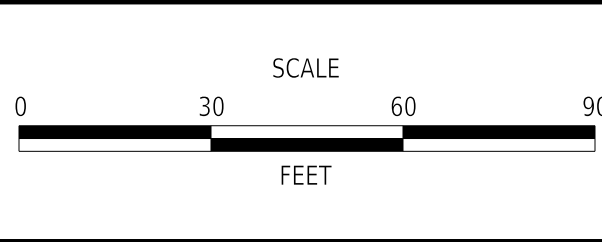


CM/GC,
NORTH MILLSBORO BYPASS,
US 113 TO SR 24

CONTRACT	BRIDGE NO.	N/A
T202112701	DESIGNED BY: M. FOX	
COUNTY	CHECKED BY: T. OLIVER	
SUSSEX		


SECTION
WRA
SHEET NO.
46

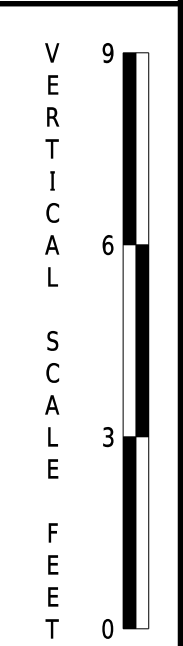

3/4/2022
6:13:58 PM
N:\132149-002\CADD\US 113 NM Bypass\PF10_NMBP.dgn

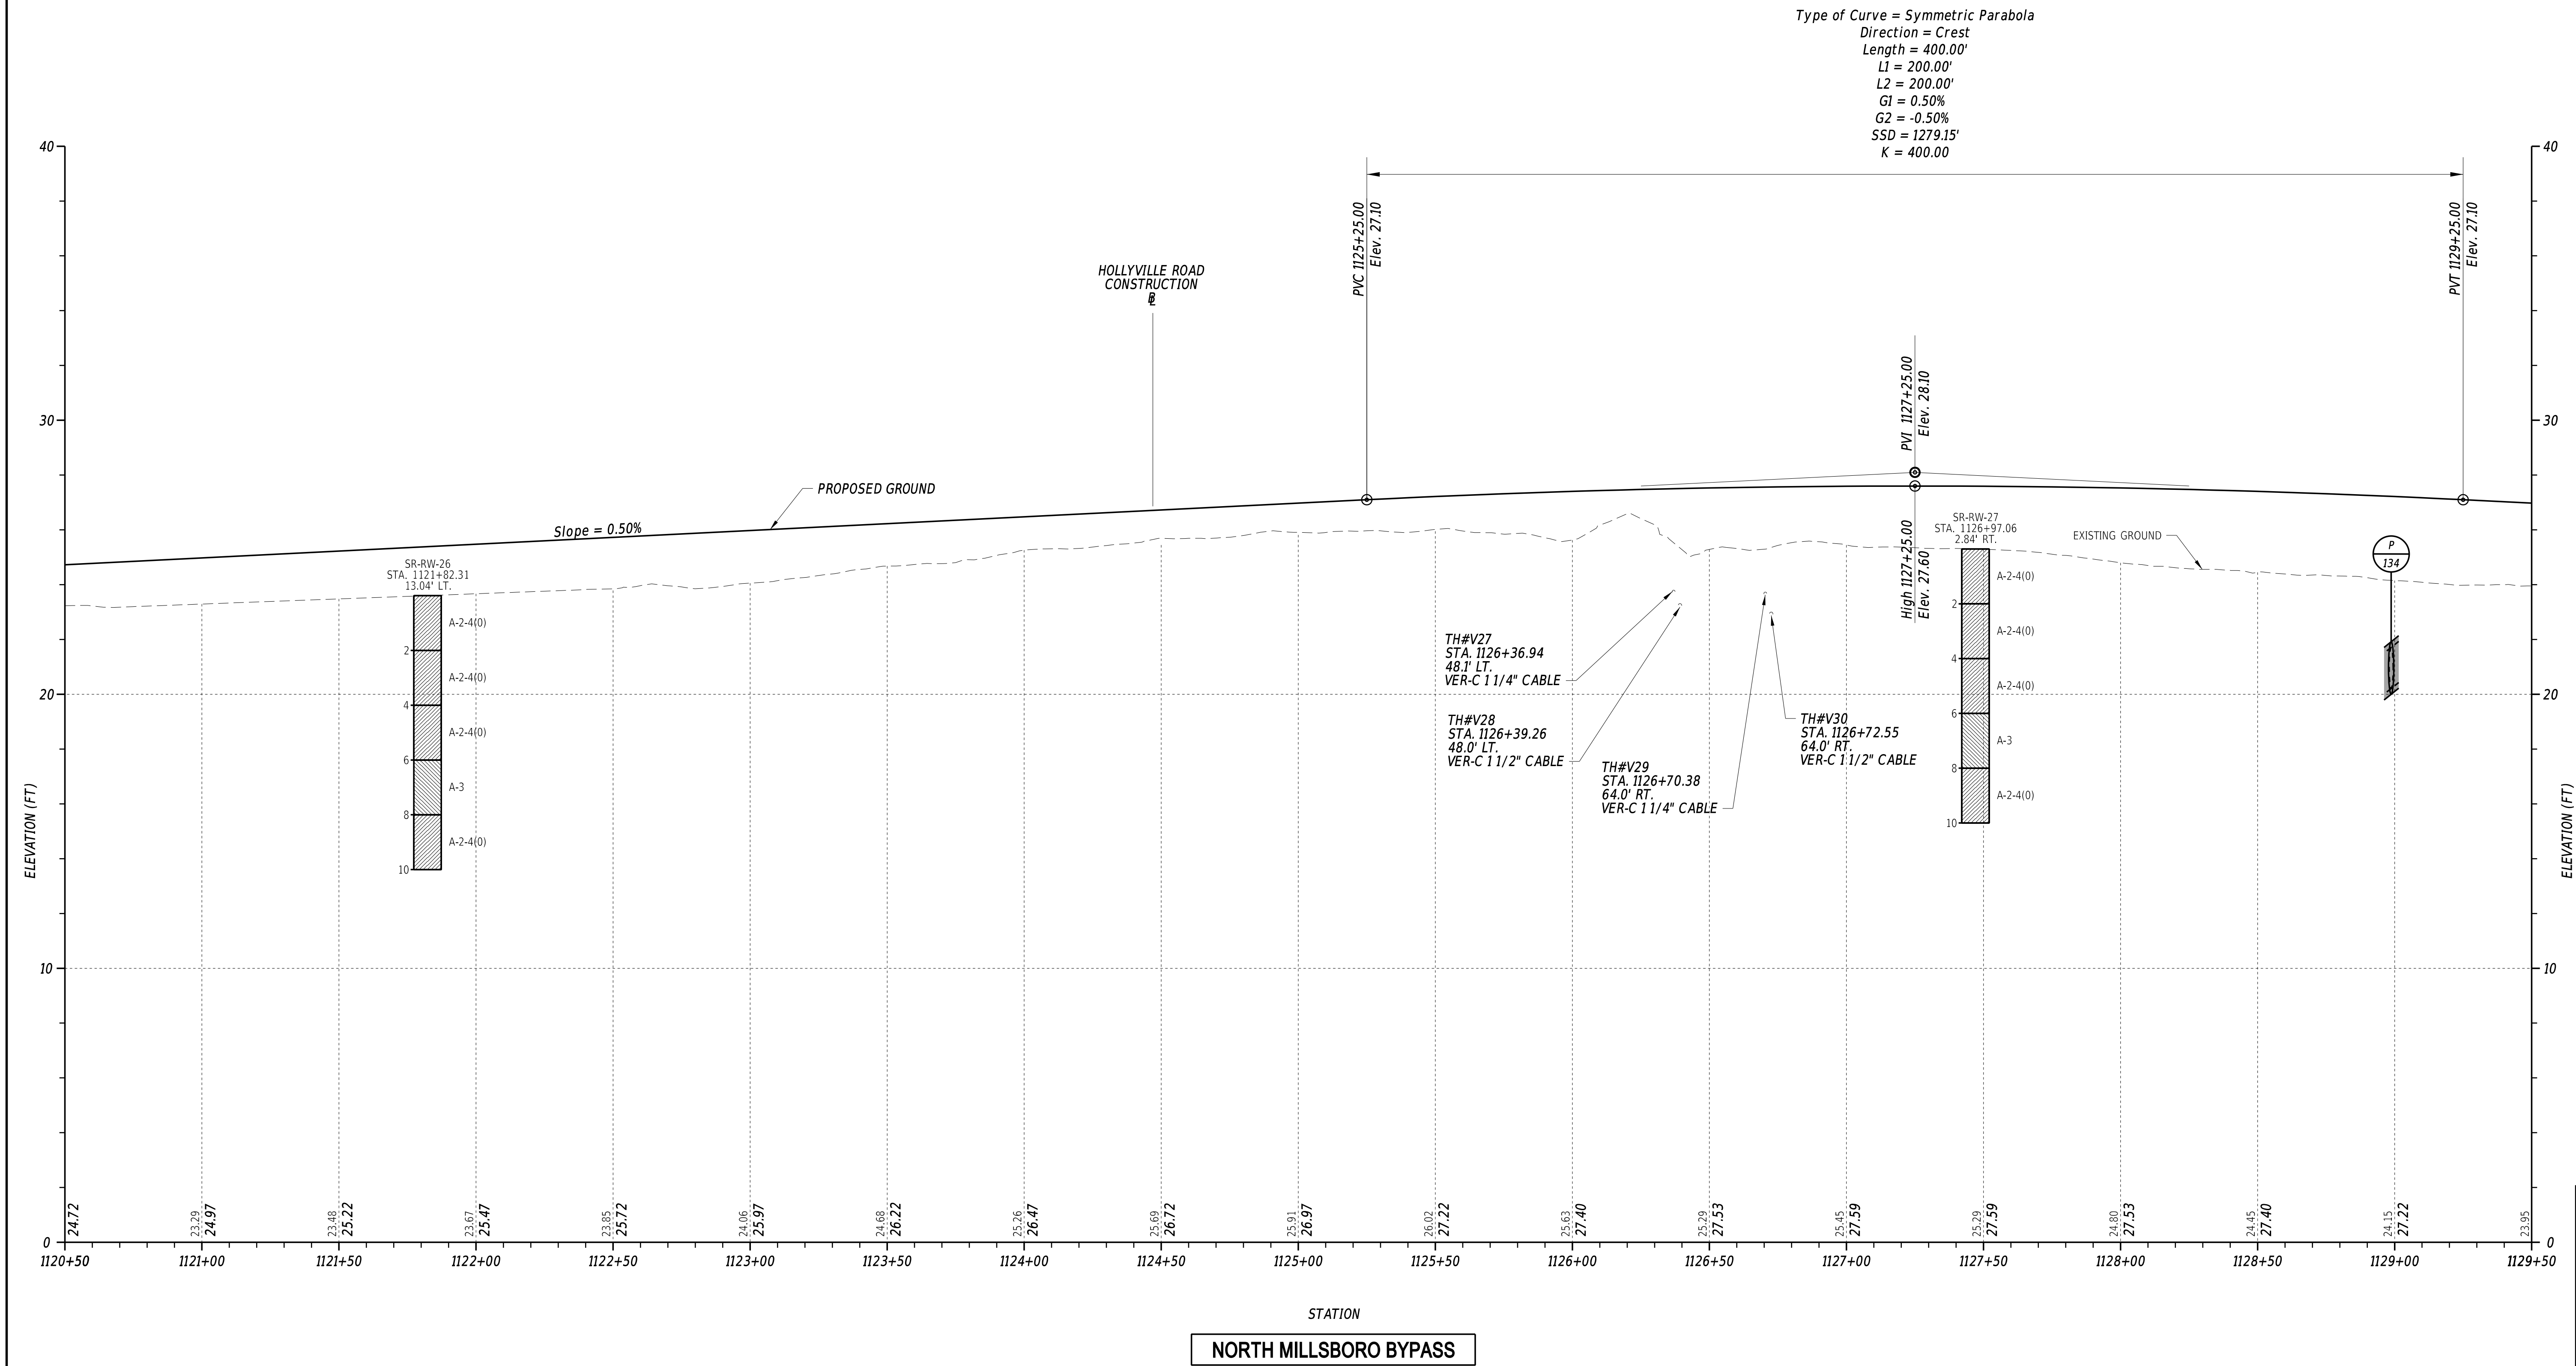


NORTH MILLSBORO BYPASS

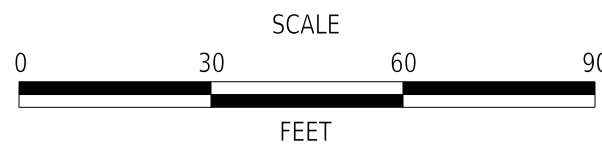

CM/GC,
NORTH MILLSBORO BYPASS,
US 113 TO SR 24


CONTRACT	BRIDGE NO.	N/A
T202112701	DESIGNED BY:	M. FOX
COUNTY	CHECKED BY:	T. OLIVER
SUSSEX		

PROFILE

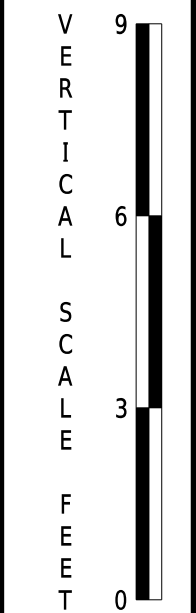


SECTION
WRA
SHEET NO.
47

3/4/2022
6:13:59 PM
N:\32149-002\CADD\US 113 NM Bypass\PE11_NMBP.dgn

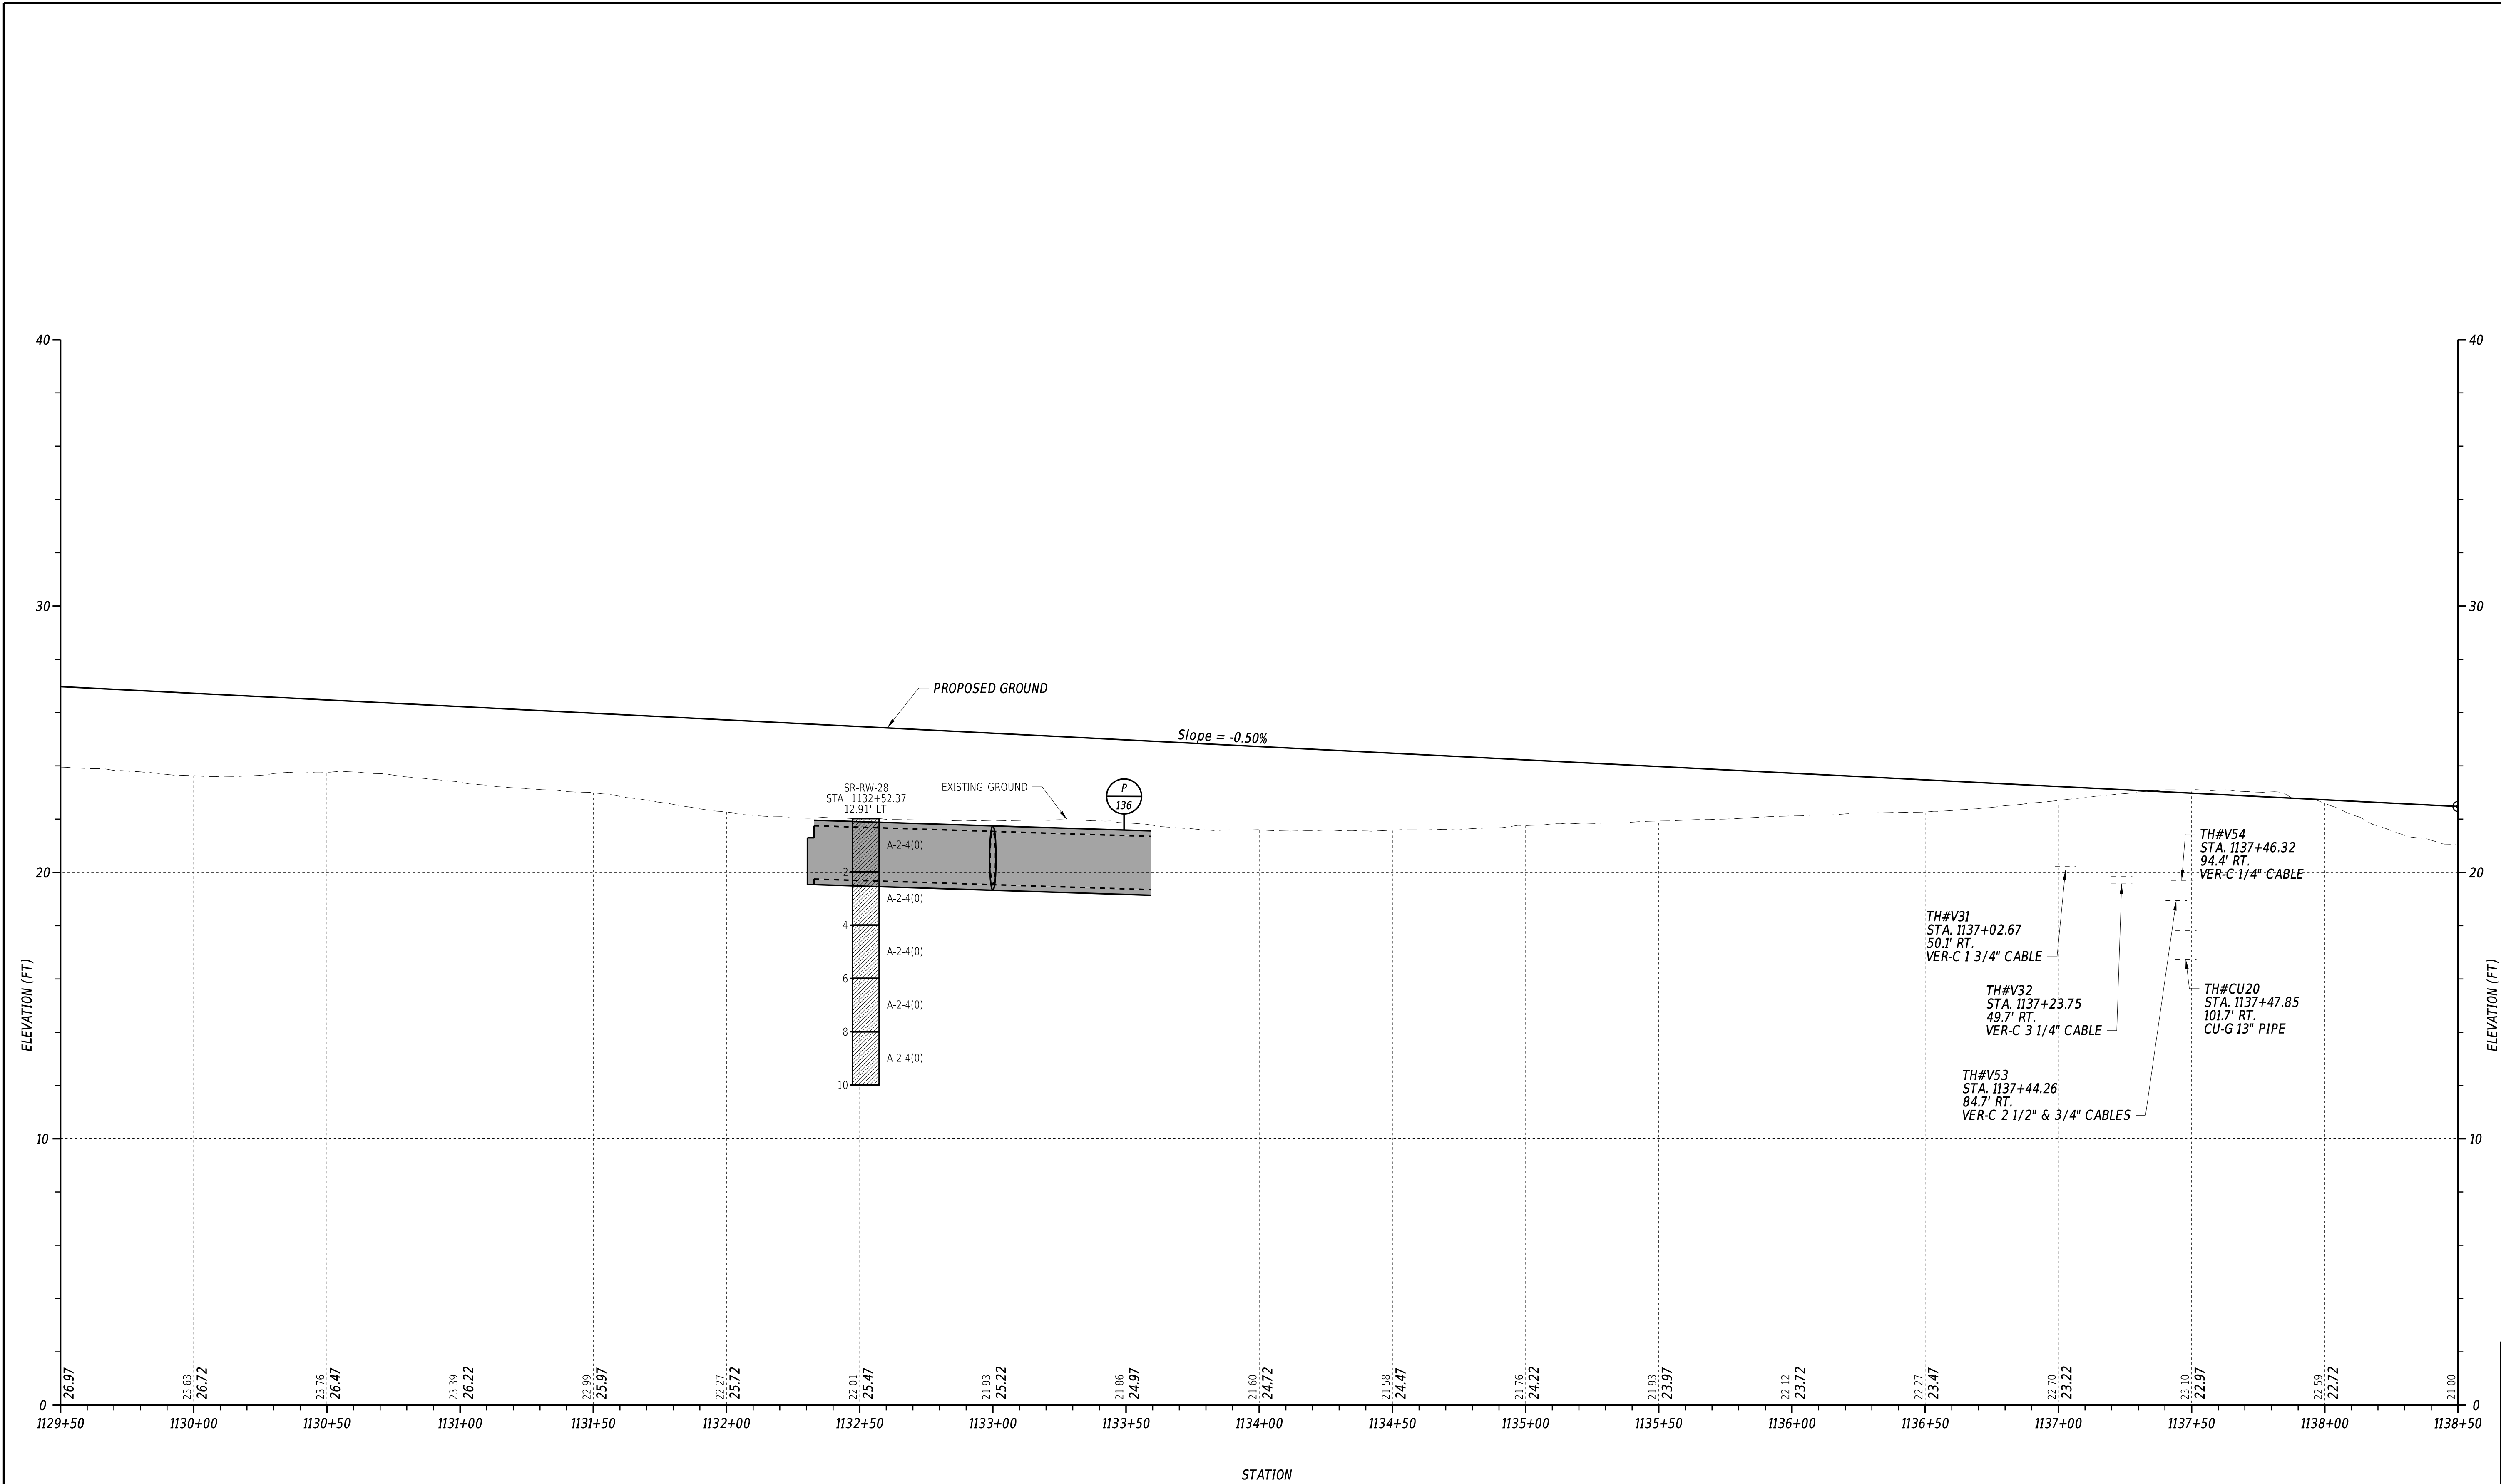


NORTH MILLSBORO BYPASS

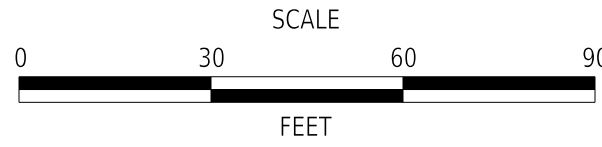

CM/GC,
NORTH MILLSBORO BYPASS,
US 113 TO SR 24


CONTRACT	BRIDGE NO.	N/A
T202112701	DESIGNED BY: M. FOX	
COUNTY	CHECKED BY: T. OLIVER	
SUSSEX		

PROFILE

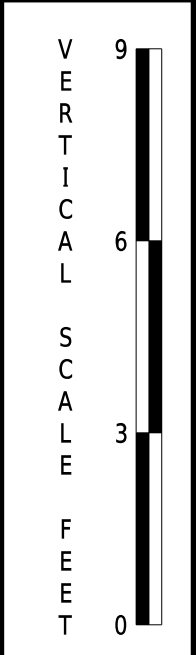


SECTION
WRA
SHEET NO.
48

3/4/2022
6:14:00 PM
N:\132149-002\CADD\US 113 NM Bypass\PF12_NMBP.dgn

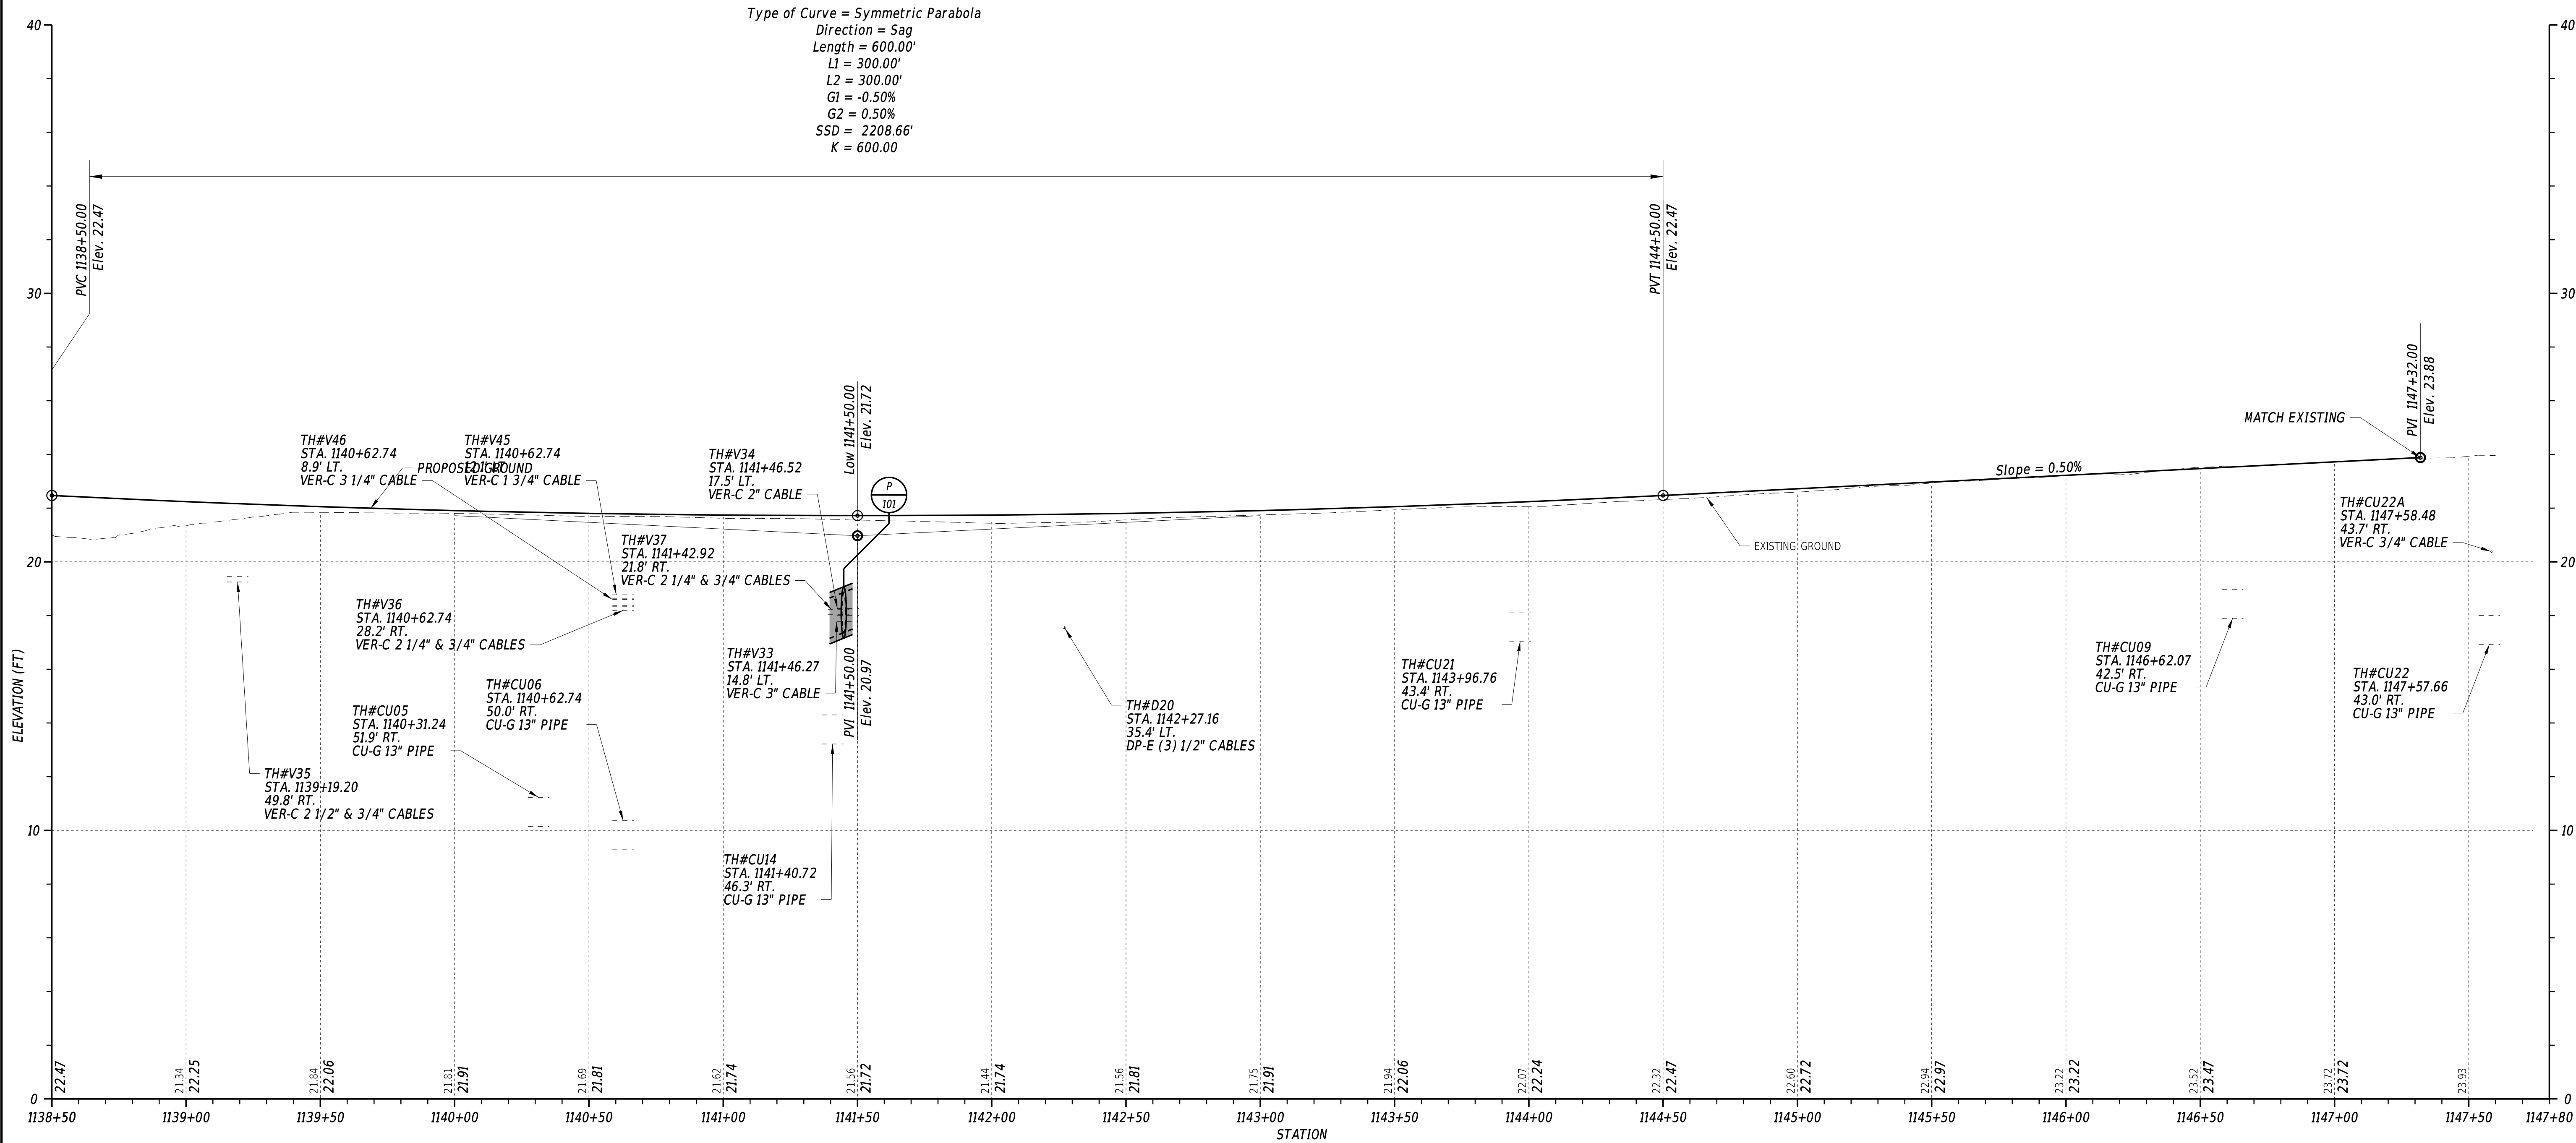

NORTH MILLSBORO BYPASS


ADDENDA / REVISIONS	

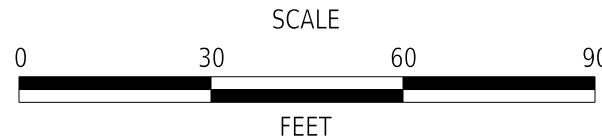

CM/GC,
NORTH MILLSBORO BYPASS,
US 113 TO SR 24


CONTRACT	BRIDGE NO.	N/A
T202112701	DESIGNED BY: M. FOX	
COUNTY	CHECKED BY: T. OLIVER	
SUSSEX		

 PROFILE




SECTION
WRA
SHEET NO.
49

3/4/2022
6:14:00 PM
N:\32149-002\CADD\US 113 NM Bypass\PE13_NMBP.dgn

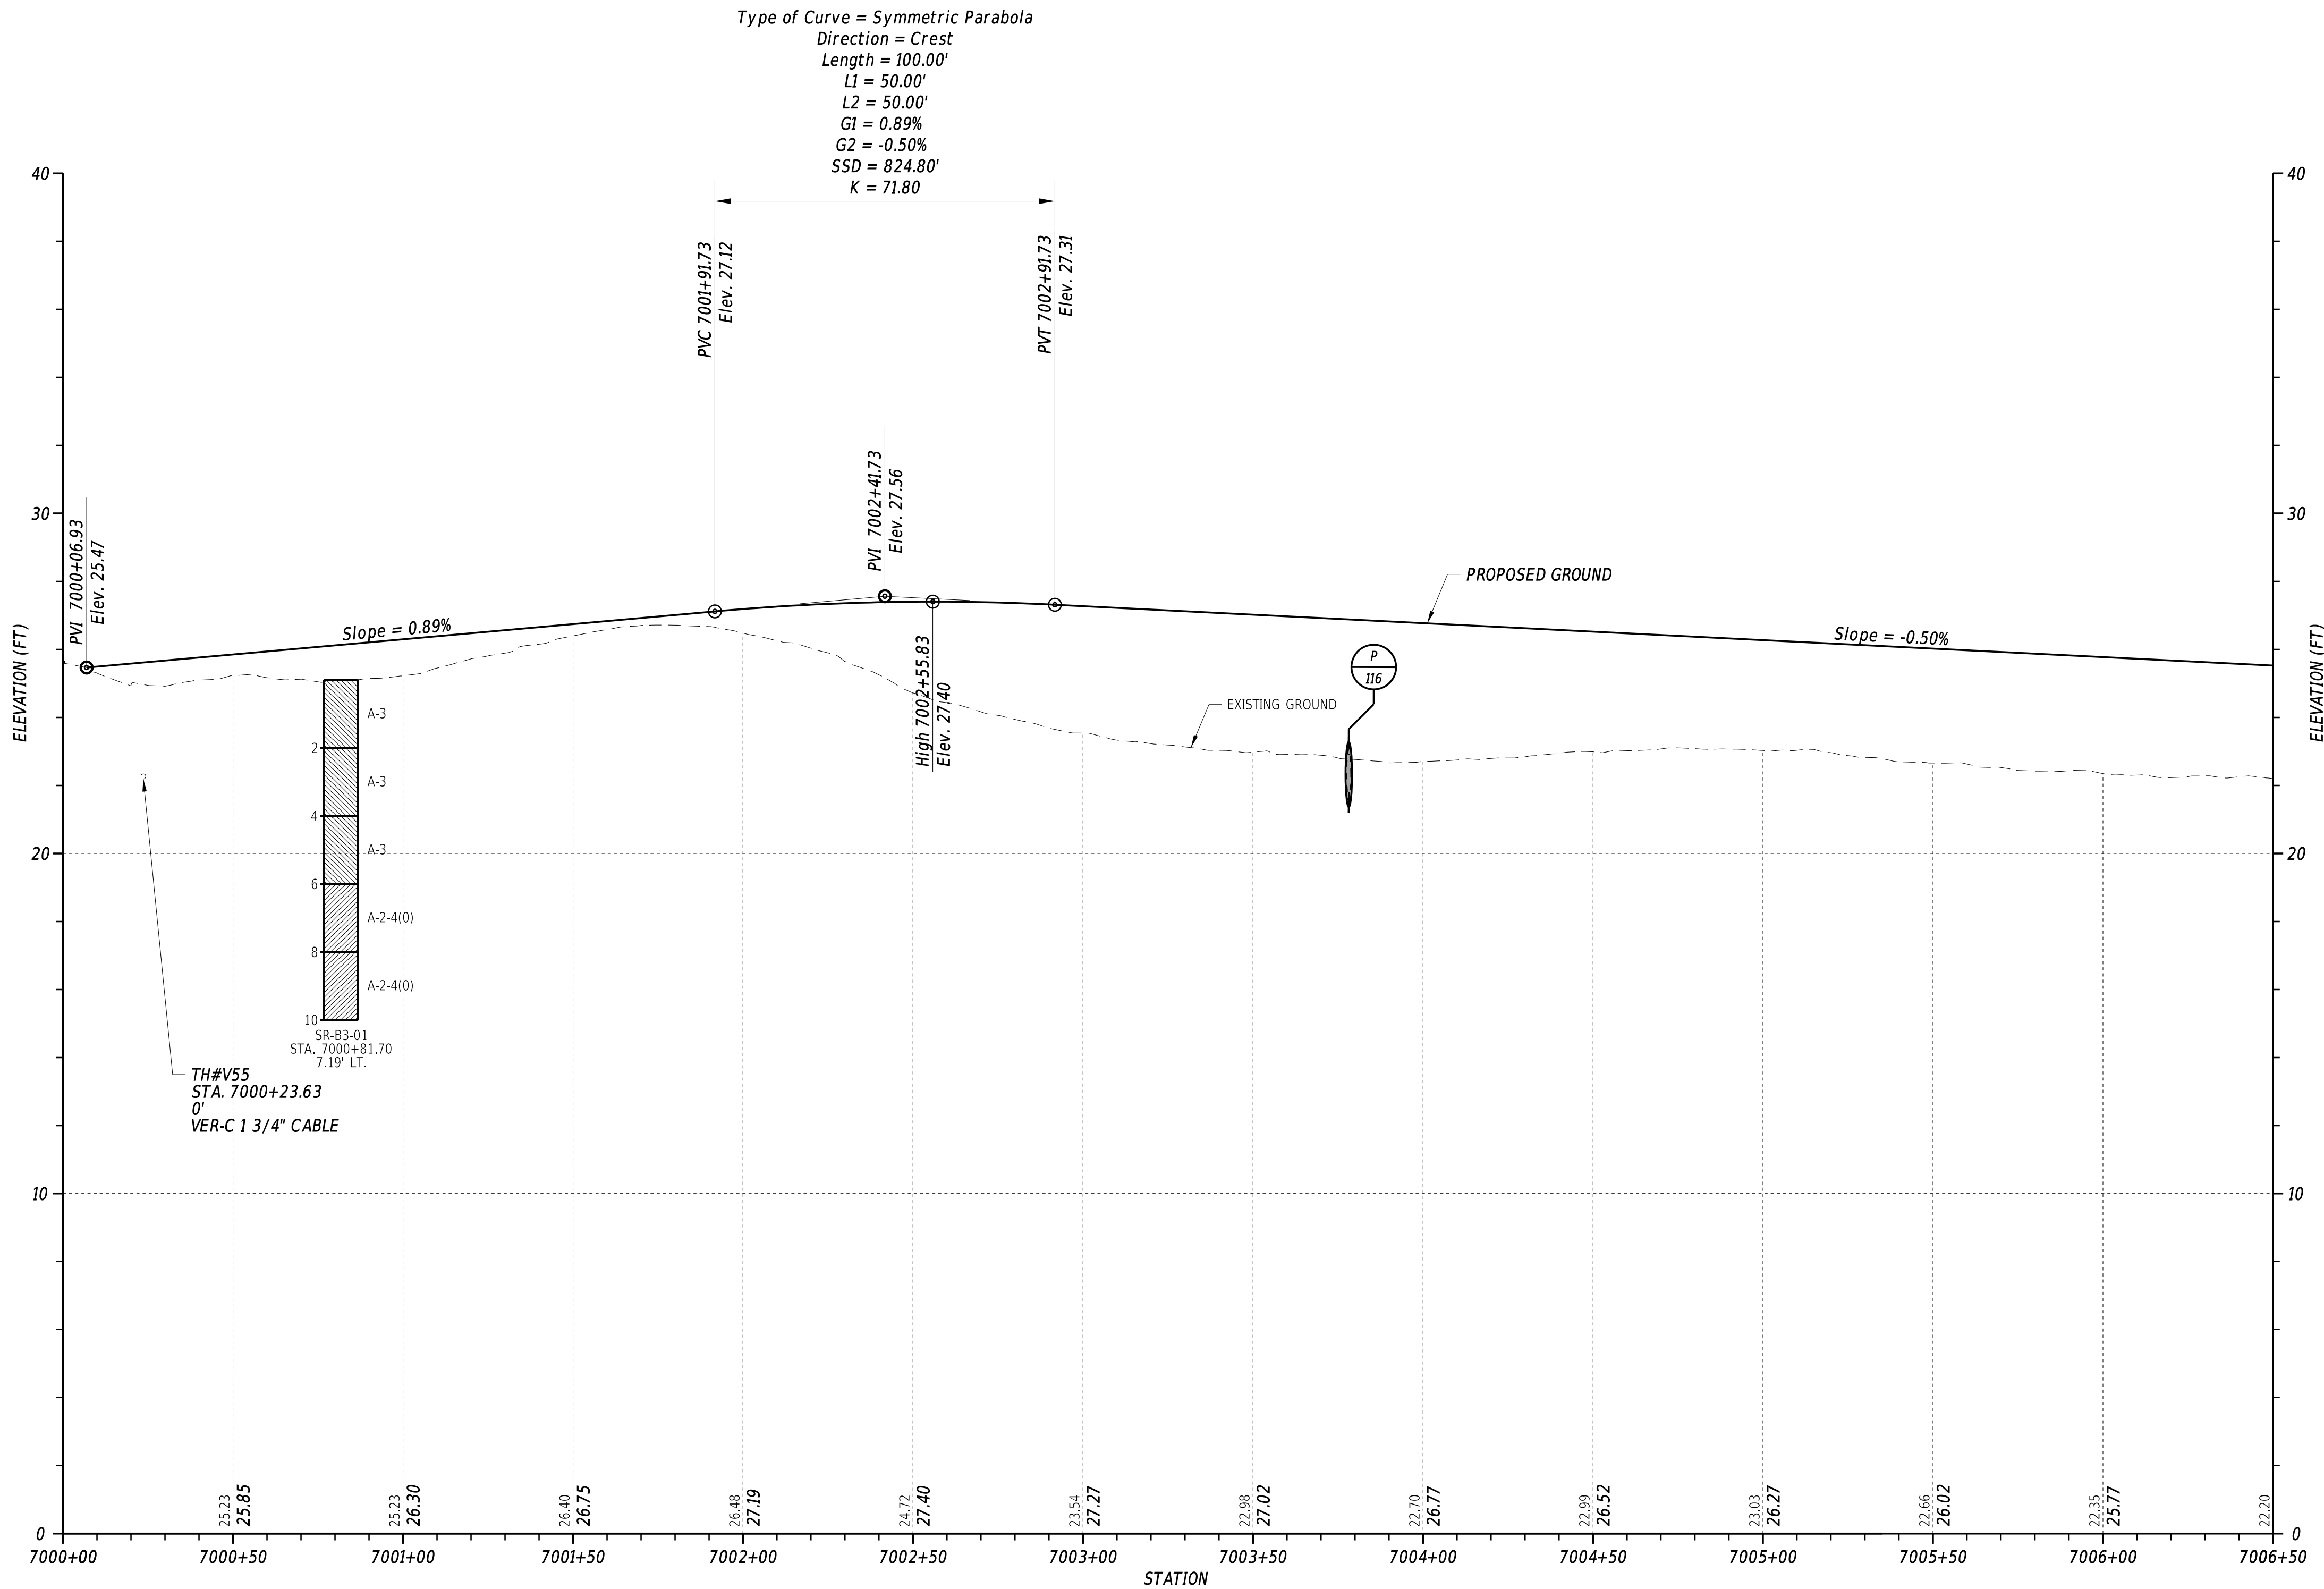


ADDENDA / REVISIONS	

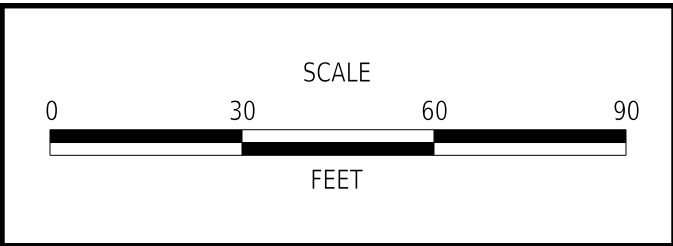


CM/GC,
NORTH MILLSBORO BYPASS,
US 113 TO SR 24

CONTRACT	BRIDGE NO.	N/A
T202112701	DESIGNED BY:	M. FOX
COUNTY	CHECKED BY:	T. OLIVER
SUSSEX		


SECTION
WRA
SHEET NO.
50

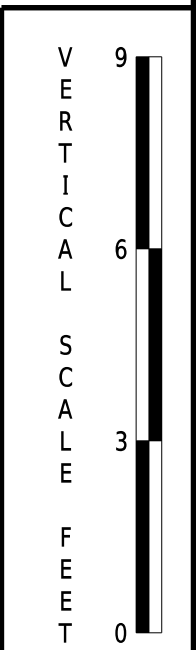

3/4/2022
6:14:01 PM
N:\32149-002\CADD\US 113 NM Bypass\PE14_NMBP.dgn

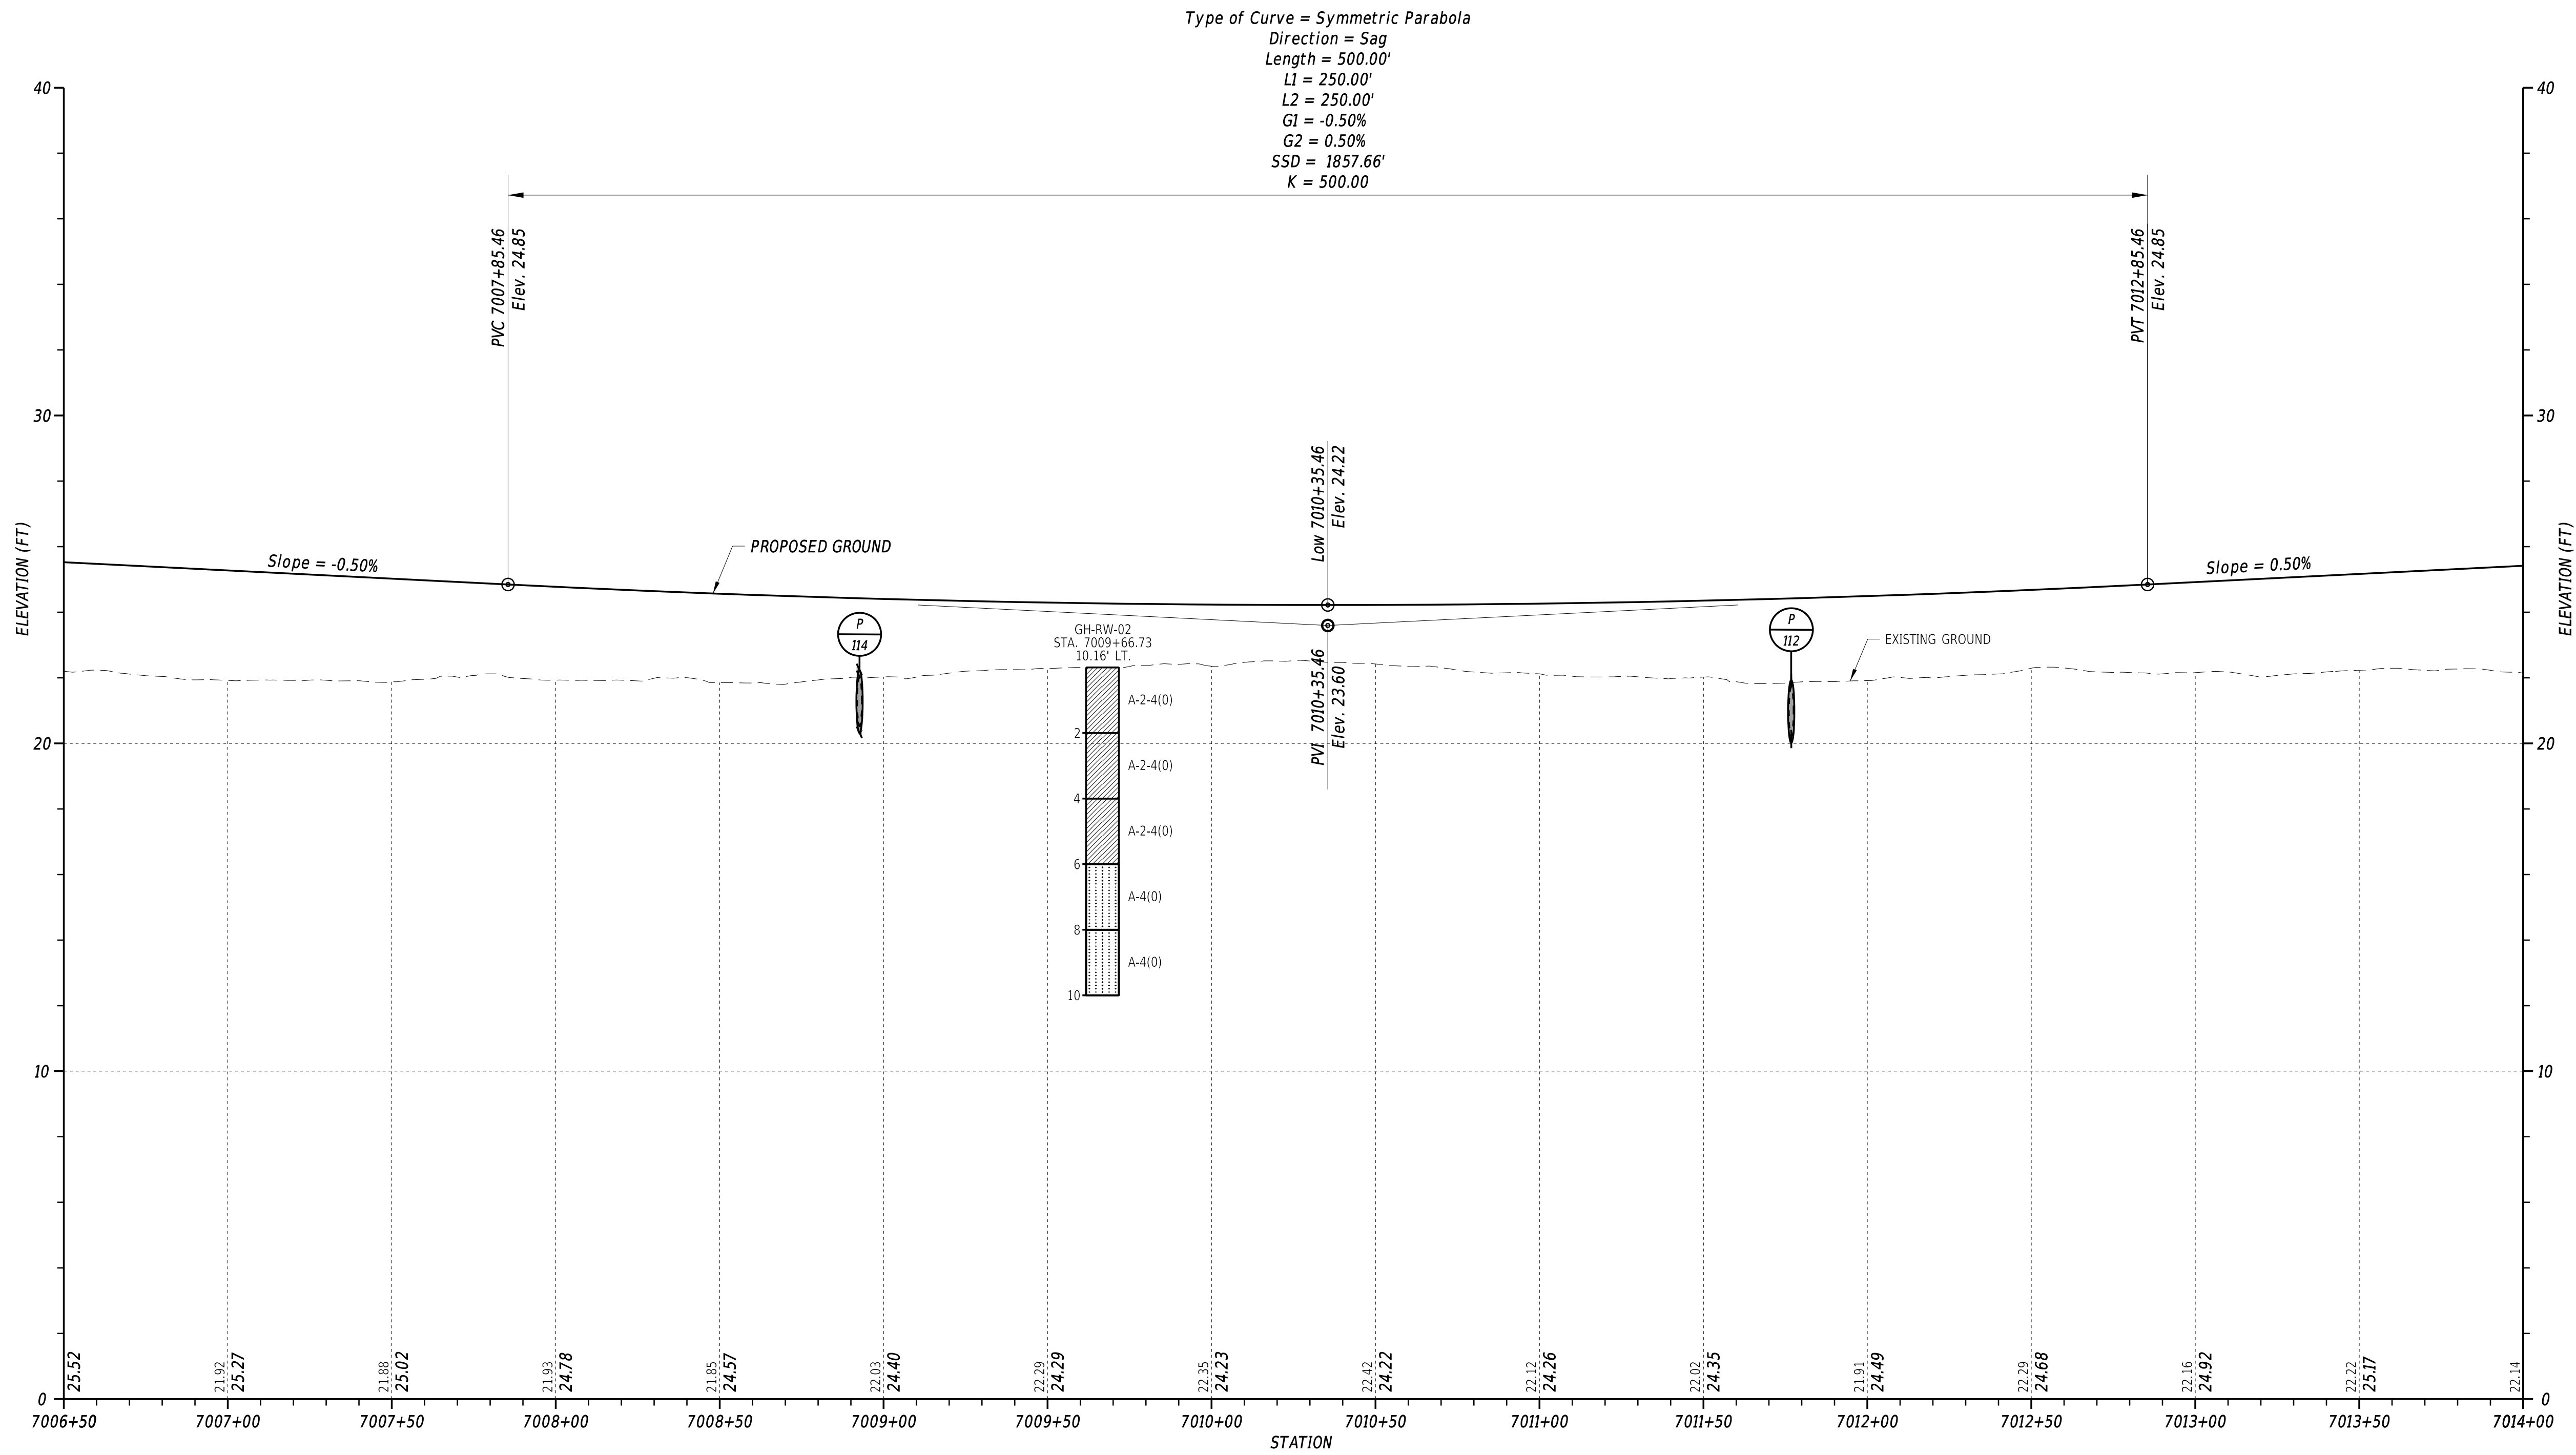

GRAVEL HILL ROAD CONNECTOR

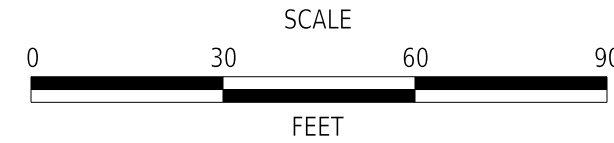

CM/GC,
NORTH MILLSBORO BYPASS,
US 113 TO SR 24


CONTRACT	BRIDGE NO.	N/A
T202112701	DESIGNED BY:	M. FOX
COUNTY	CHECKED BY:	T. OLIVER
SUSSEX		

PROFILE


VERTICAL SCALE
0 3 6 9
FEET

SECTION
WRA
SHEET NO.
51

3/4/2022
6:14:02 PM
N:\132149-002\CADD\US 113 NM Bypass\PF15_NMBP.dgn

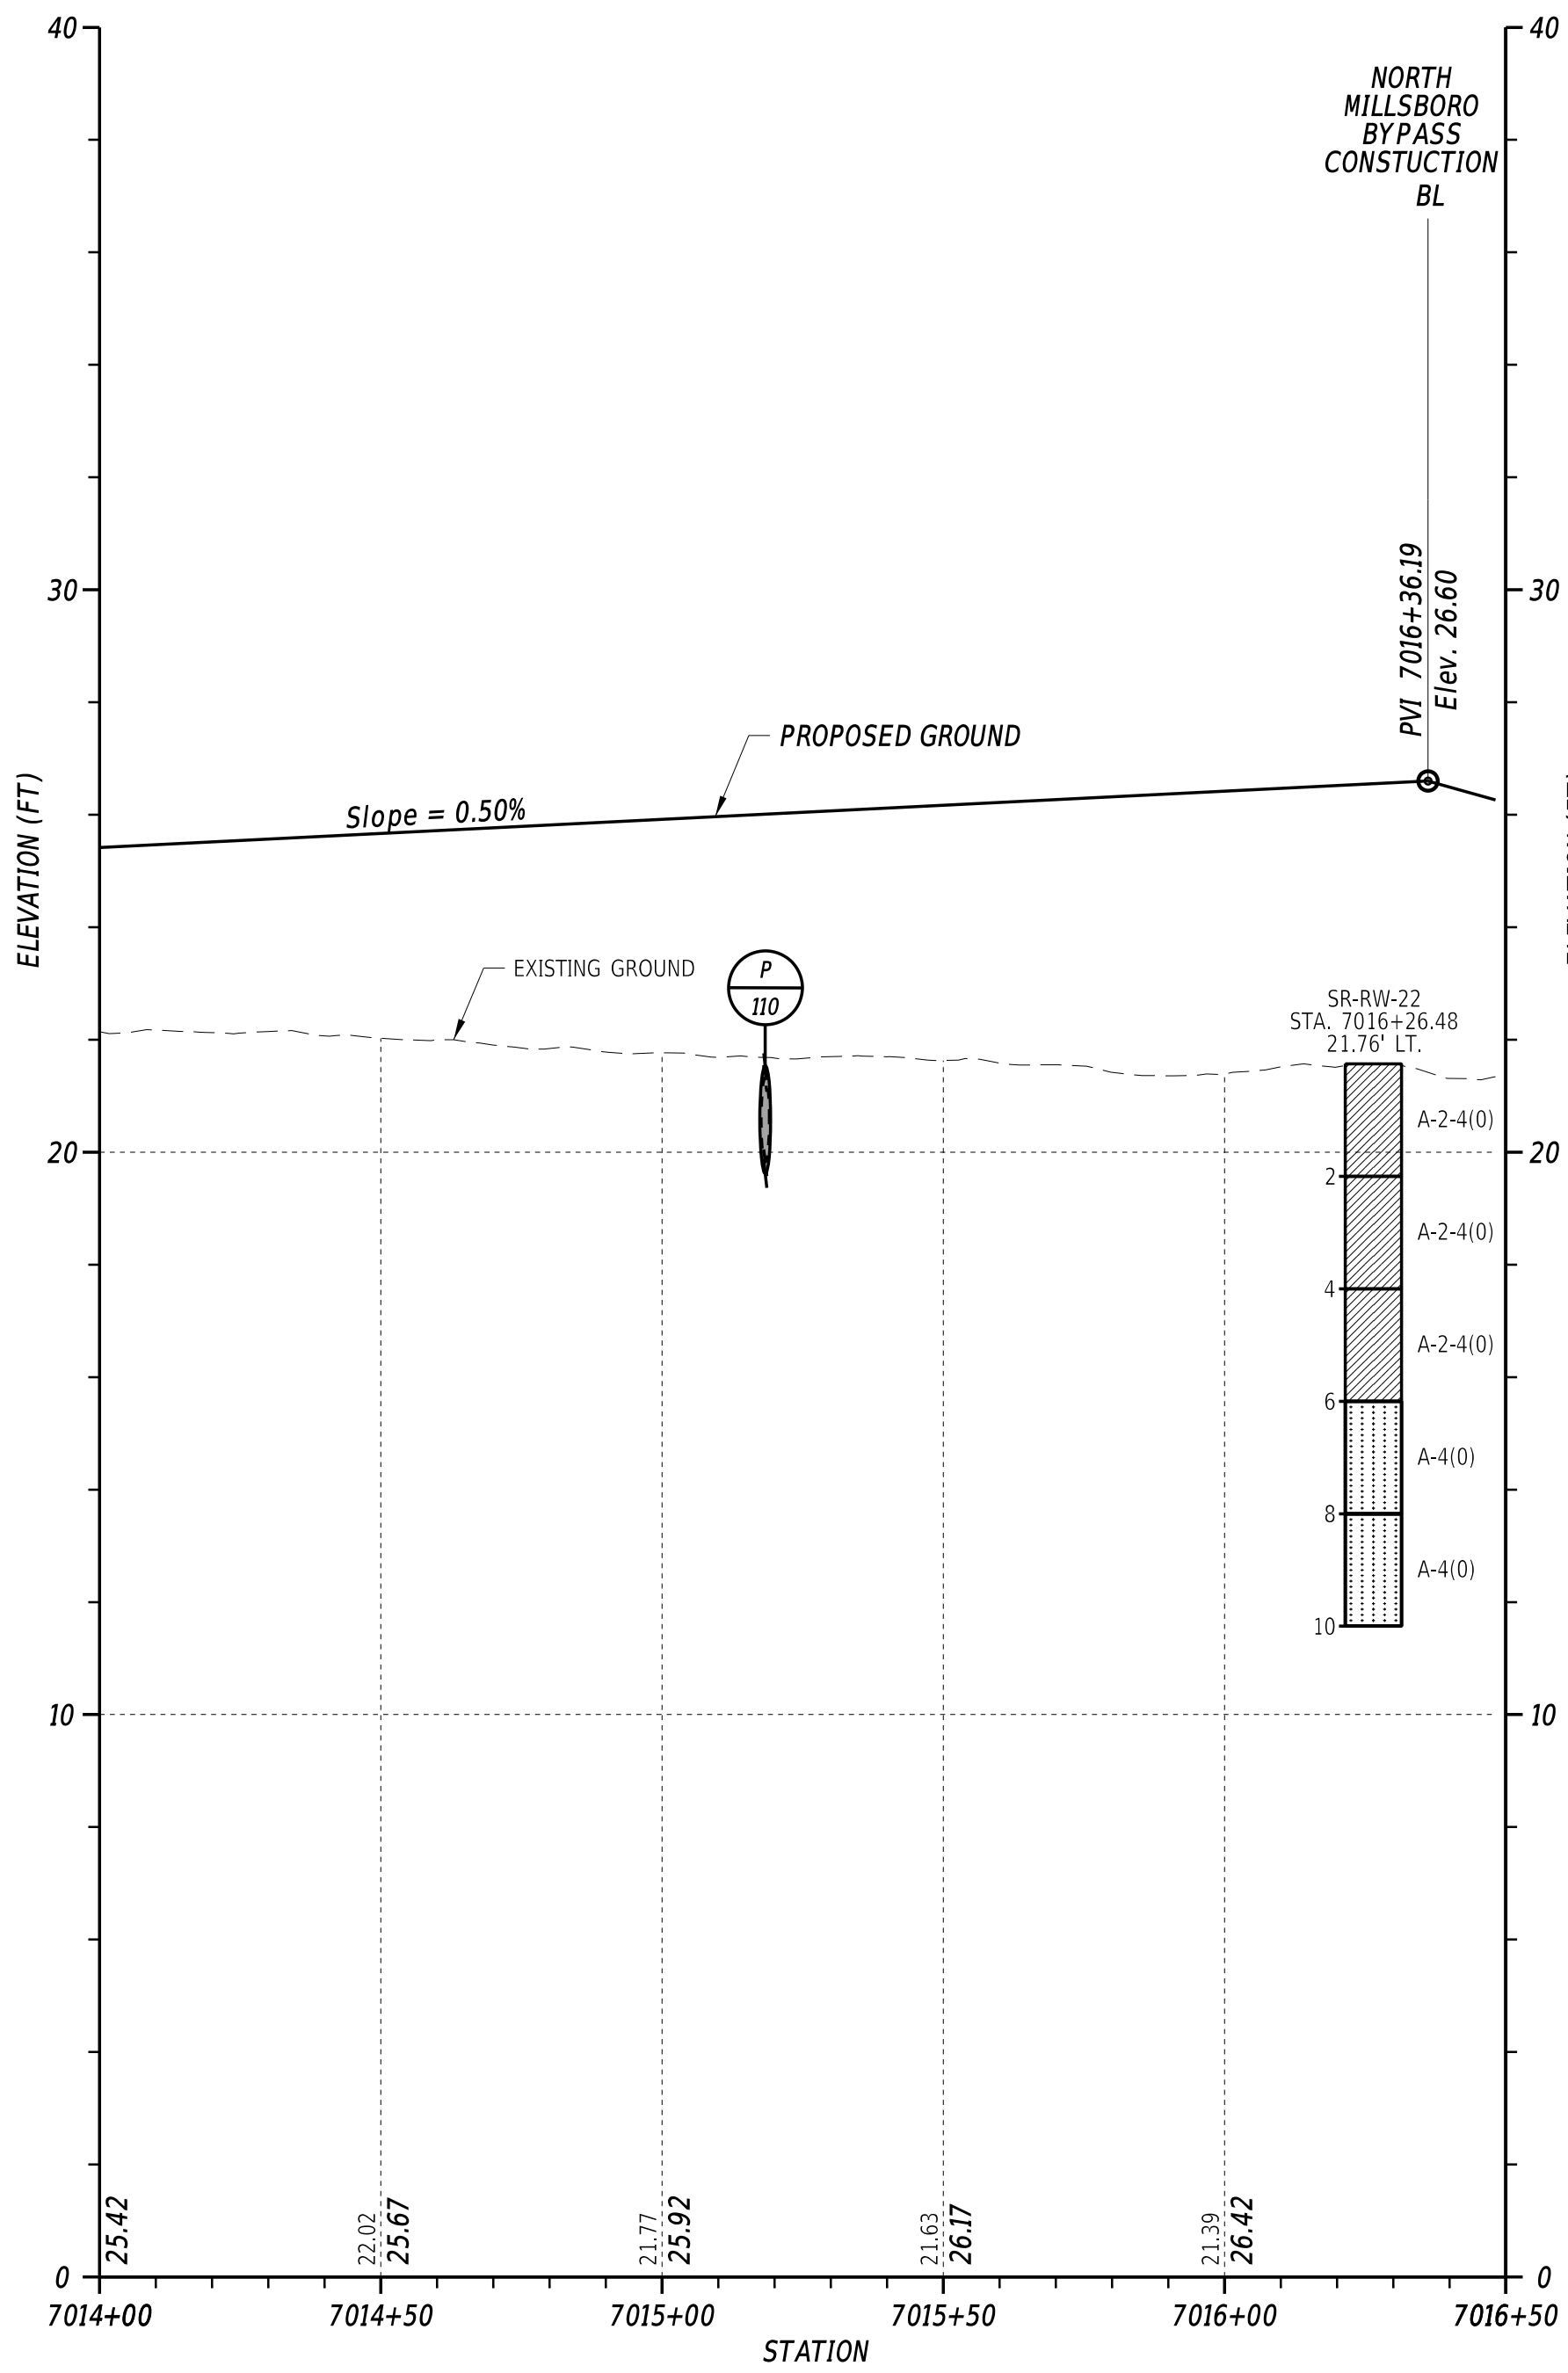


GRAVEL HILL ROAD CONNECTOR

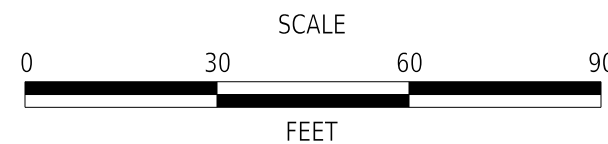

CM/GC,
NORTH MILLSBORO BYPASS,
US 113 TO SR 24


CONTRACT	BRIDGE NO.	N/A
T202112701	DESIGNED BY: M. FOX	
COUNTY	CHECKED BY: T. OLIVER	
SUSSEX		

PROFILE

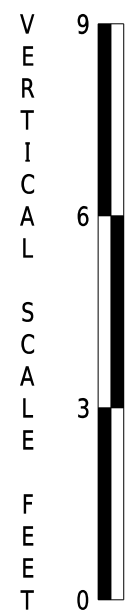


SECTION
WRA
SHEET NO.
52

3/4/2022
6:14:03 PM
N:\32149-002\CADD\US 113 NM Bypass\PE16_NMBP.dgn

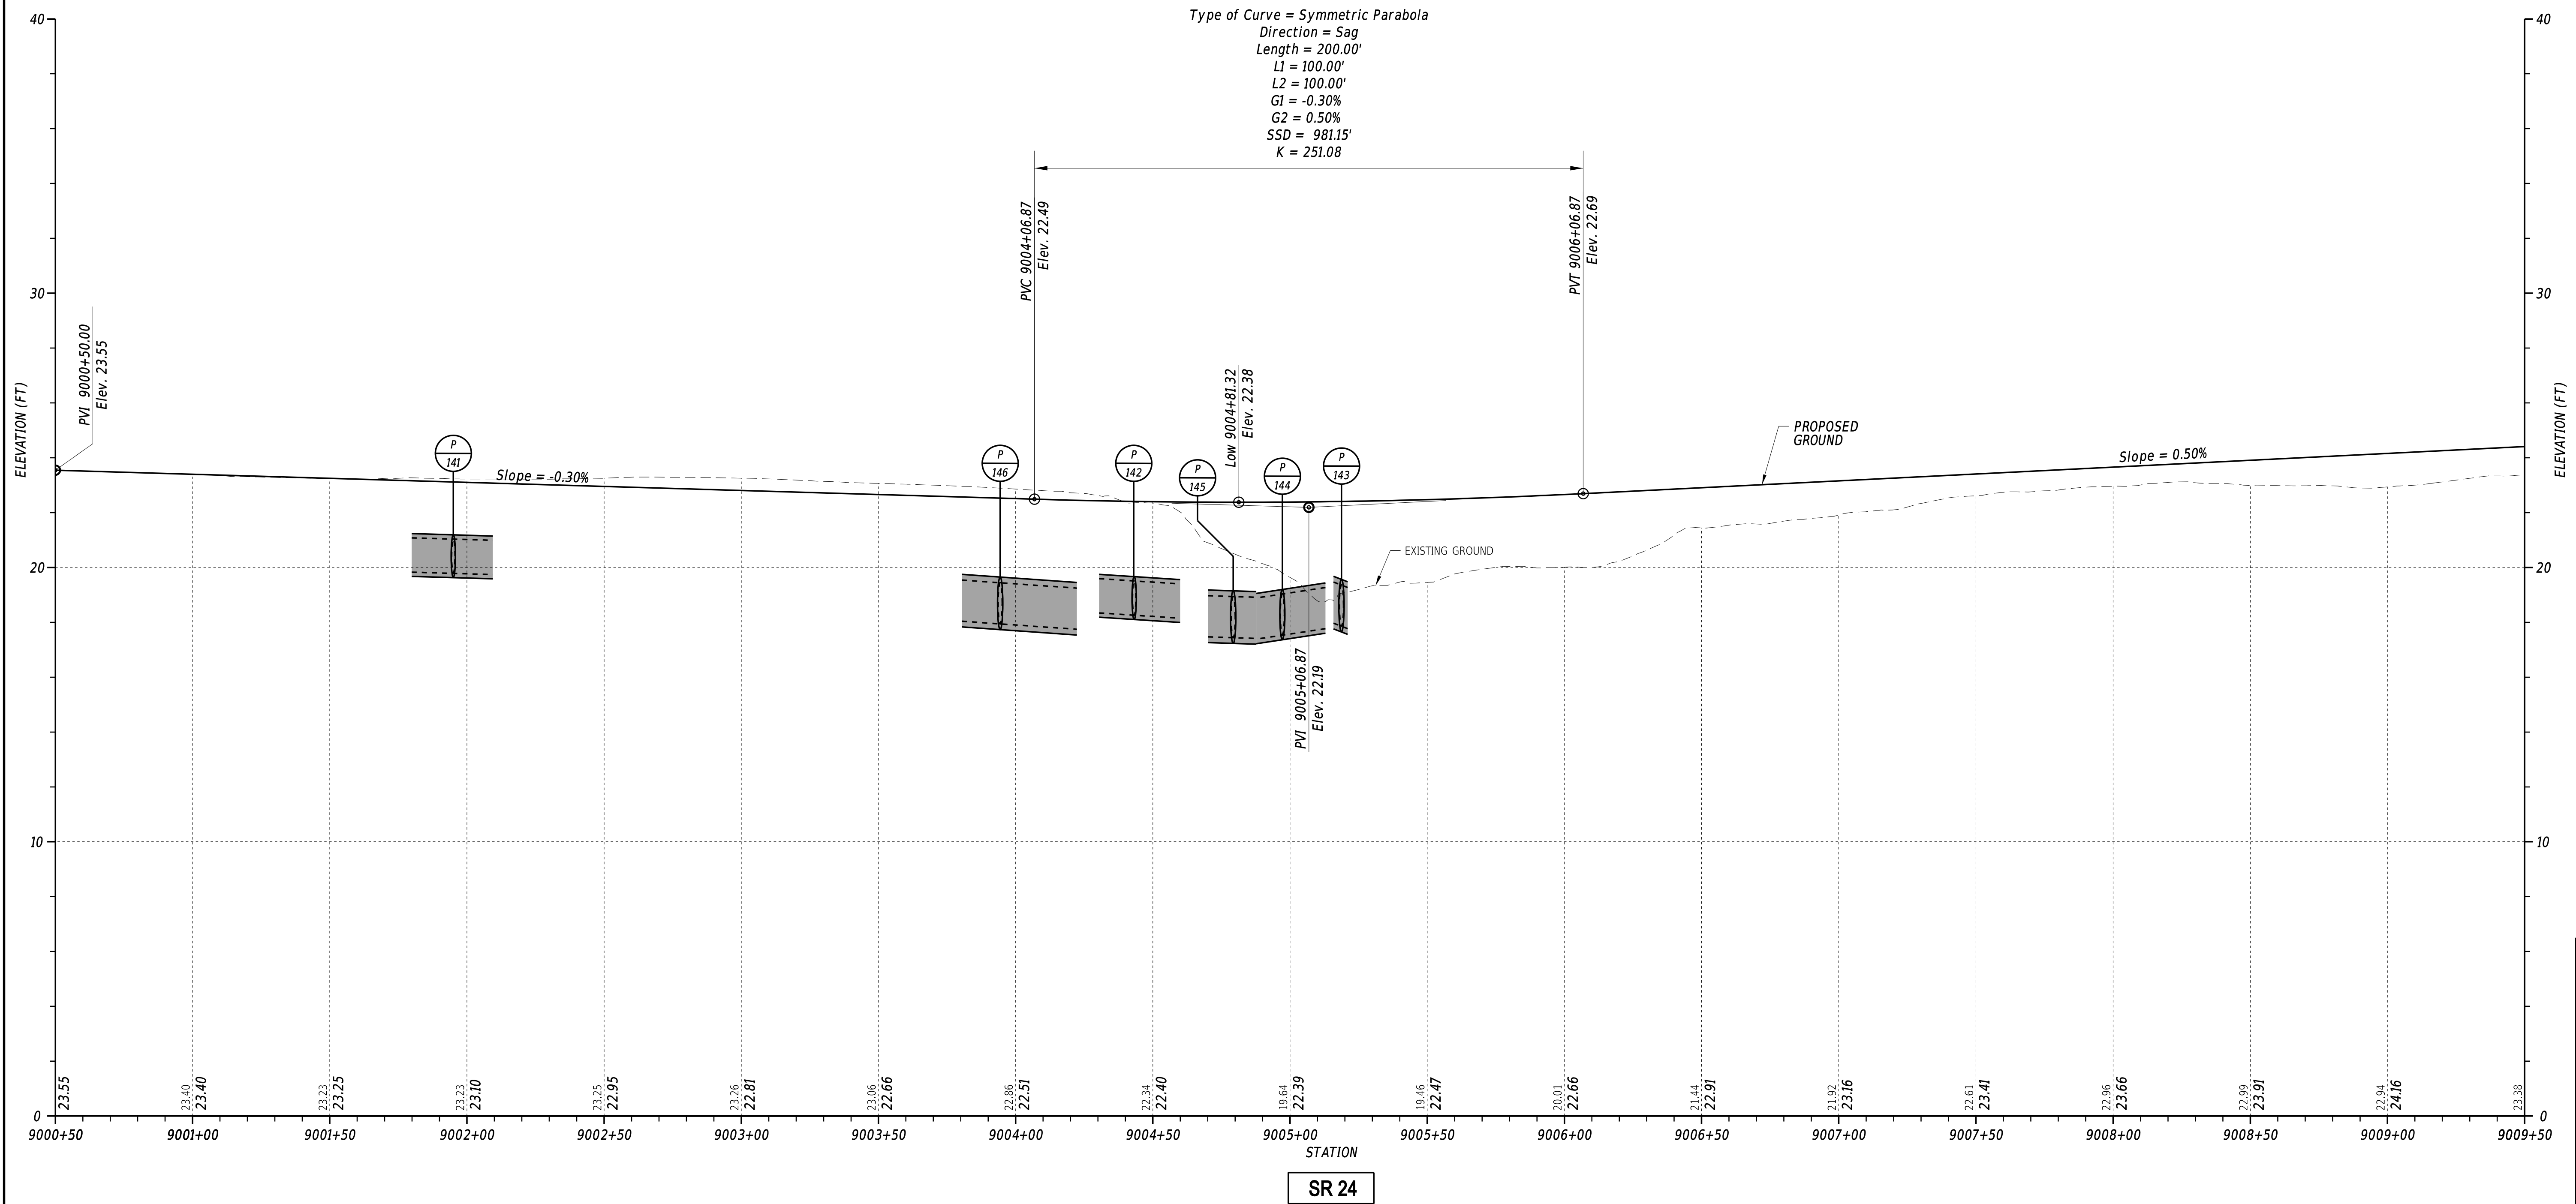


ADDENDA / REVISIONS	

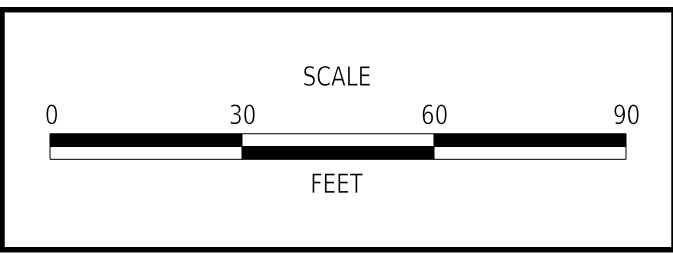


CM/GC,
NORTH MILLSBORO BYPASS,
US 113 TO SR 24

CONTRACT	BRIDGE NO.	N/A
T202112701	DESIGNED BY:	M. FOX
COUNTY	CHECKED BY:	T. OLIVER
SUSSEX		


SECTION
WRA
SHEET NO.
53

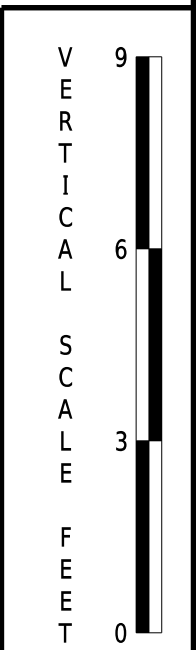


3/4/2022
6:14:04 PM
N:\32149-002\CADD\US 113 NM Bypass\PE17_NMBP.dgn

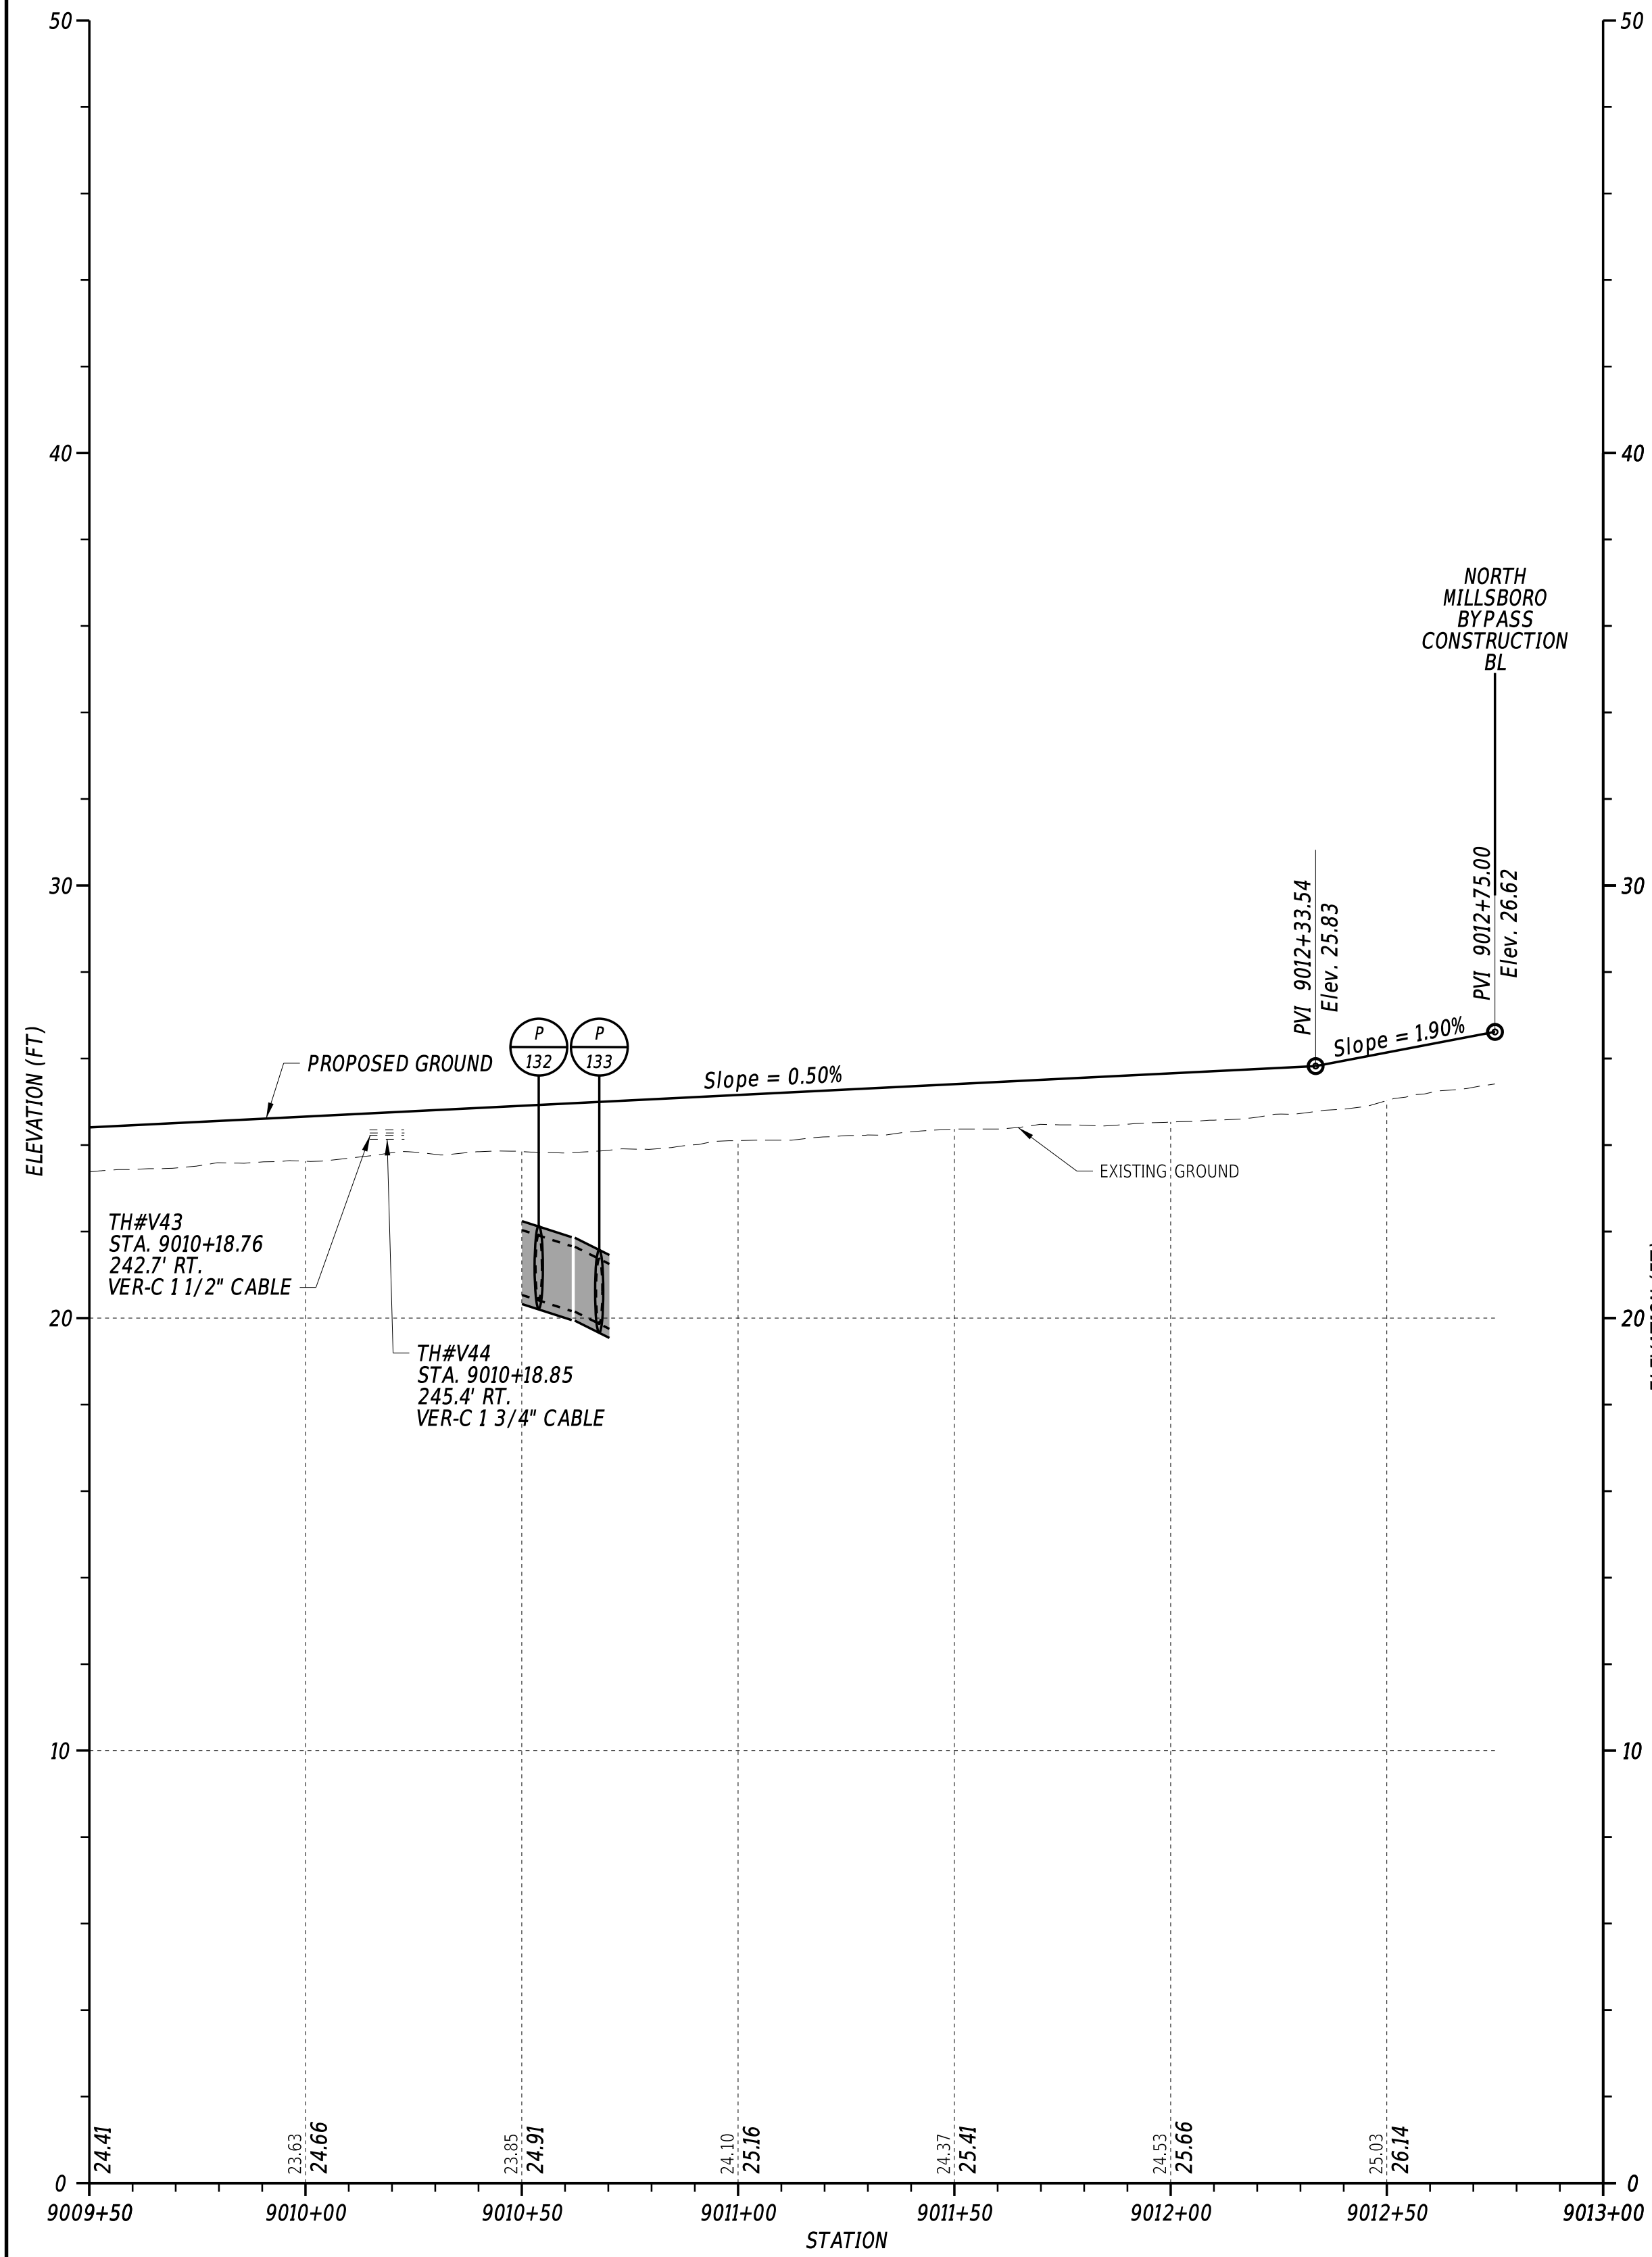

SR 24

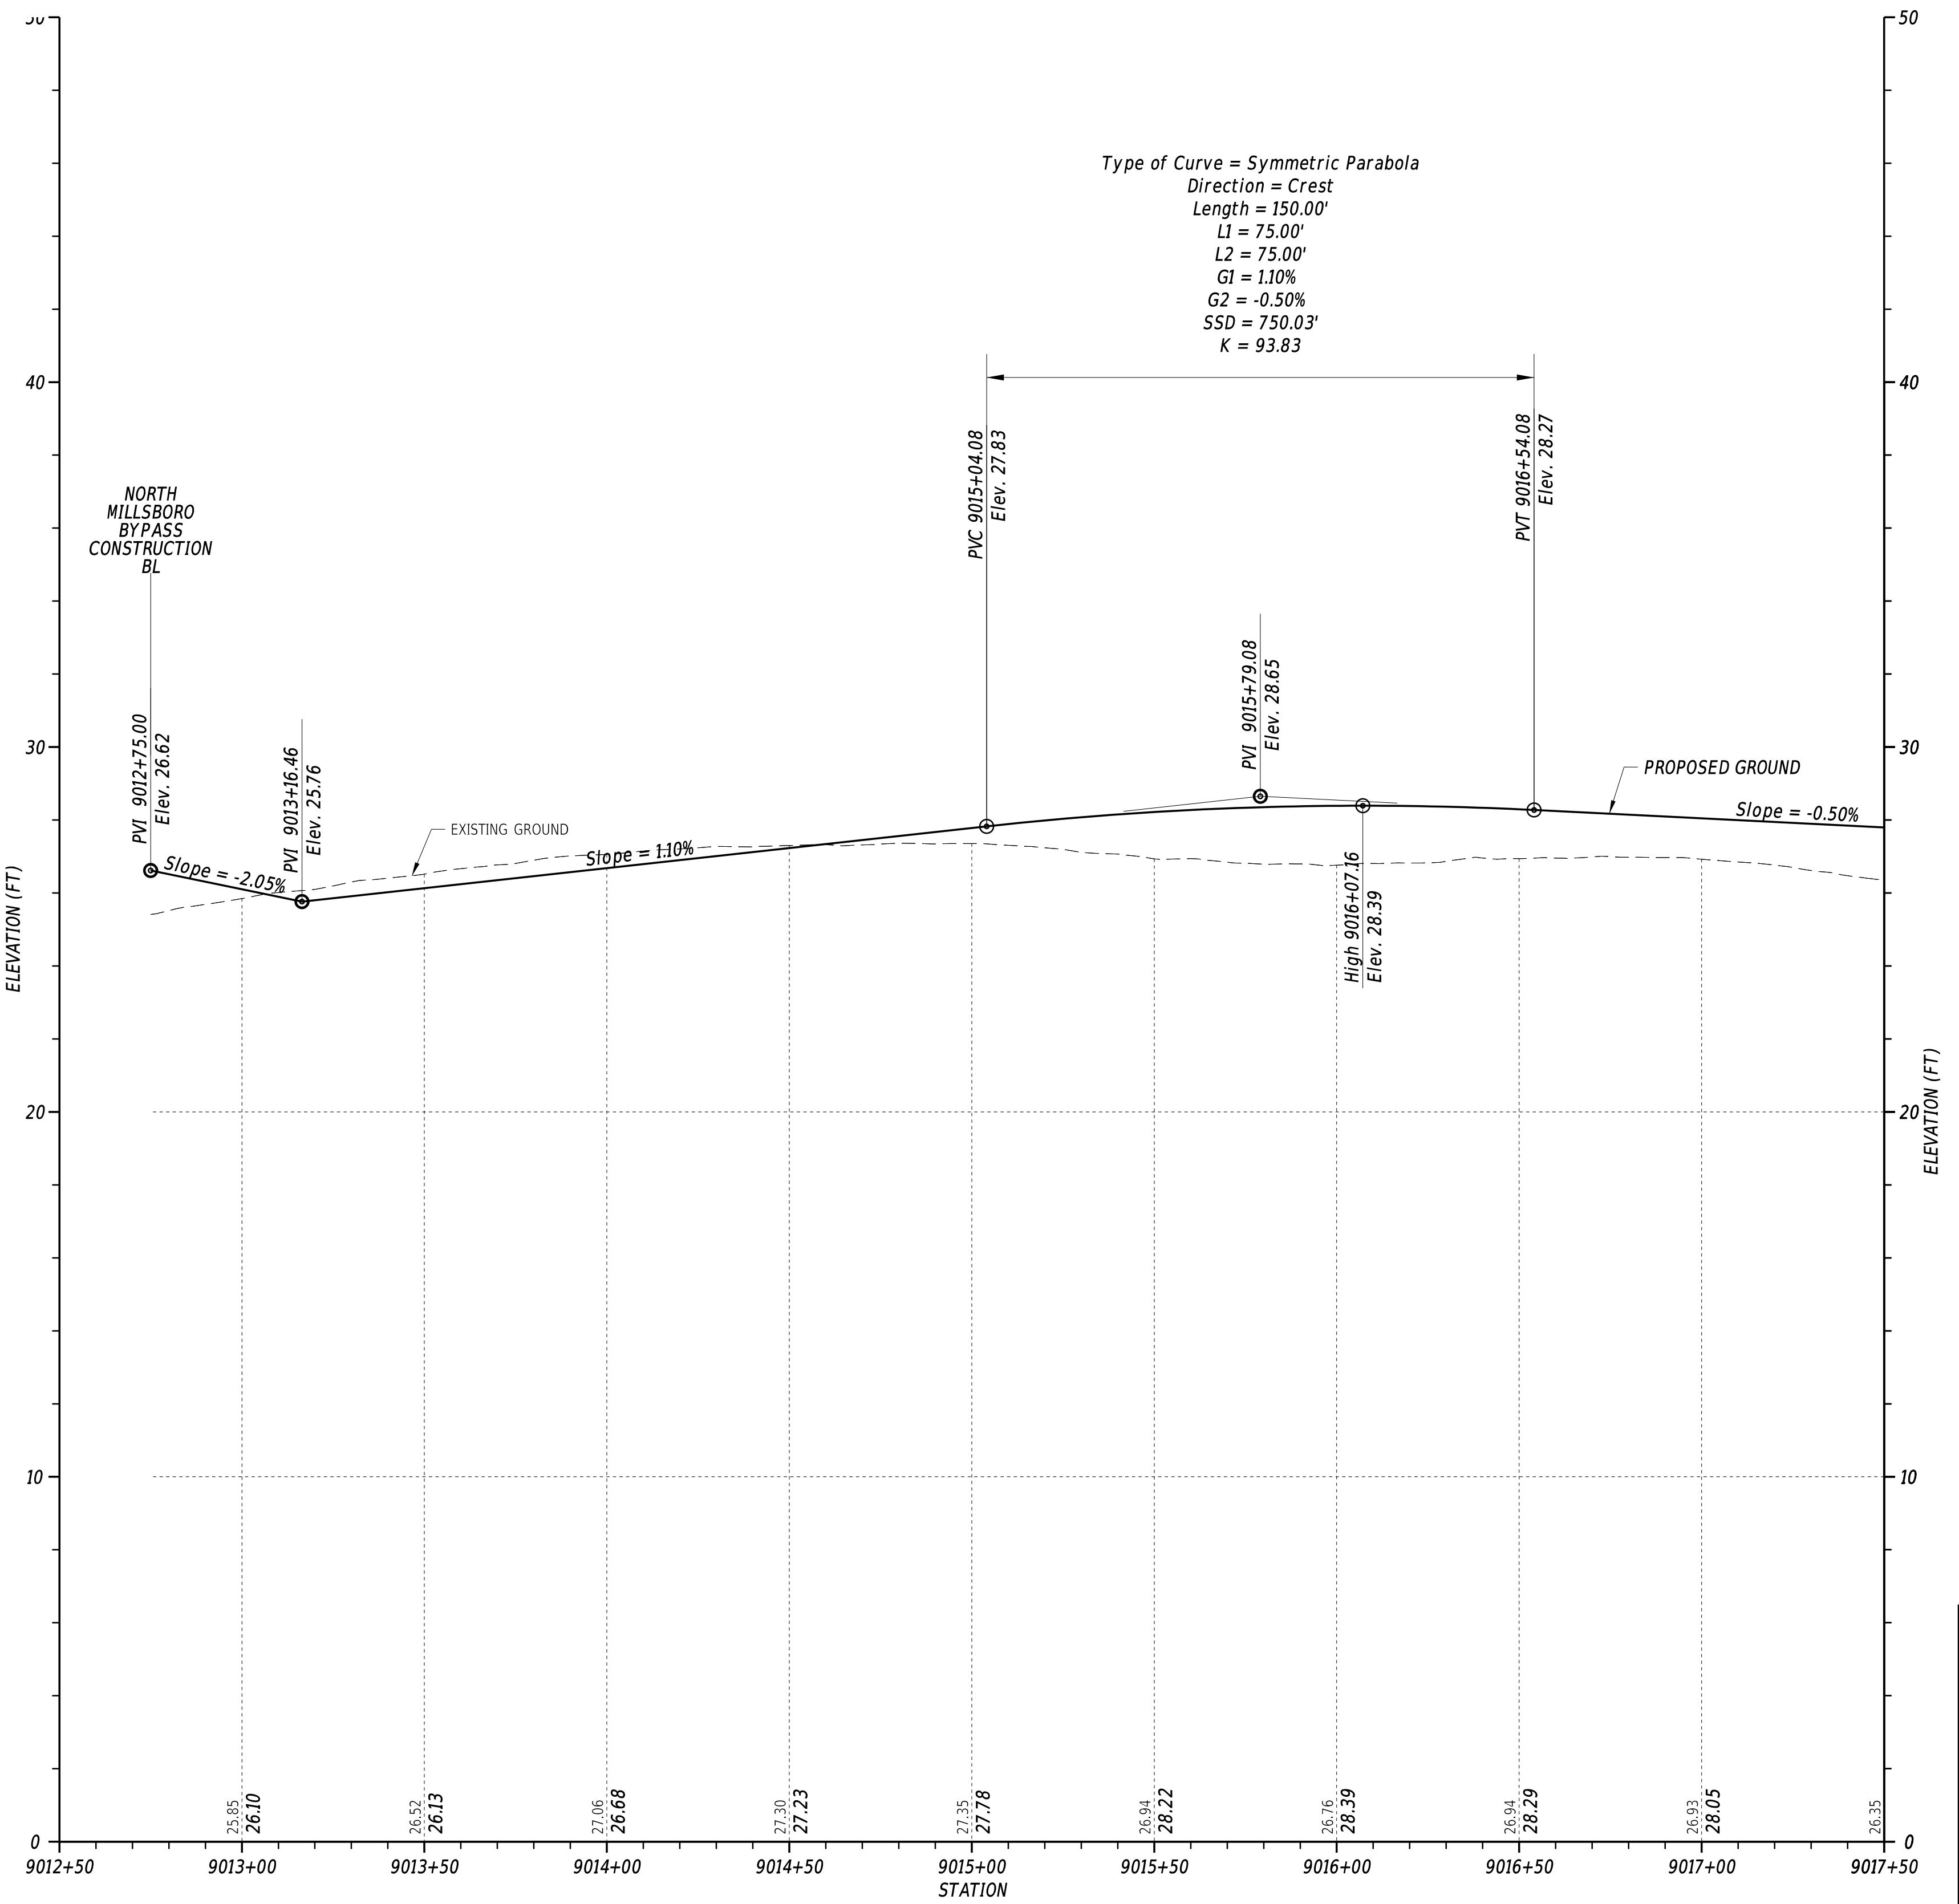


HOLLYVILLE ROAD

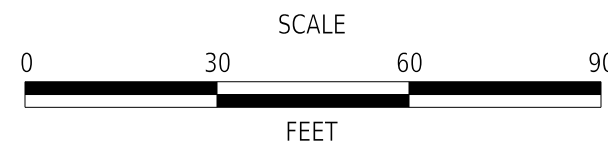

CM/GC,
NORTH MILLSBORO BYPASS,
US 113 TO SR 24


CONTRACT	BRIDGE NO.	N/A
T202112701	DESIGNED BY: M. FOX	
COUNTY	CHECKED BY: T. OLIVER	
SUSSEX		

 PROFILE




SECTION
WRA
SHEET NO.
54


3/4/2022
6:14:05 PM
N:\32149-002\CADD\US 113 NM Bypass\PE18_NMBP.dgn

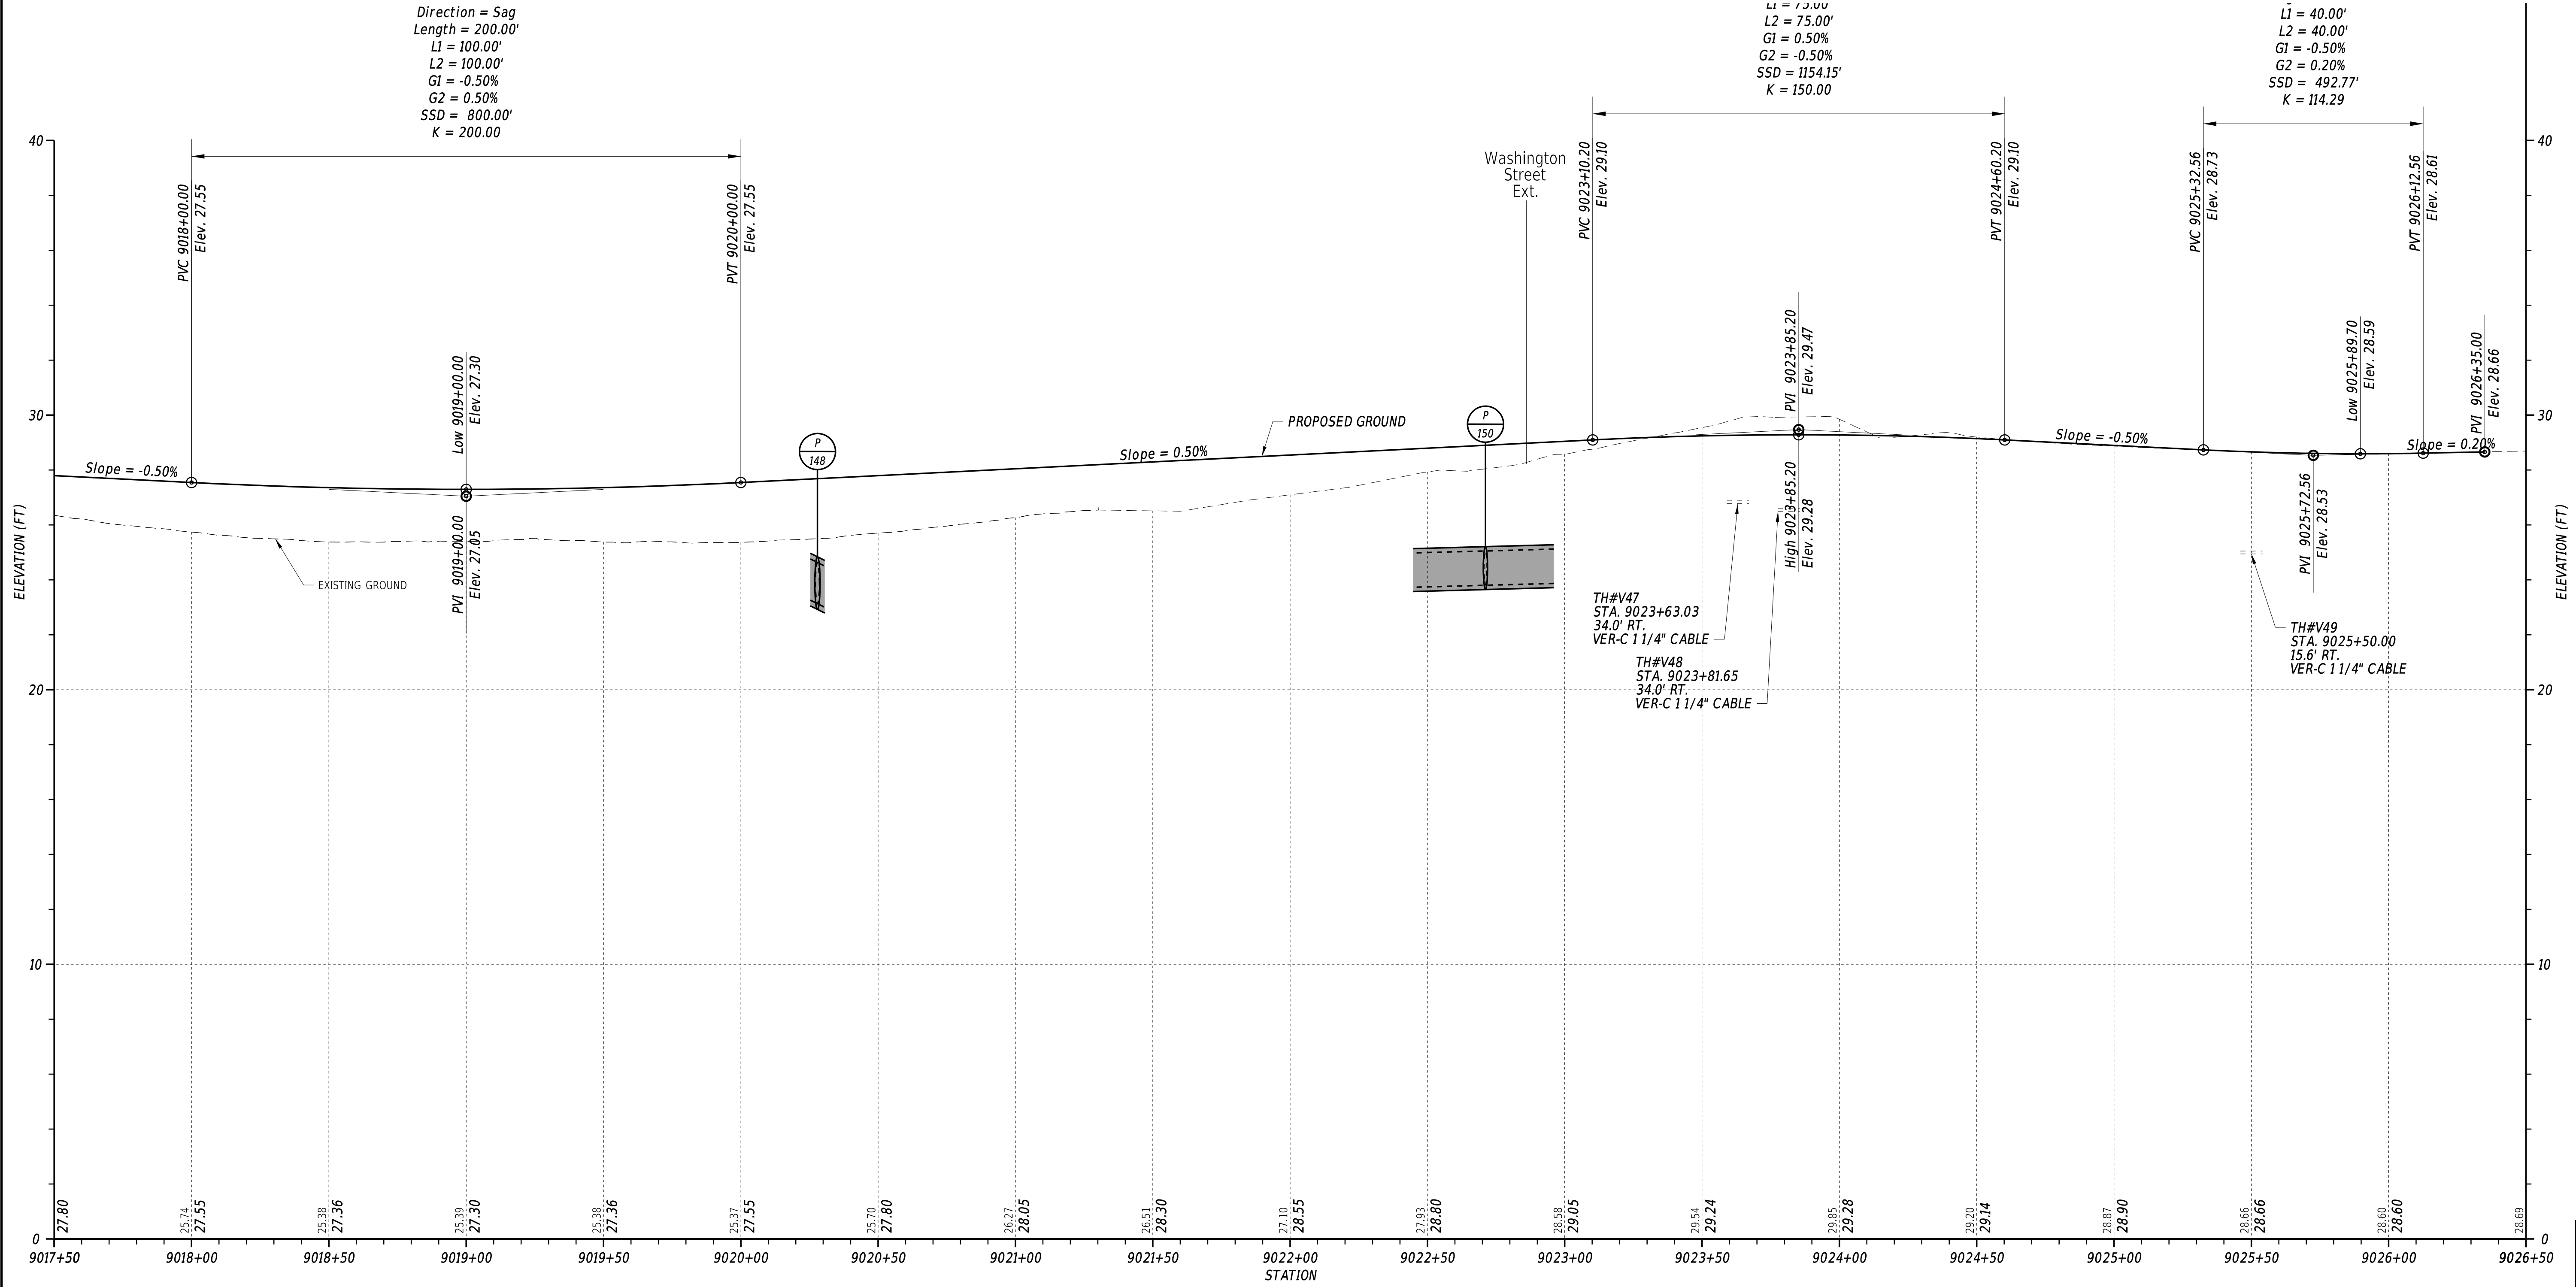

HOLLYVILLE ROAD

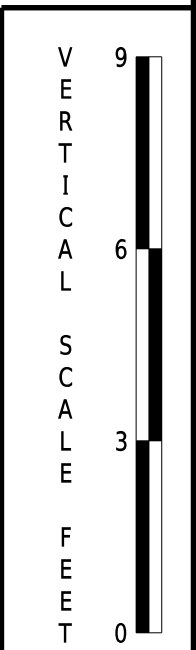

ADDENDA / REVISIONS	

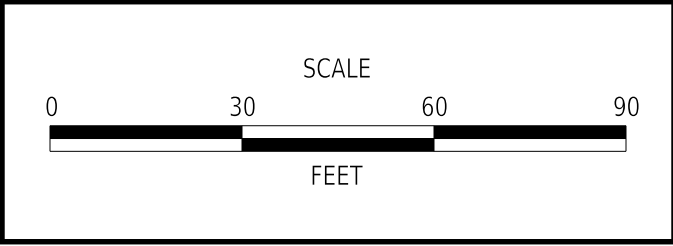


CM/GC,
NORTH MILLSBORO BYPASS,
US 113 TO SR 24


CONTRACT	BRIDGE NO.	N/A
T202112701	DESIGNED BY:	M. FOX
COUNTY	CHECKED BY:	T. OLIVER
SUSSEX		

SECTION
WRA
SHEET NO.
55

3/4/2022
6:14:06 PM
N:\132149-002\CADD\US 113 NM Bypass\PF19_NMBP.dgn

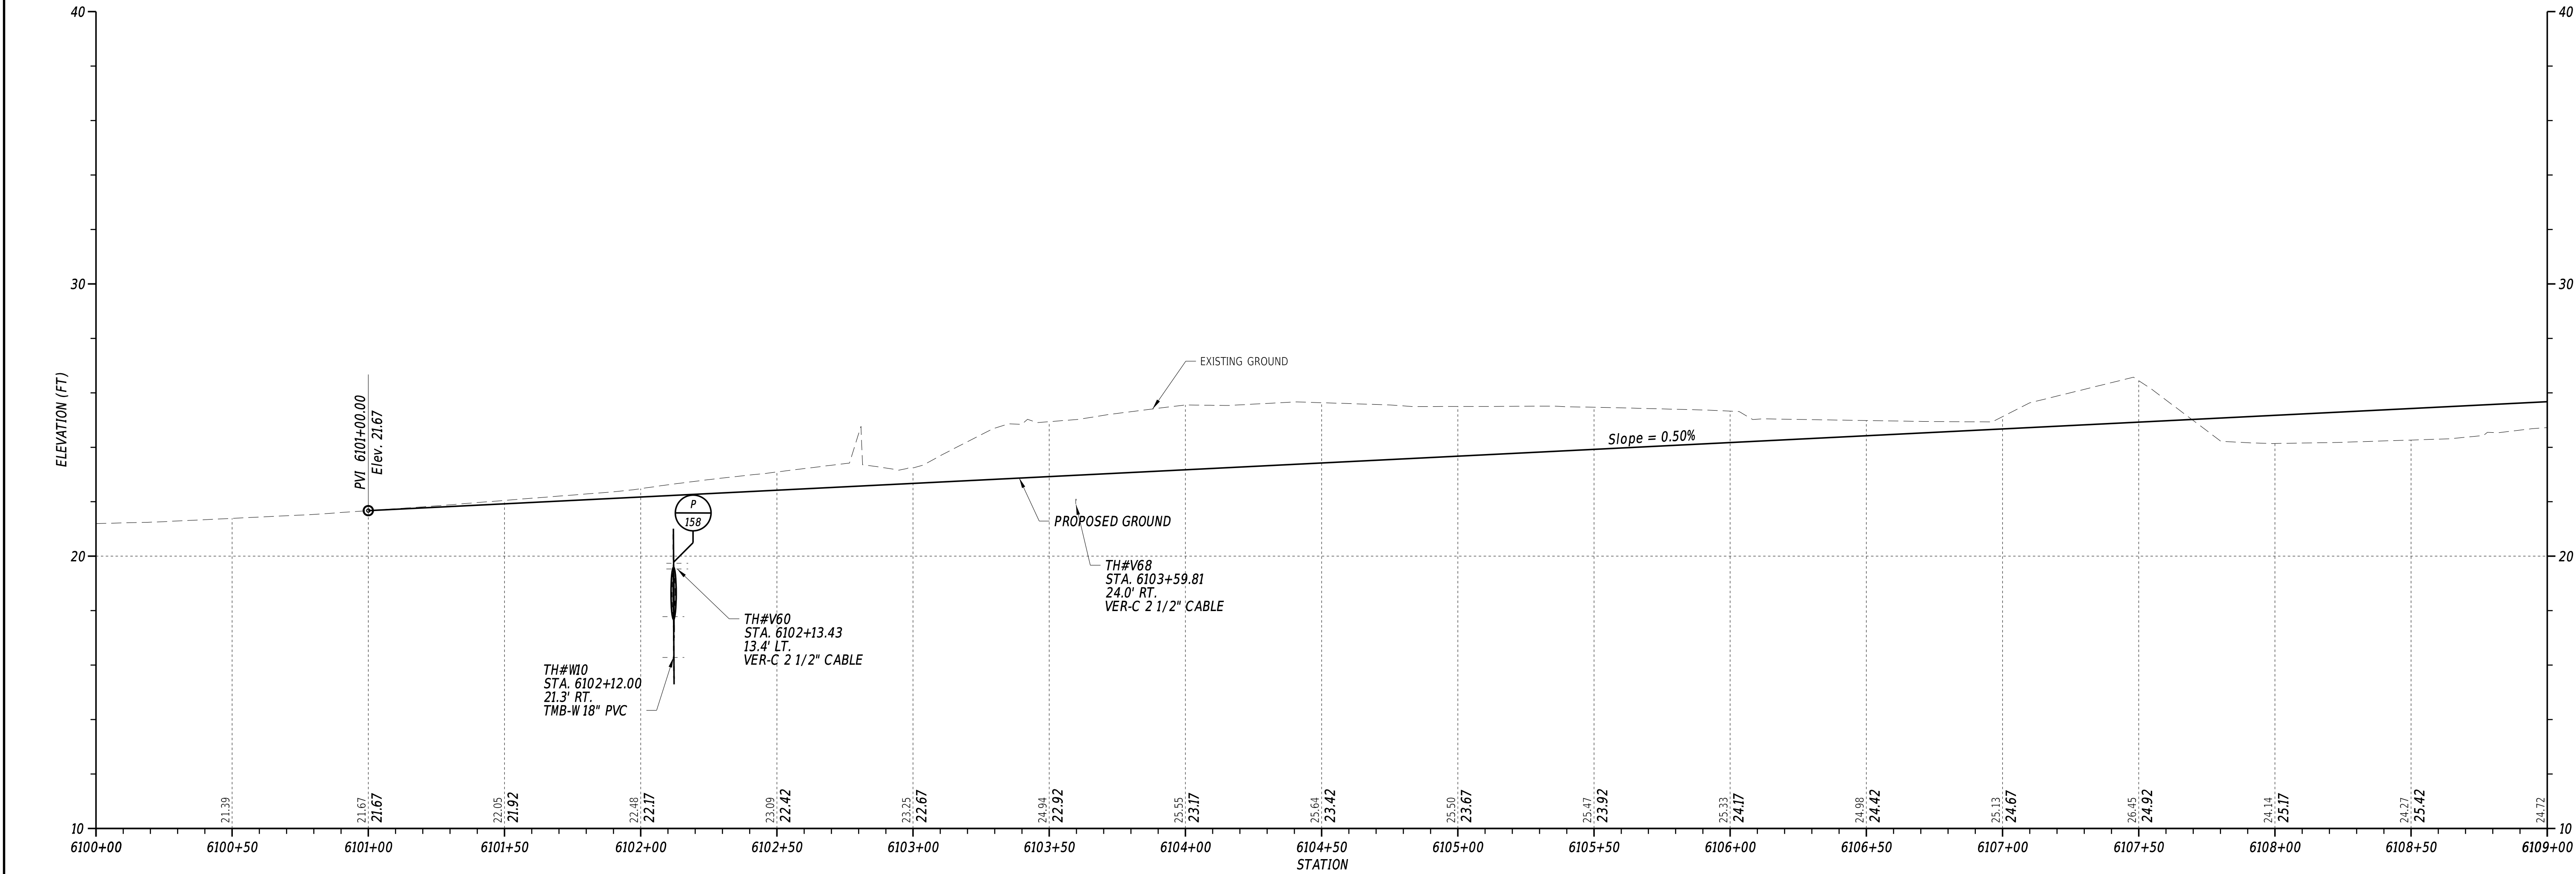

FOX RUN ROAD REALIGNMENT

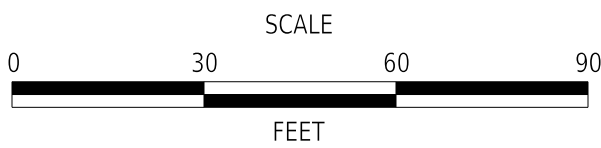

CM/GC,
NORTH MILLSBORO BYPASS,
US 113 TO SR 24


CONTRACT	BRIDGE NO.	N/A
T202112701	DESIGNED BY:	M. FOX
COUNTY	CHECKED BY:	T. OLIVER
SUSSEX		

PROFILE


VERTICAL
SCALE
9
6
3
0
FEET

SECTION
WRA
SHEET NO.
56

3/4/2022
6:14:07 PM
N:\32149-002\CADD\US 113 NM Bypass\PF20_NMBP.dgn

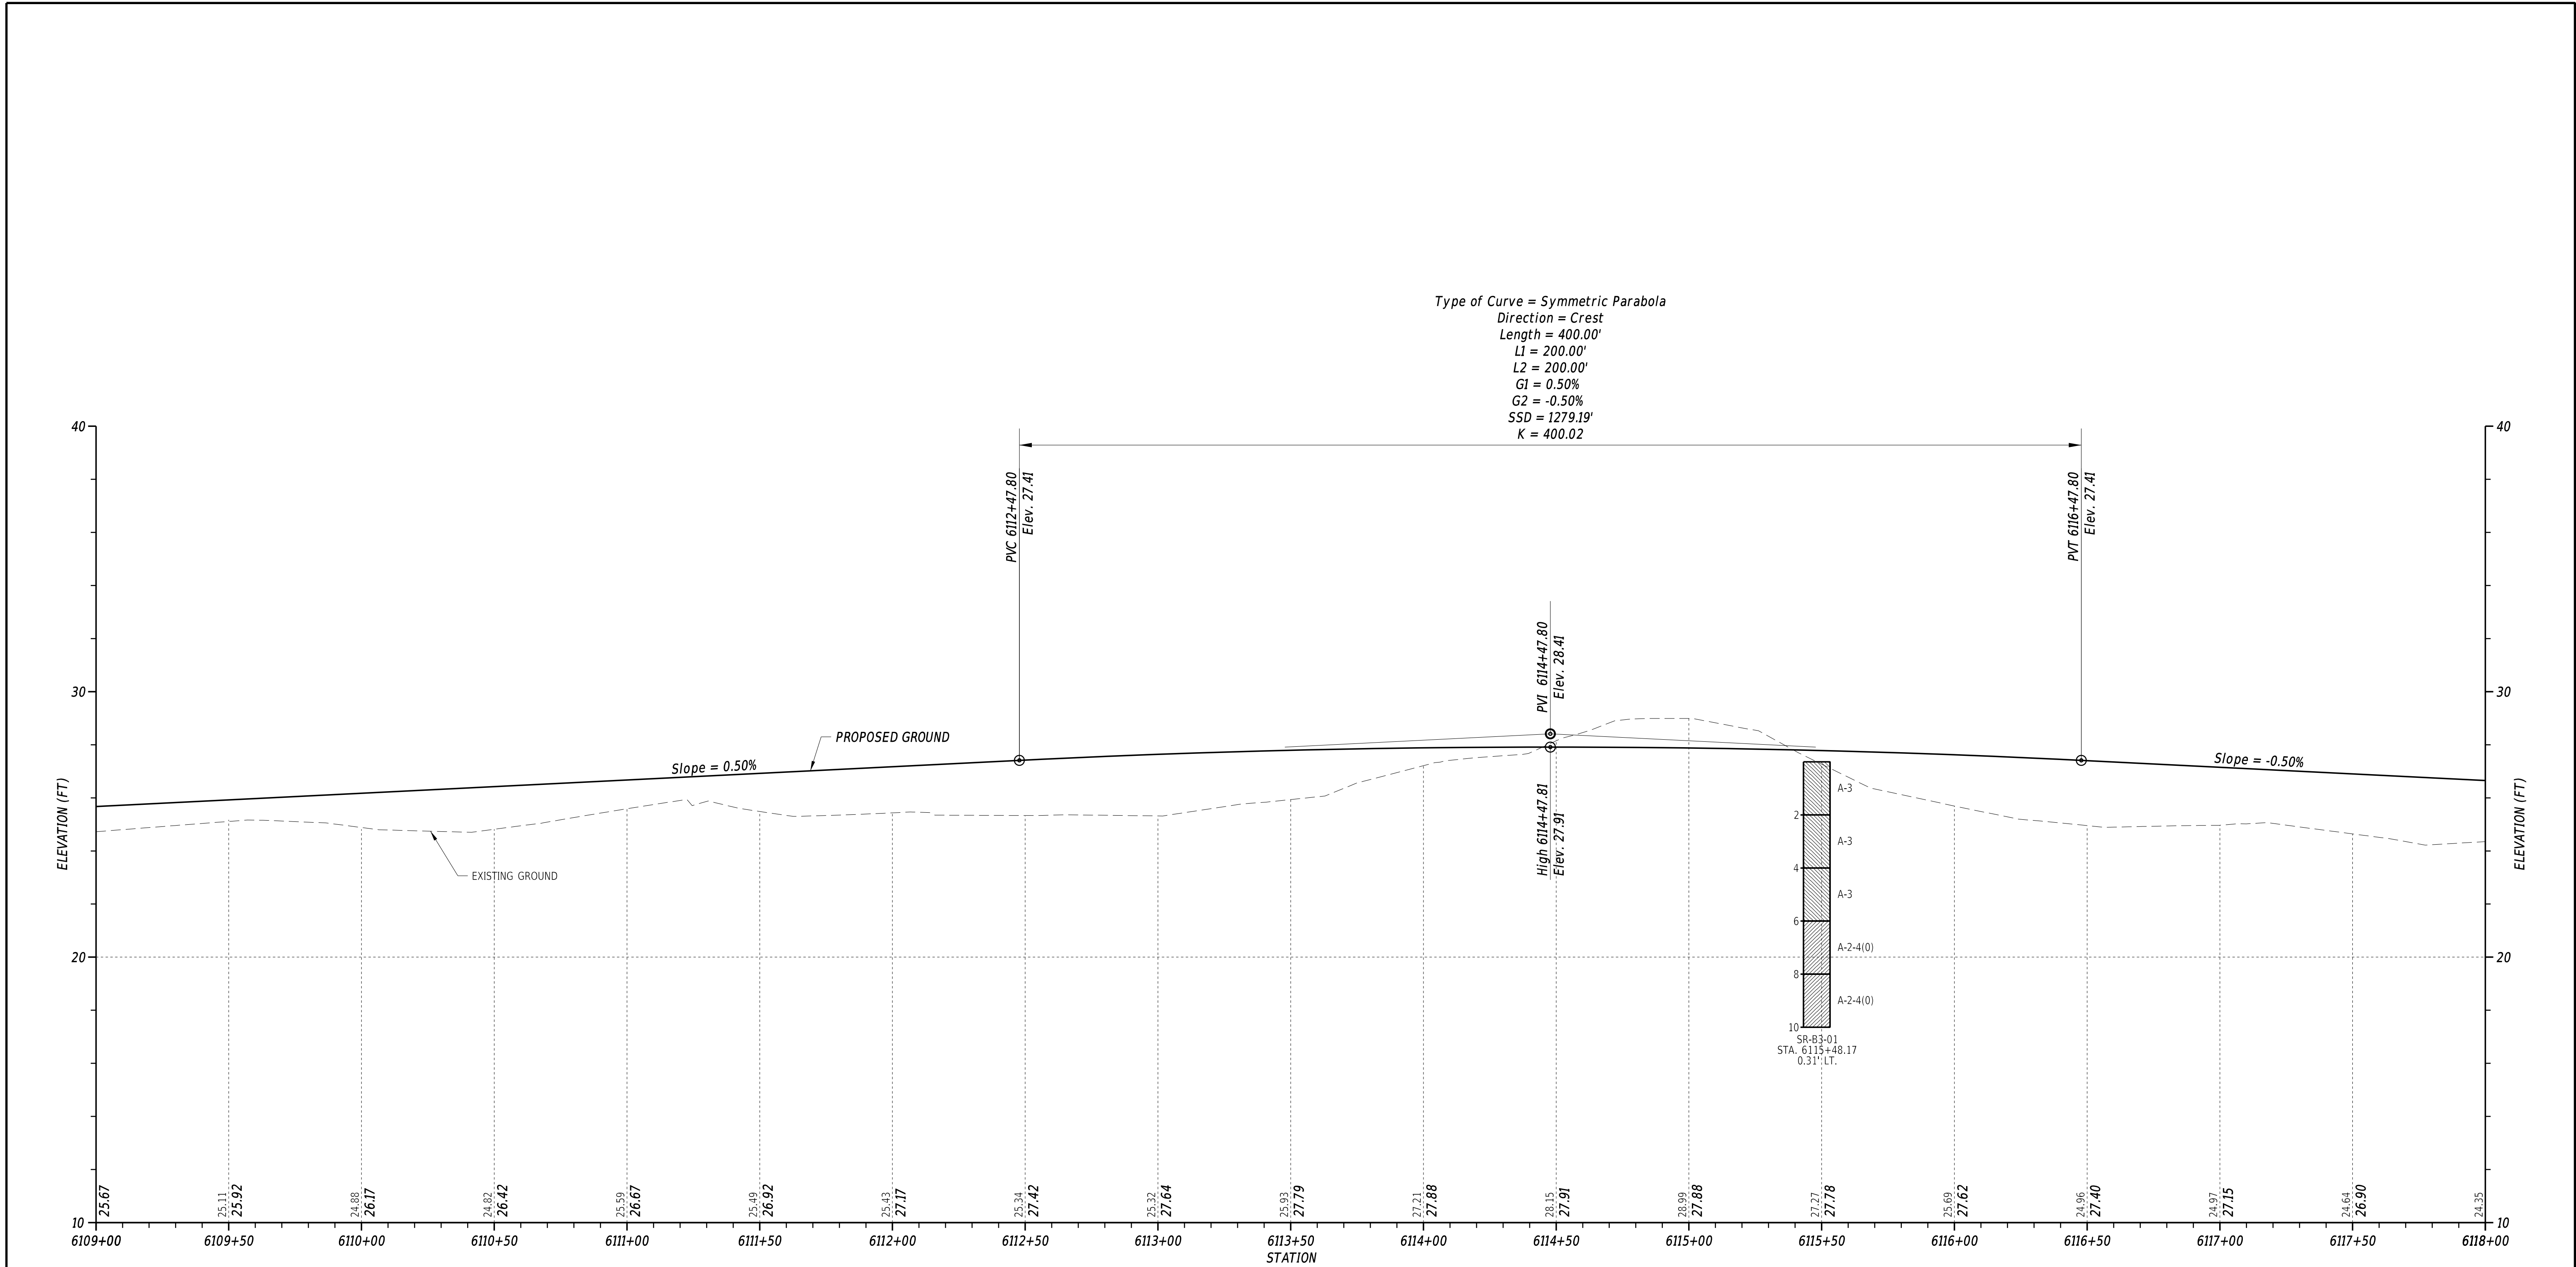


FOX RUN ROAD REALIGNMENT

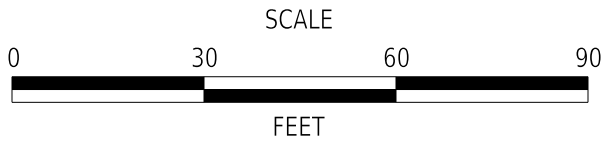

CM/GC,
NORTH MILLSBORO BYPASS,
US 113 TO SR 24


CONTRACT	BRIDGE NO.	N/A
T202112701	DESIGNED BY: M. FOX	
COUNTY	CHECKED BY: T. OLIVER	
SUSSEX		

PROFILE

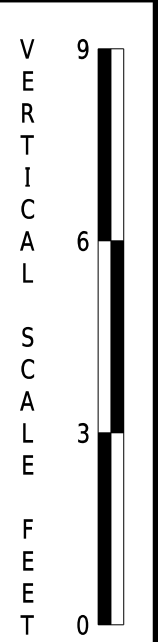


SECTION
WRA
SHEET NO.
57

3/4/2022
6:14:08 PM
N:\132149-002\CADD\US 113 NM Bypass\PF21_NMBP.dgn

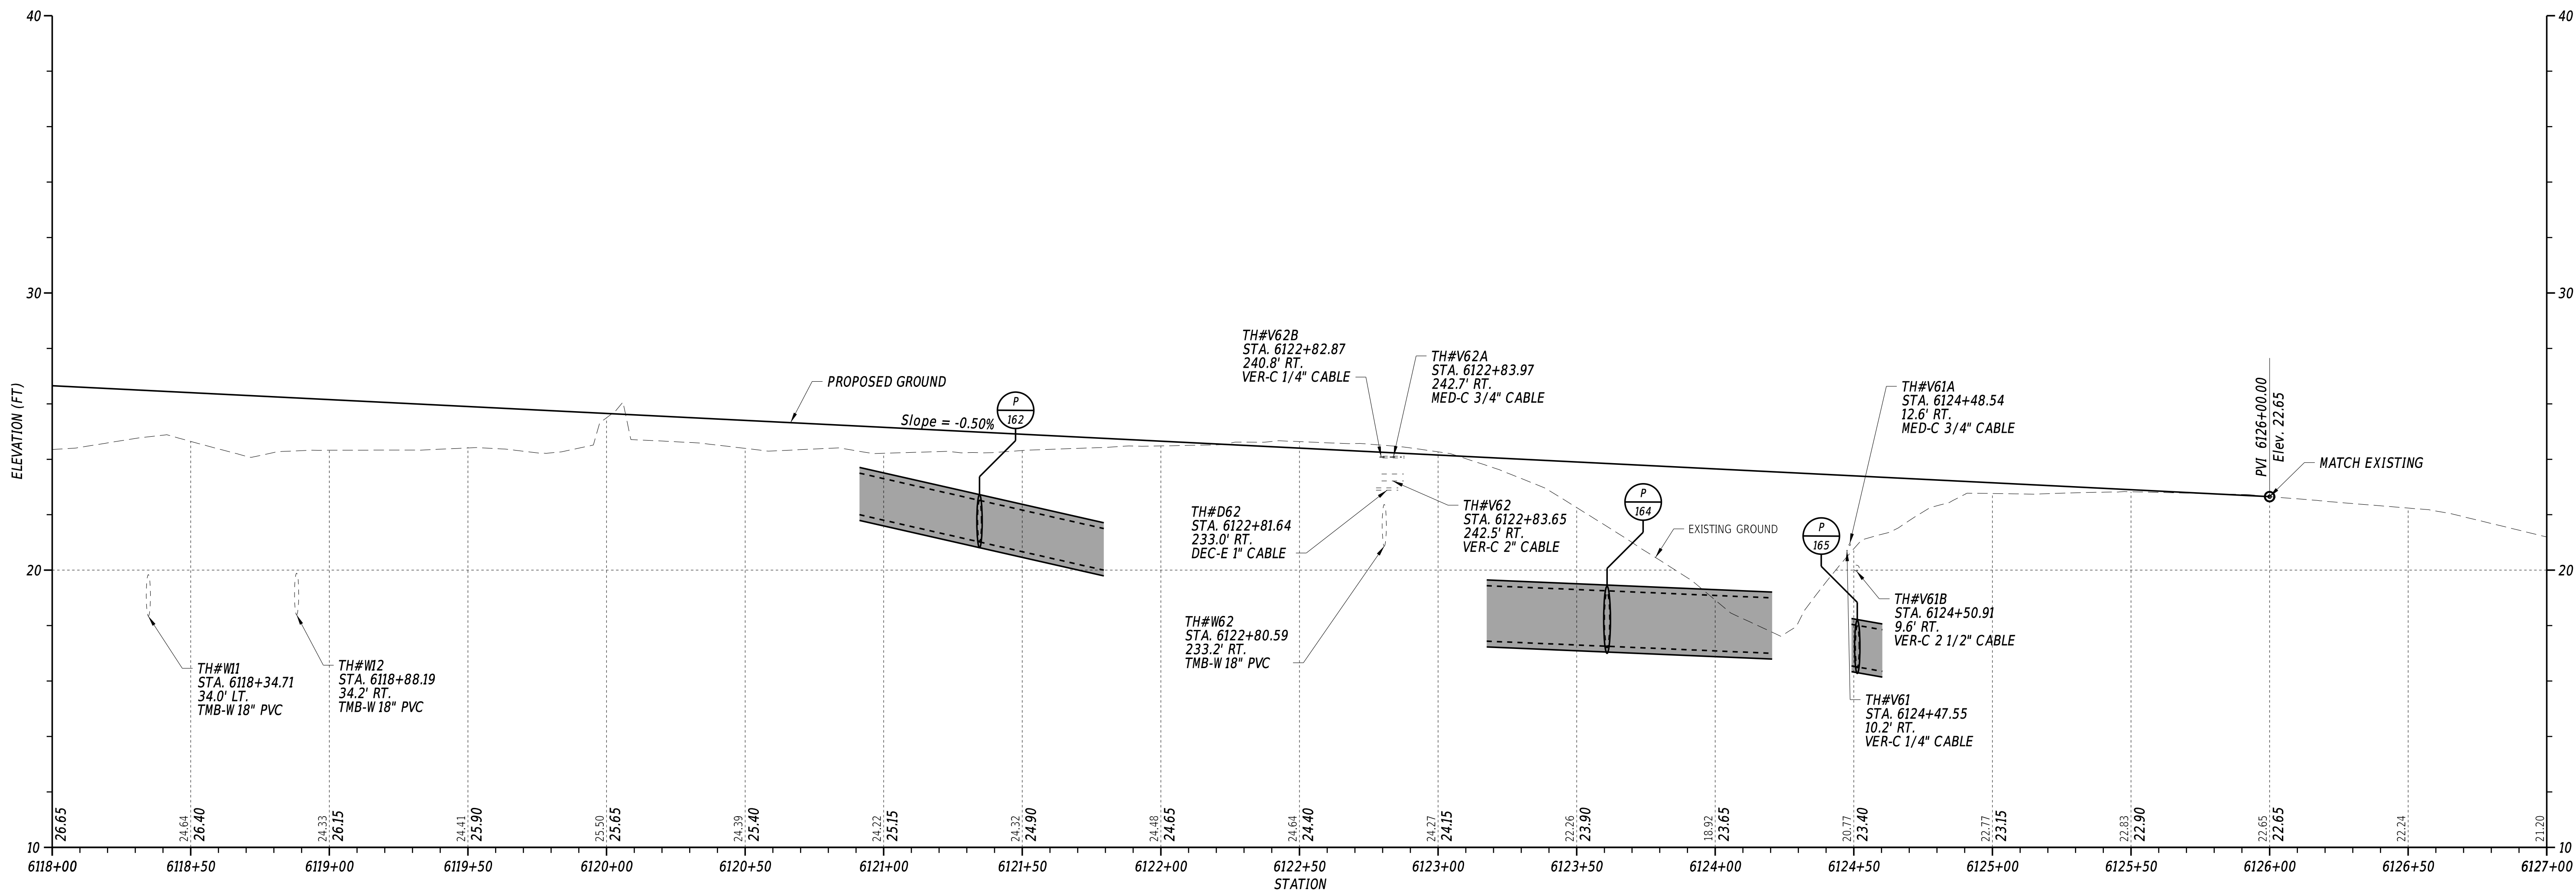


FOX RUN ROAD REALIGNMENT

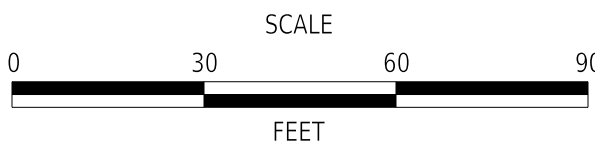

CM/GC,
NORTH MILLSBORO BYPASS,
US 113 TO SR 24

CONTRACT	BRIDGE NO.	N/A
T202112701	DESIGNED BY:	M. FOX
COUNTY	CHECKED BY:	T. OLIVER
SUSSEX		

PROFILE

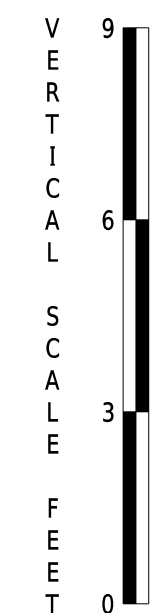

SECTION
WRA
SHEET NO.
58

ENVIRONMENTAL COMPLIANCE NOTES

1. GENERAL NOTES:

- A. THE PURPOSE OF THESE SHEETS IS TO IDENTIFY THOSE ITEMS ASSOCIATED WITH ENVIRONMENTAL COMPLIANCE. IMPACT CALCULATIONS ARE FOR THE AGENCY PERMIT REPORTING PURPOSES ONLY AND ARE NOT TO BE USED FOR BIDDING PURPOSES.
- B. IF A DEPARTURE FROM THE APPROVED PLANS (WHICH WOULD AFFECT ANY NATURAL AND/OR CULTURAL RESOURCES) IS NECESSARY, THE ENVIRONMENTAL STUDIES SECTION SHALL BE CONTACTED AT (302)760-2264 TO ALLOW FOR COORDINATION WITH THE APPROPRIATE RESOURCE AGENCIES AND APPROVAL.
- C. USE OF THESE SHEETS DOES NOT ALLEVIATE THE CONTRACTOR'S RESPONSIBILITY TO COMPLY WITH ALL CONDITIONS SET FORTH IN THE ENVIRONMENTAL STATEMENT AND PERMITS.

2. NATURAL RESOURCES:

- A. PERMIT REQUIREMENTS/APPROVALS*:
- U.S. ARMY CORPS OF ENGINEERS (COE): INDIVIDUAL PERMIT**: PENDING
- DNREC - WETLANDS & SUBAQUEOUS LANDS (WLSL): SUBAQUEOUS LANDS PERMIT **: PENDING
- DNREC - WQC & CZM: PENDING

* THE PERMITS/APPROVALS LISTED ARE THOSE REQUIRED FOR THIS PROJECT. THE ENVIRONMENTAL STUDIES SECTION IS RESPONSIBLE FOR COORDINATING AND/OR OBTAINING THIS APPROVAL.

** THE CONTRACTOR MUST ENSURE THAT THESE PERMITS/APPROVALS ARE IN THEIR POSSESSION PRIOR TO BEGINNING CONSTRUCTION IN THE PERMITTED AREA(S) AND ENSURE IT IS DISPLAYED ON-SITE DURING THE ENTIRE CONSTRUCTION PERIOD.

B. CONSTRUCTION RESTRICTIONS:

FISHERIES:
GAMEFISH/SUNFISH - NO IN-WATER CONSTRUCTION APRIL 1 TO JULY 15
STATE-RARE FISH - NO IN-WATER CONSTRUCTION ACTIVITIES BETWEEN APRIL 1 AND MAY 30

ENDANGERED SPECIES:
NO LIGHTING SHALL BE INSTALLED ALONG THE PROPOSED ROADWAY BETWEEN STA. 1054+00 AND 1090+00
STRIPED MUD TURTLE - NO FOREST CLEARING BETWEEN SEPTEMBER 1 AND DECEMBER 31*

* SMART FENCE WILL BE INSTALLED IN AUGUST 2022 TO ALLOW FOR ADVANCE CLEARING WITHIN THE PROJECT LIMITS STARTING IN JANUARY 2023. THE SMART FENCE WILL SURROUND THE PROJECT AREA TO PREVENT TURTLES AND OTHER WILDLIFE FROM ENTERING THE CLEARING LIMITS.

MIGRATORY BIRDS:
FOREST NESTING BIRDS - NO FOREST CLEARING BETWEEN APRIL 1 AND JULY 31

3. CULTURAL RESOURCES:

- A. PHASE I ARCHAEOLOGICAL SURVEY COMPLETED IN NOVEMBER 2021 IDENTIFIED TWO PRE-CONTACT SITES IN THE VICINITY OF THE MILLSBORO POND THAT ARE LIKELY TO CONTAIN HIGH ARCHAEOLOGICAL INTEGRITY AND ARE POTENTIALLY ELIGIBLE FOR THE NRHP. DELDOT IS PROCEEDING WITH A PHASE II INVESTIGATION TO ASSESS AREAS THAT ARE UNAVOIDABLE.
- B. TRIBAL COORDINATION WITH THE SHPO AND FEDERAL AND STATE TRIBES IS ONGOING.
- C. ANY STAGING AND STOCKPILE AREA(S) OUTSIDE THE PROJECT'S LOC THAT INDIVIDUALLY OR CUMULATIVELY ARE LARGER THAN 10,000 SQUARE FEET MUST BE APPROVED BY DELDOT'S ARCHAEOLOGIST AT DOT_ENVIRONMENTALSTUDIES@DELAWARE.GOV. SUBMIT ALL STAGING AND STOCKPILE AREAS OUTSIDE THE PROJECT'S LOC FOR APPROVAL. WITHIN 30 DAYS, DELDOT WILL:
- a. APPROVE THE USE OF THE PROPOSED STAGING AND STOCKPILE AREA(S)
- b. REJECT THE REQUEST, OR
- c. PERFORM AN ARCHAEOLOGICAL SURVEY TO DETERMINE WHETHER TO APPROVE OR REJECT THE REQUEST, WHICH MAY TAKE UP TO 3 MONTHS
- IF AN ARCHAEOLOGICAL SURVEY IS NECESSARY, DELDOT OR A CONSULTANT ON ITS BEHALF WILL UNDERTAKE THE SURVEY.

4. STREAM RESTORATION AND SLOPE RIPRAP TREATMENT (ADJACENT TO JURISDICTIONAL WATERWAYS):

- A. FOLLOW THE SPECIAL PROVISION FOR ITEM 707500 - CHANNEL BED FILL IN REGARDS TO THE SALVAGING OF ON-SITE NATURAL STREAM BOTTOM MATERIAL OR THE FURNISHING OF OFF-SITE MATERIAL. IF SUFFICIENT SOURCES FOR CHANNEL BED FILL DO NOT EXIST ON-SITE, ANY NEW MATERIAL MUST CONFORM TO THE REQUIREMENTS OF ITEM 707500 - CHANNEL BED FILL. RECESS ALL RIPRAP IN THE CHANNEL BOTTOM (I.E. BELOW THE WATER LINE) ONE FOOT BELOW STREAM BED ELEVATION AND CHOKE WITH BORROW TYPE 'B' SO THAT ALL OF THE VOIDS IN THE RIPRAP ARE FILLED WITH SPECIFIED MATERIAL. PAYMENT UNDER ITEM 209002 - BORROW, TYPE B. COVER THE RIPRAP WITH A MINIMUM OF 12" CHANNEL BED FILL. MATCH THE FINAL ELEVATIONS WITH EXISTING ELEVATIONS AT THE UPSTREAM AND DOWNSTREAM PROJECT LIMITS. THROUGH THE STRUCTURE, ELEVATIONS WILL BE AS NOTED ON THE PLANS. PAYMENT UNDER ITEM 707500 - CHANNEL BED FILL.
- B. RESTORE OTHER AREAS OF THE CHANNEL BOTTOM AFFECTED BY CONSTRUCTION (INCLUDING, BUT NOT LIMITED TO, THE LOCATION OF SUMP PITS, STABILIZED OUTFALLS, TEMPORARY PIPES AND/OR SANDBAG DIKES AND DIVERSIONS) TO EXISTING CONDITIONS. FILL ANY CAVITIES OR SCOUR HOLES RESULTING FROM CONSTRUCTION ACTIVITIES WITH CHANNEL BED FILL. PAYMENT UNDER ITEM 707500 - CHANNEL BED FILL.
- C. WHEN ALL EROSION AND SEDIMENT CONTROL MEASURES ARE REMOVED AND THE STREAM RETURNS TO ITS NATURAL FLOW CONDITIONS, THE FLOW MUST REMAIN ABOVE GROUND AND ABOVE THE RIPRAP (I.E. THE FLOW CANNOT BE "LOST" IN THE RIPRAP OR BENEATH THE STRUCTURE). IF THIS IS NOT ACHIEVED, THE CONTRACTOR WILL BE REQUIRED TO TAKE CORRECTIVE ACTION AT THE CONTRACTOR'S EXPENSE.
- D. CHOKE ALL RIPRAP ON THE STREAM BANK, OUTSIDE THE CHANNEL BED, WITH DELAWARE #57 STONE. PLACE JUST ENOUGH CHOKE MATERIAL TO PREVENT THE LOSS OF CHANNEL BED FILL OR TOPSOIL (DEPENDING ON LOCATION AS INDICATED BELOW) THROUGH THE RIPRAP. AFTER PLACING DELAWARE #57 STONE, PERFORM A FINAL CHOKE OF CHANNEL BED FILL SO THAT THE RIPRAP PEAKS ARE BARELY VISIBLE. PLACE AN ADDITIONAL 6-INCH TOPSOIL LAYER ON TOP OF THE RIPRAP. SLOPE SEEDING WILL BE DONE WITH ITEM 908019 - STREAMBANK SEED MIX, SEEDING. FOLLOWING THE SEEDING OPERATION, INSTALL ITEM 908020 - EROSION CONTROL BLANKET (ECB) MULCH, OR OTHER BLANKET AS SHOWN ON THE PLANS. ECB AT TOE OF SLOPE CAN BE EITHER TRENCHED IN OR STAPLED AT 6" ON CENTER. COMPLETE ALL WORK, STARTING WITH THE INITIAL CHOKING WITH TOPSOIL THROUGH THE SEEDING AND MULCHING PRIOR TO ANY RAIN EVENT. DELAWARE #57 STONE IS INCIDENTAL TO THE RIPRAP ITEM. ALL OTHER ITEMS WILL BE PAID FOR UNDER THEIR RESPECTIVE ITEMS.

5. PROTECTION OF RESOURCES

- A. KEEP CLEARING IN WETLAND AREAS TO A MINIMUM ABSOLUTELY NECESSARY FOR CONSTRUCTION ACCESS. SUPPORT ALL EQUIPMENT TRAVERSING WETLANDS AND SUBAQUEOUS LAND ON MATS. PAYMENT FOR MATS WILL BE MADE UNDER ITEM 621500 - TEMPORARY TIMBER MAT. IN WETLAND AREAS THAT ARE CLEARED, NO GRUBBING EXCEPT WHERE NECESSARY TO CONSTRUCT PROJECT COMPONENTS SUCH AS FOUNDATIONS AND RIPRAP PROTECTION IS PERMITTED. CUT VEGETATION FLUSH WITH THE GROUND (I.E. NO DISTURBANCE OF THE ROOT MAT). RESTORE TEMPORARILY DISTURBED WETLAND AREAS TO GRADE AND SEED WITH ITEM 908017 - TEMPORARY GRASS SEEDING (ANNUAL RYEGRASS).
- B. USE SILT FENCE OR CONSTRUCTION SAFETY FENCE ALONG THE LIMITS OF CONSTRUCTION IN ALL AREAS WHERE WATER/WETLANDS ARE BEING IMPACTED (AS SHOWN ON ENVIRONMENTAL COMPLIANCE SHEETS), AND ALSO IN ANY AREA WHERE WATER/WETLANDS EXIST WITHIN 20 FEET OF THE LIMIT OF CONSTRUCTION (AS SHOWN ON CONSTRUCTION PLAN SHEETS). ANY CONTRACTOR ACCESS BEYOND THE LIMIT OF CONSTRUCTION IS STRICTLY PROHIBITED.
- C. USE SANDBAGS OR COMPOST FILTER LOG (CFL) TO SECURE SILT FENCE AT AREAS ADJACENT TO WOODED UPLANDS/ALL WETLANDS IN LIEU OF TRENCHING UNLESS PROPER EROSION AND SEDIMENT CONTROL CANNOT BE MAINTAINED. SANDBAGS AND CFL'S (AND CONTENTS) MUST BE REMOVED IN THEIR ENTIRETY WHEN NO LONGER NEEDED. SANDBAGS/CFL USED TO SECURE THE SILT FENCE IS INCIDENTAL TO ITEM 905001 - SILT FENCE. THE ENVIRONMENTAL STUDIES SECTION (TREVOR MCCOLLEY, 302- 760-2278) CAN PROVIDE FURTHER GUIDANCE REGARDING THIS METHOD OF INSTALLATION.
6. MITIGATION: NOT REQUIRED
7. PLANTING GUIDANCE (INFORMATION ONLY. WORK TO BE DONE BY OTHERS. THERE WILL BE NO PAYMENT FOR PLANTING ON THIS CONTRACT.) UPON FINAL ACCEPTANCE OF THE CONTRACT, NOTIFY THE ENVIRONMENTAL STUDIES SECTION (CHRISTIE BONNIWELL) AND ROADSIDE ENVIRONMENTAL (DARIN CALLAWAY) OF COMPLETION. PLANT APPROPRIATE TREES AND/OR SHRUBS IN A NATURALIZED PATTERN (MINIMUM 8', MAXIMUM 12' CENTERS) TO PROVIDE A VEGETATIVE BUFFER ALONG WATERWAYS WITHIN THE LOC. SPECIFIC PLANT SELECTION IS AT THE DISCRETION OF THE ROADSIDE PLANTING MITIGATION FOR FOREST REMOVAL AS BEEN PREPARED. ENVIRONMENTAL ADMINISTRATOR OR APPOINTED DESIGNEE BUT MUST BE A NATIVE SPECIES APPROVED BY THE DELAWARE DEPARTMENT OF NATURAL RESOURCES. A PROPOSED PLANTING MITIGATION PLAN HAS BEEN PREPARED FOR THIS PROJECT.

PERMANENT OPEN WATER IMPACT AREA SCHEDULE					
ID	IMPACT DESCRIPTION	AREA (SF)	AREA (AC)	VOLUME (CY)	JURISDICTION
0-01	BRIDGE PIER FOUNDATION	32.00	0.0007	2.3704	DNREC
0-02	BRIDGE PIER FOUNDATION	32.00	0.0007	2.3704	DNREC
0-03	BRIDGE PIER FOUNDATION	32.00	0.0007	2.3704	DNREC
0-04	BRIDGE PIER FOUNDATION	32.00	0.0007	2.3704	DNREC
0-05	BRIDGE PIER FOUNDATION	32.00	0.0007	2.3704	DNREC
0-06	BRIDGE PIER FOUNDATION	32.00	0.0007	2.3704	DNREC
0-07	BRIDGE PIER FOUNDATION	8.00	0.0002	0.5926	DNREC
0-08	BRIDGE (SHADE)	33,722.00	0.7741	N/A	DNREC
0-09	BRIDGE PIER FOUNDATION (FILL)	839.67	0.0193	62.1980	USACE/DNREC
0-10	BRIDGE PIER FOUNDATION (FILL)	803.48	0.0184	59.5170	USACE/DNREC
0-11	BRIDGE (SHADE)	6,542.65	0.1502	N/A	DNREC
0-12	BRIDGE (SHADE)	7,973.10	0.1830	N/A	DNREC
0-13	BRIDGE (SHADE)	5,652.76	0.1298	N/A	DNREC
TOTAL (USACE)		1643.15	0.0377	121.7150	USACE
TOTAL (DNREC)		55,733.66	1.2795	136.5300	DNREC

PERMANENT WETLAND IMPACT AREA SCHEDULE					
ID	IMPACT DESCRIPTION	AREA (SF)	AREA (AC)	VOLUME (CY)	JURISDICTION
W-01	BRIDGE PIER FOUNDATION	0.13	0.000003	0.0096	USACE
W-02	BRIDGE PIER FOUNDATION	12.63	0.0003	0.9356	USACE
TOTAL		12.76	0.0003	0.9452	USACE

NOTE: PERMANENT USACE IMPACTS ARE CONSIDERED A LOSS.


TEMPORARY OPEN WATER IMPACT AREA SCHEDULE					
ID	IMPACT DESCRIPTION	AREA (SF)	AREA (AC)	VOLUME (CY)	JURISDICTION
OT-03	TRESTEL (PILES)	501.87	0.0115	37.176	USACE/DNREC
OT-04	TRESTEL (SHADE)	16,066.60	0.3688	N/A	DNREC
TOTAL (USACE)		501.87	0.0115	37.176	USACE
TOTAL (DNREC)		16,568.47	0.3803	37.176	DNREC

NOTES:

WETLANDS DELINEATED BY WHITMAN, REQUARDT & ASSOCIATES IN JULY, AUGUST, SEPTEMBER, AND OCTOBER OF 2019 IN ACCORDANCE WITH THE 1987 CORPS OF ENGINEERS MANUAL AND THE 2012 ATLANTIC AND GULF COASTAL PLAIN REGIONAL SUPPLEMENT.

SHEETS PREPARED BY: WHITMAN, REQUARDT & ASSOCIATES, LLP
DATE: JANUARY 27, 2020
LAST UPDATED: MARCH 30, 2022

 ADDENDA / REVISIONS



CM/GC,
NORTH MILLSBORO BYPASS,
US 113 TO SR 24

CONTRACT	BRIDGE NO.	N/A
T202112701	DESIGNED BY:	S. BEALL
COUNTY	CHECKED BY:	T. OLIVER
SUSSEX		



ENVIRONMENTAL
COMPLIANCE PLAN

SECTION
WRA
SHEET NO.
95

PERMANENT OPEN WATER IMPACT AREA SCHEDULE					
ID	IMPACT DESCRIPTION	AREA (SF)	AREA (AC)	VOLUME (CY)	JURISDICTION
O-01	BRIDGE PIER FOUNDATION	32.00	0.0007	2.3704	DNREC
O-02	BRIDGE PIER FOUNDATION	32.00	0.0007	2.3704	DNREC
O-03	BRIDGE PIER FOUNDATION	32.00	0.0007	2.3704	DNREC
O-04	BRIDGE PIER FOUNDATION	32.00	0.0007	2.3704	DNREC
O-05	BRIDGE PIER FOUNDATION	32.00	0.0007	2.3704	DNREC
O-06	BRIDGE PIER FOUNDATION	32.00	0.0007	2.3704	DNREC
O-07	BRIDGE PIER FOUNDATION	8.00	0.0002	0.5926	DNREC
O-08	BRIDGE (SHADE)	33,722.00	0.7741	N/A	DNREC
TOTAL FOR THIS SHEET		33,922.00	0.7787	14.815	DNREC

PERMANENT WETLAND IMPACT AREA SCHEDULE					
ID	IMPACT DESCRIPTION	AREA (SF)	AREA (AC)	VOLUME (CY)	JURISDICTION
W-01	BRIDGE PIER FOUNDATION	0.13	0.000003	0.0096	USACE
W-02	BRIDGE PIER FOUNDATION	12.63	0.0003	0.9356	USACE
TOTAL FOR THIS SHEET		12.76	0.0003	0.9452	USACE


NOTE:
1. PERMANENT USACE IMPACTS ON THIS SHEET ARE CONSIDERED A LOSS.

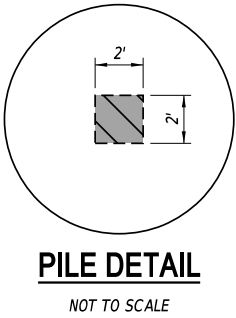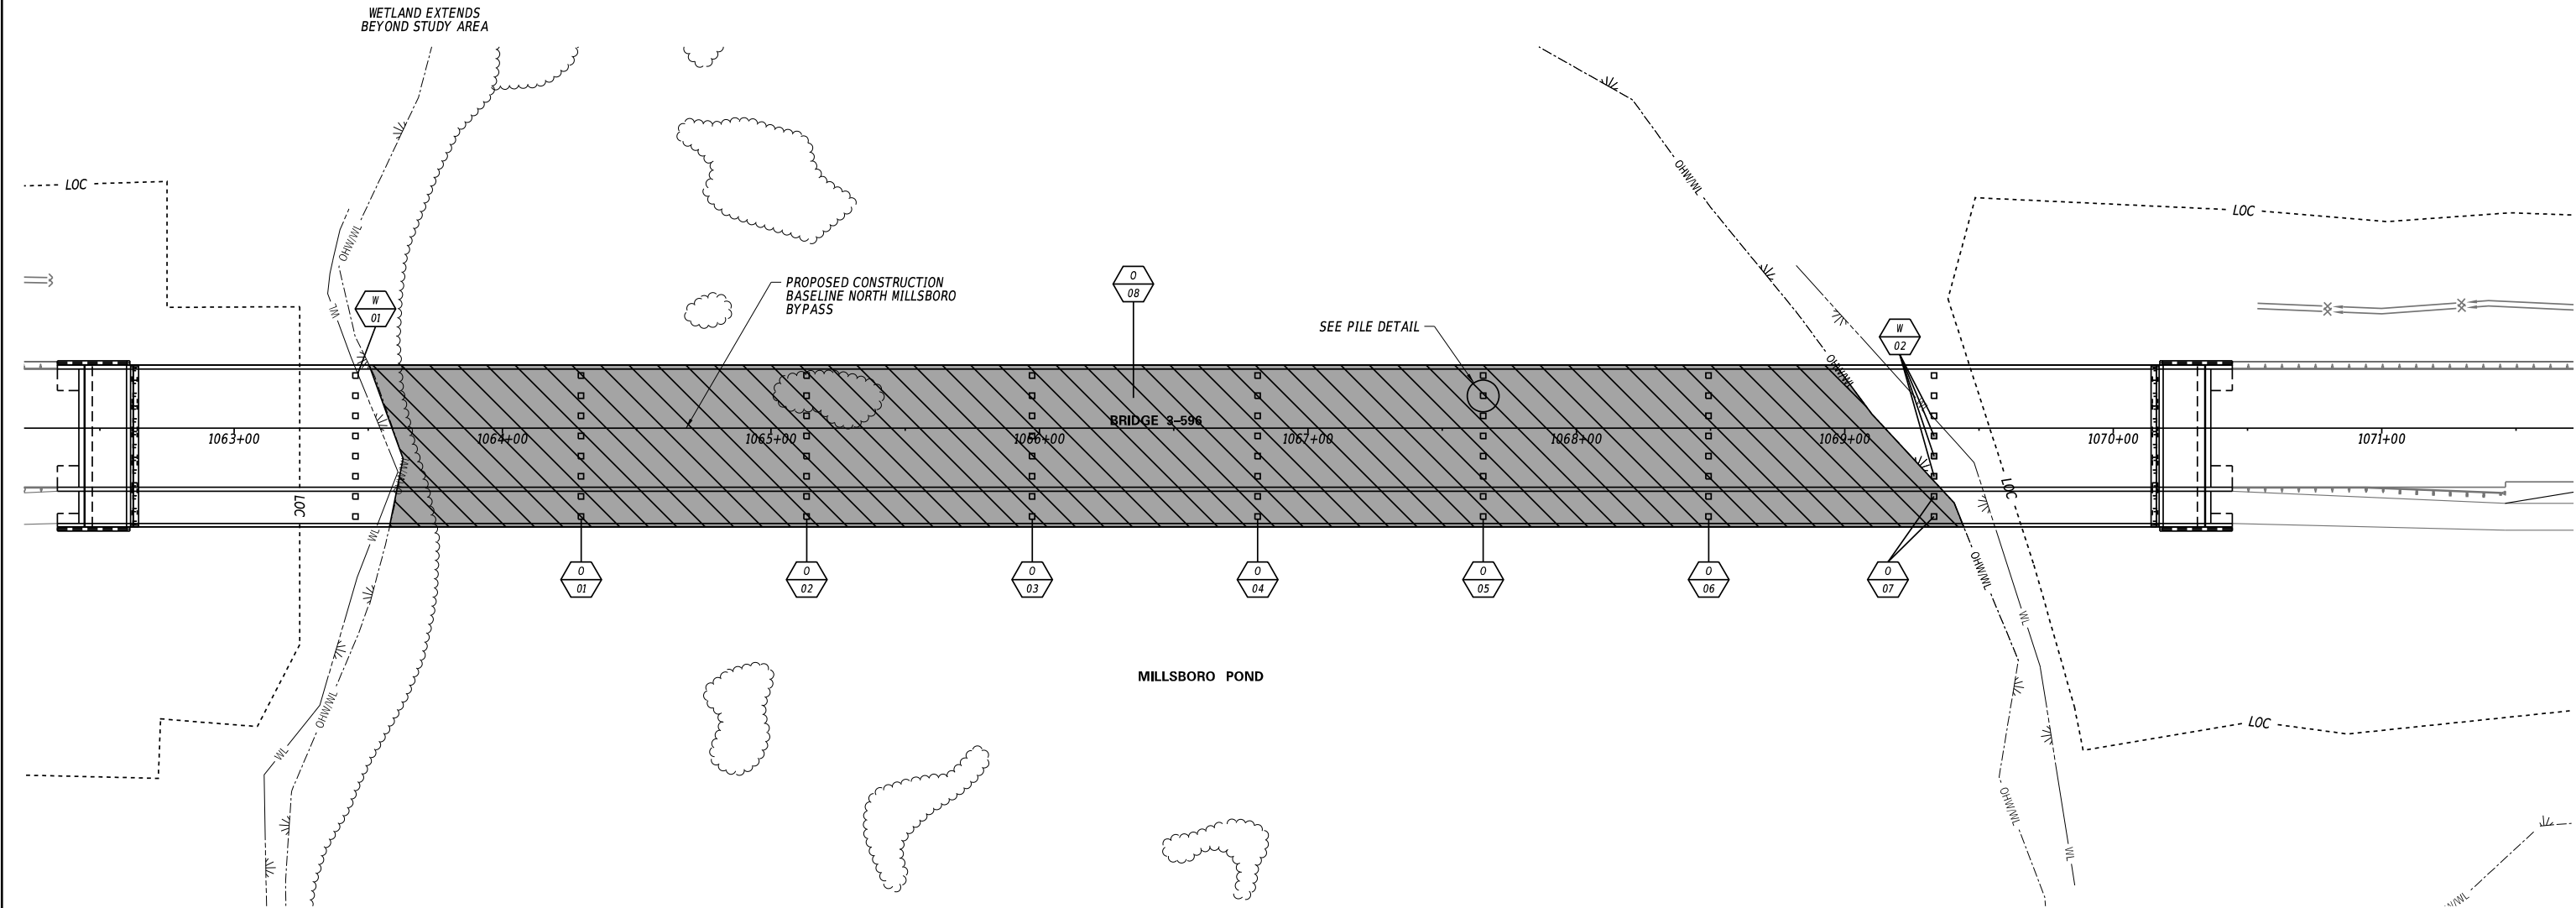

LEGEND	
	TEMPORARY IMPACT AREA
	PERMANENT IMPACT AREA
	WETLAND BOUNDARY
	ORDINARY HIGH WATER
	ORDINARY HIGH WATER / WETLAND
	LIMIT OF CONSTRUCTION
	IMPACT AREA TYPE ID. (SEE BELOW)
	IMPACT AREA ID. AND/OR NUMBER
O	OPEN WATER IMPACT
M	MARSH
W	WETLAND IMPACT
WT	TEMPORARY WETLAND IMPACT
OT	TEMPORARY OPEN WATER IMPACT

3/17/2022
8:34:34 AM
N:\132149-002\CADD\US 113 NM Bypass\EC02_NMBP.dgn

 ADDENDA / REVISIONS	



CM/GC,
NORTH MILLSBORO BYPASS,
US 113 TO SR 24


CONTRACT	BRIDGE NO.	3-596
T202112701	DESIGNED BY:	S. BEALL
COUNTY	CHECKED BY:	T. OLIVER
SUSSEX		

ENVIRONMENTAL COMPLIANCE PLAN	SECTION
	WRA
	SHEET NO. 96

PERMANENT OPEN WATER IMPACT AREA SCHEDULE					
ID	IMPACT DESCRIPTION	AREA (SF)	AREA (AC)	VOLUME (CY)	JURISDICTION
0-09	BRIDGE PIER FOUNDATION (FILL)	839.67	0.0193	62.1980	USACE/DNREC
0-10	BRIDGE PIER FOUNDATION (FILL)	803.48	0.0184	59.5170	USACE/DNREC
0-11	BRIDGE (SHADE)	6,542.65	0.1502	N/A	DNREC
0-12	BRIDGE (SHADE)	7,973.10	0.1830	N/A	DNREC
0-13	BRIDGE (SHADE)	5,652.76	0.1298	N/A	DNREC
TOTAL FOR THIS SHEET (USACE)		1643.15	0.0377	121.7150	USACE
TOTAL FOR THIS SHEET (DNREC)		21,811.66	0.5007	121.7150	DNREC

NOTE:
1. PERMANENT USACE IMPACTS ON THIS SHEET ARE CONSIDERED A LOSS.

TEMPORARY OPEN WATER IMPACT AREA SCHEDULE					
ID	IMPACT DESCRIPTION	AREA (SF)	AREA (AC)	VOLUME (CY)	JURISDICTION
OT-03	TRESTEL (PILES)	501.87	0.0115	37.176	USACE/DNREC
OT-04	TRESTEL (SHADE)	16,066.60	0.3688	N/A	DNREC
TOTAL FOR THIS SHEET (USACE)		501.87	0.0115	37.176	USACE
TOTAL FOR THIS SHEET (DNREC)		16,568.47	0.3803	37.176	DNREC

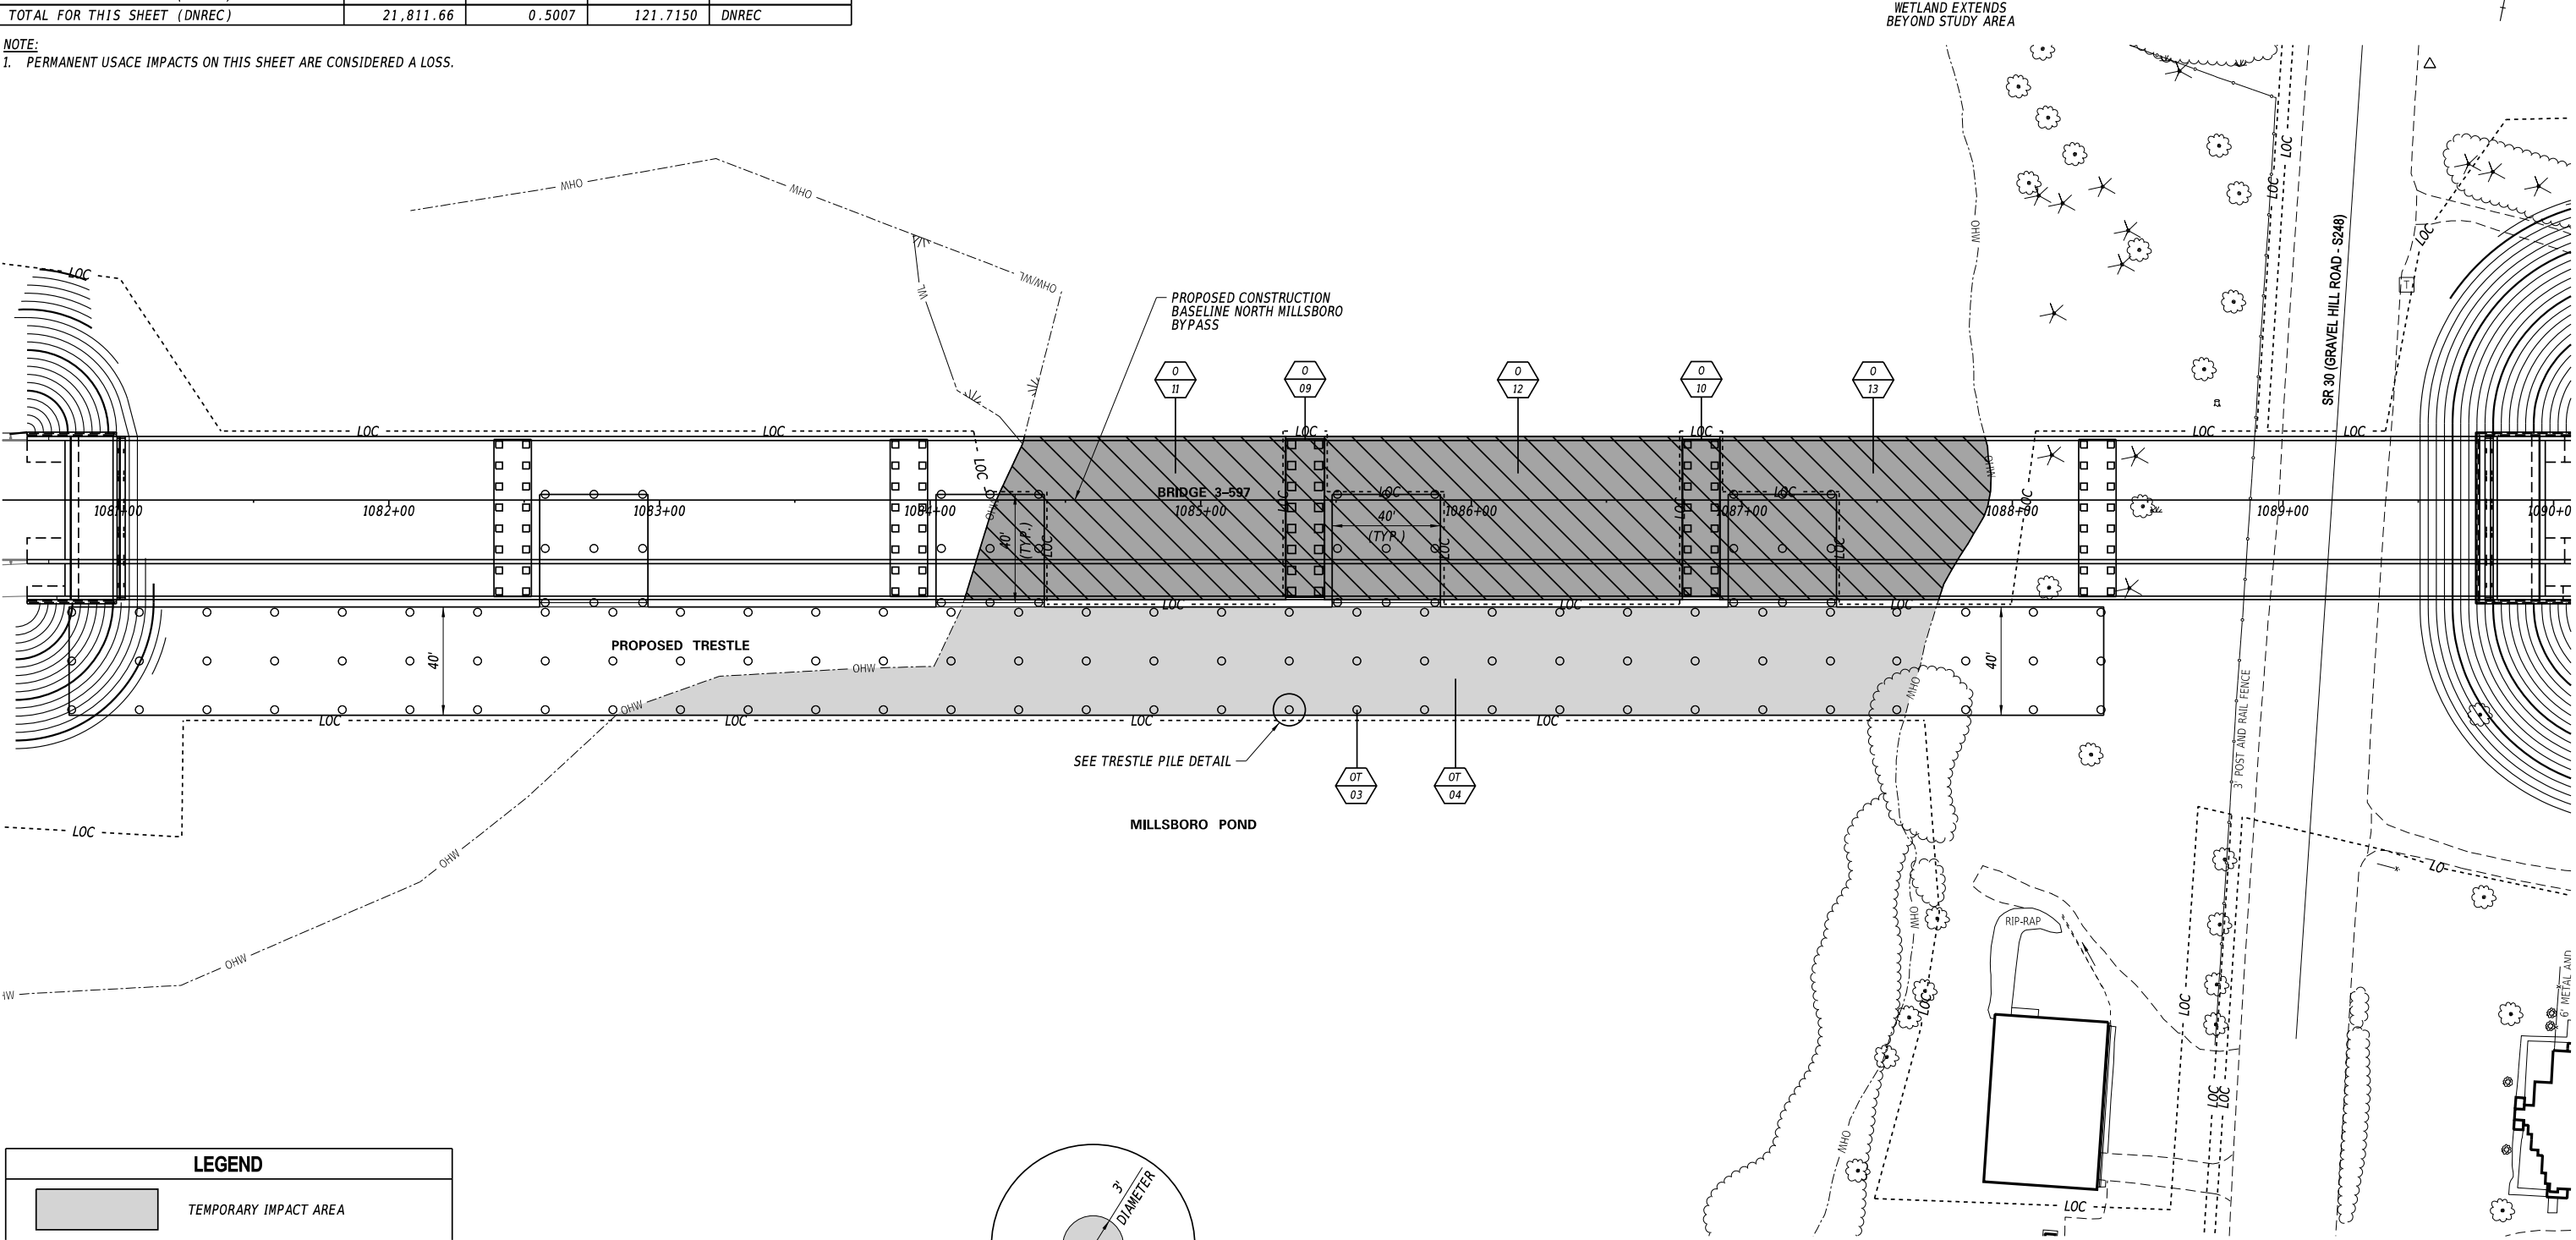

TEMPORARY IMPACT AREA

PERMANENT IMPACT AREA

WL - WETLAND BOUNDARY

OHW - ORDINARY HIGH WATER

OHW/WL - ORDINARY HIGH WATER / WETLAND


LOC - LIMIT OF CONSTRUCTION

XX

2X


IMPACT AREA TYPE ID. (SEE BELOW)
IMPACT AREA ID. AND/OR NUMBER

O = OPEN WATER IMPACT M = MARSH
W = WETLAND IMPACT
WT = TEMPORARY WETLAND IMPACT
OT = TEMPORARY OPEN WATER IMPACT

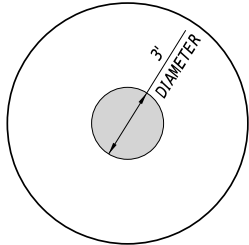

TRESTLE PILE DETAIL
NOT TO SCALE

 ADDENDA / REVISIONS



CM/GC,
NORTH MILLSBORO BYPASS,
US 113 TO SR 24

CONTRACT	BRIDGE NO.	3-597
T202112701	DESIGNED BY:	S. BEALL
COUNTY	CHECKED BY:	T. OLIVER
SUSSEX		

ENVIRONMENTAL
COMPLIANCE PLAN

SECTION
WRA
SHEET NO.
97